

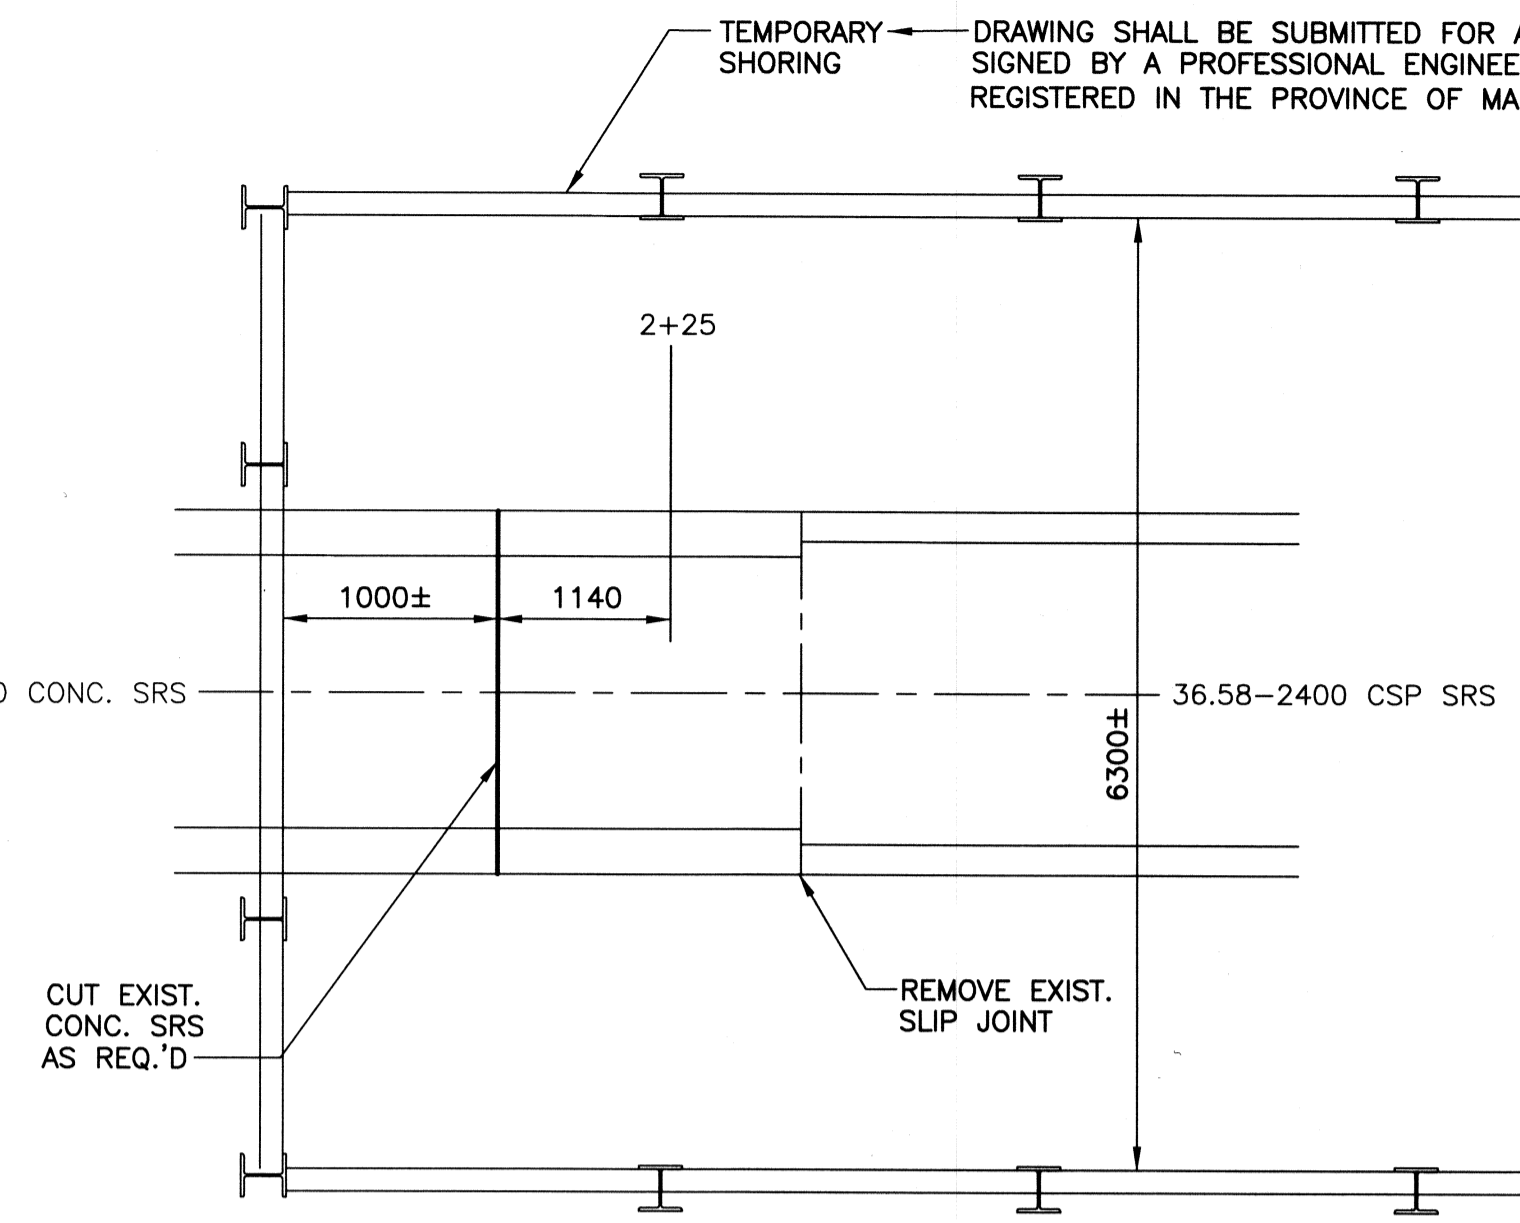


**LOCATION PLAN**  
SCALE: 1:250

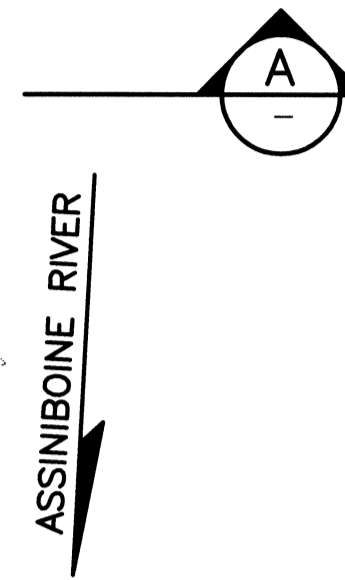

**EXISTING**

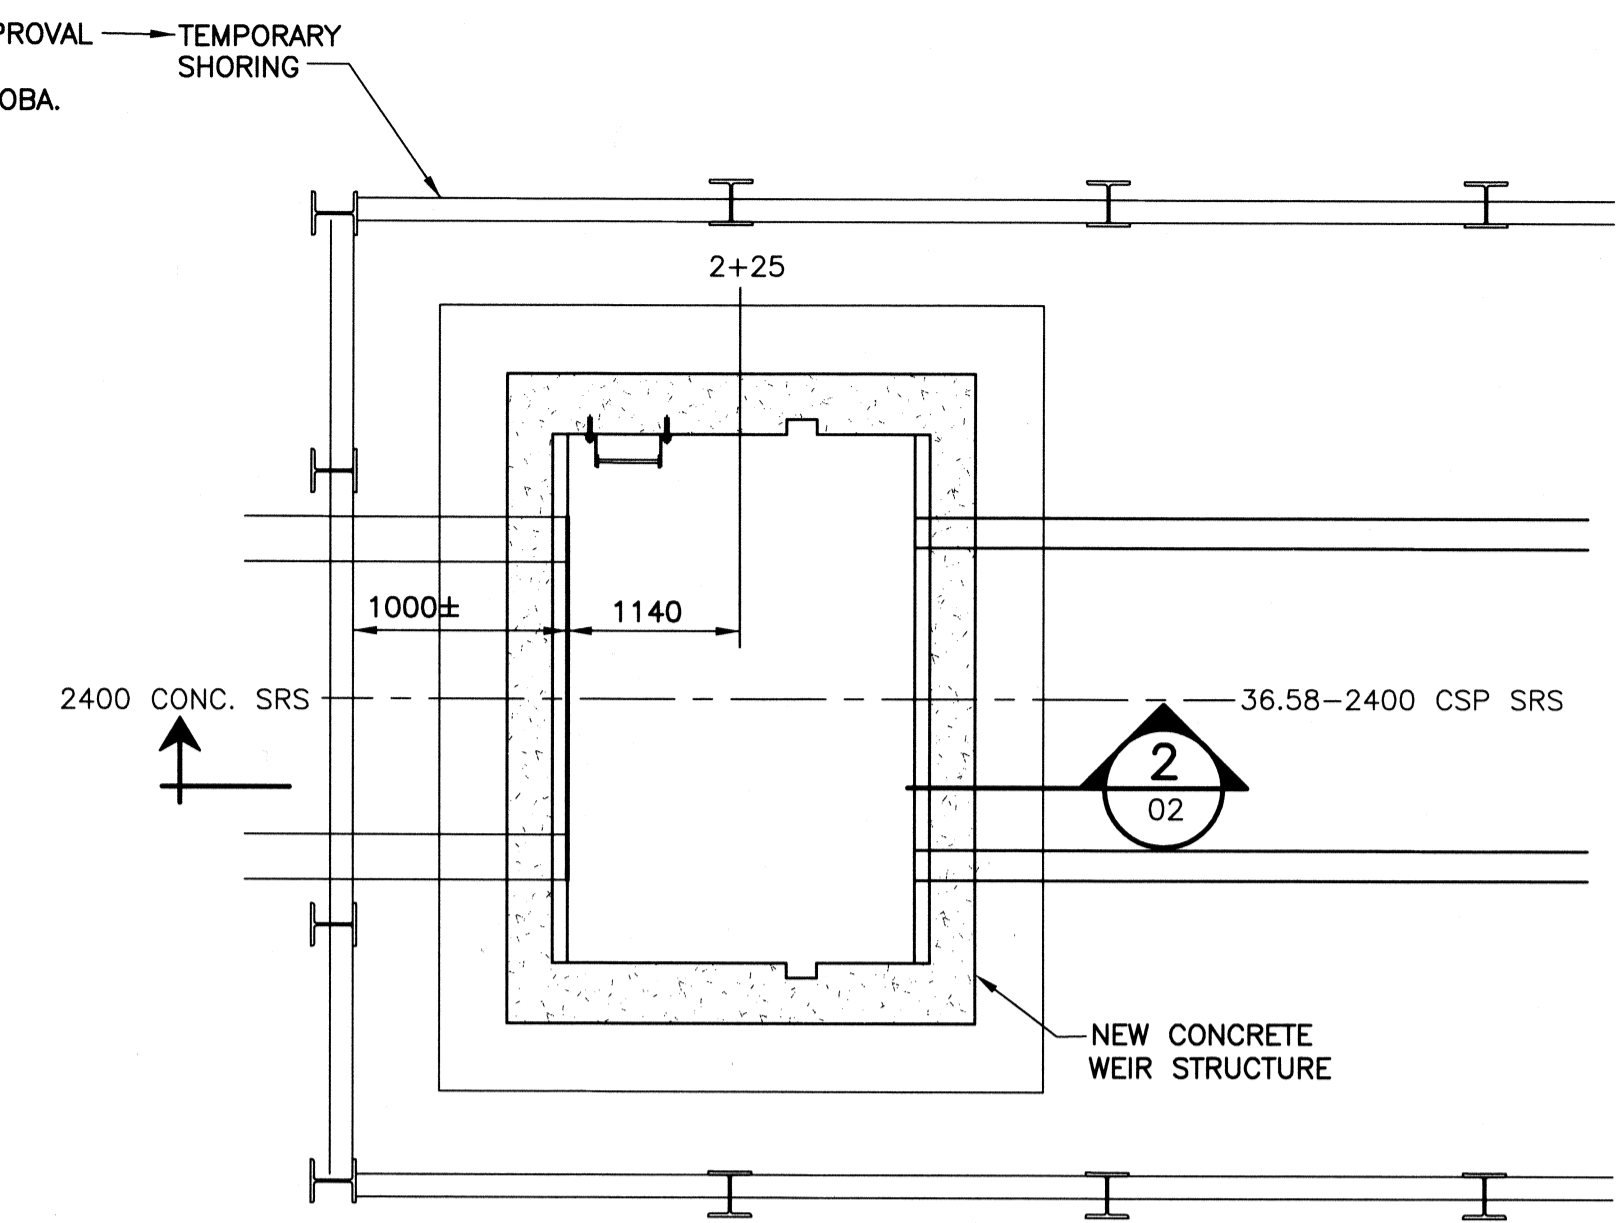


**PROPOSED**




**1** **DETAIL**  
SCALE: 1:50

**GENERAL NOTES**

1. THESE NOTES ARE TO BE READ IN CONJUNCTION WITH THE PROJECT SPECIFICATION.
  2. DO NOT SCALE DRAWINGS.
  3. ALL DIMENSIONS ARE GIVEN IN MILLIMETRES, EXCEPT ELEVATIONS ARE IN METRES.
  4. ALL WORKS IN THE FIELD TO INCORPORATE PROPER SAFETY PRECAUTIONS TO ENSURE THE SAFETY OF THE WORKERS.
  5. LOCATE SERVICES AND PROTECT THEM AT ALL TIMES DURING CONSTRUCTION.
- DAMP-PROOFING**
1. ALL EXTERIOR FACES OF CONCRETE BELOW GRADE SHALL BE COVERED WITH A DAMP-PROOFING COATING. DAMP-PROOFING COATING SHALL MEET THE REQUIREMENTS OF CGSB 37-GP-6M. CMHC ACCEPTANCE No. 3327.
  2. "BAKOR" PREMIUM FOUNDATION COATING 710-11 OR APPROVED EQUAL. A SUBSTITUTE PRODUCT SHALL MEET THE REQUIREMENTS STATED IN NOTE 1.
  3. PREPARATION AND APPLICATION SHALL BE AS SPECIFIED BY THE MANUFACTURER.

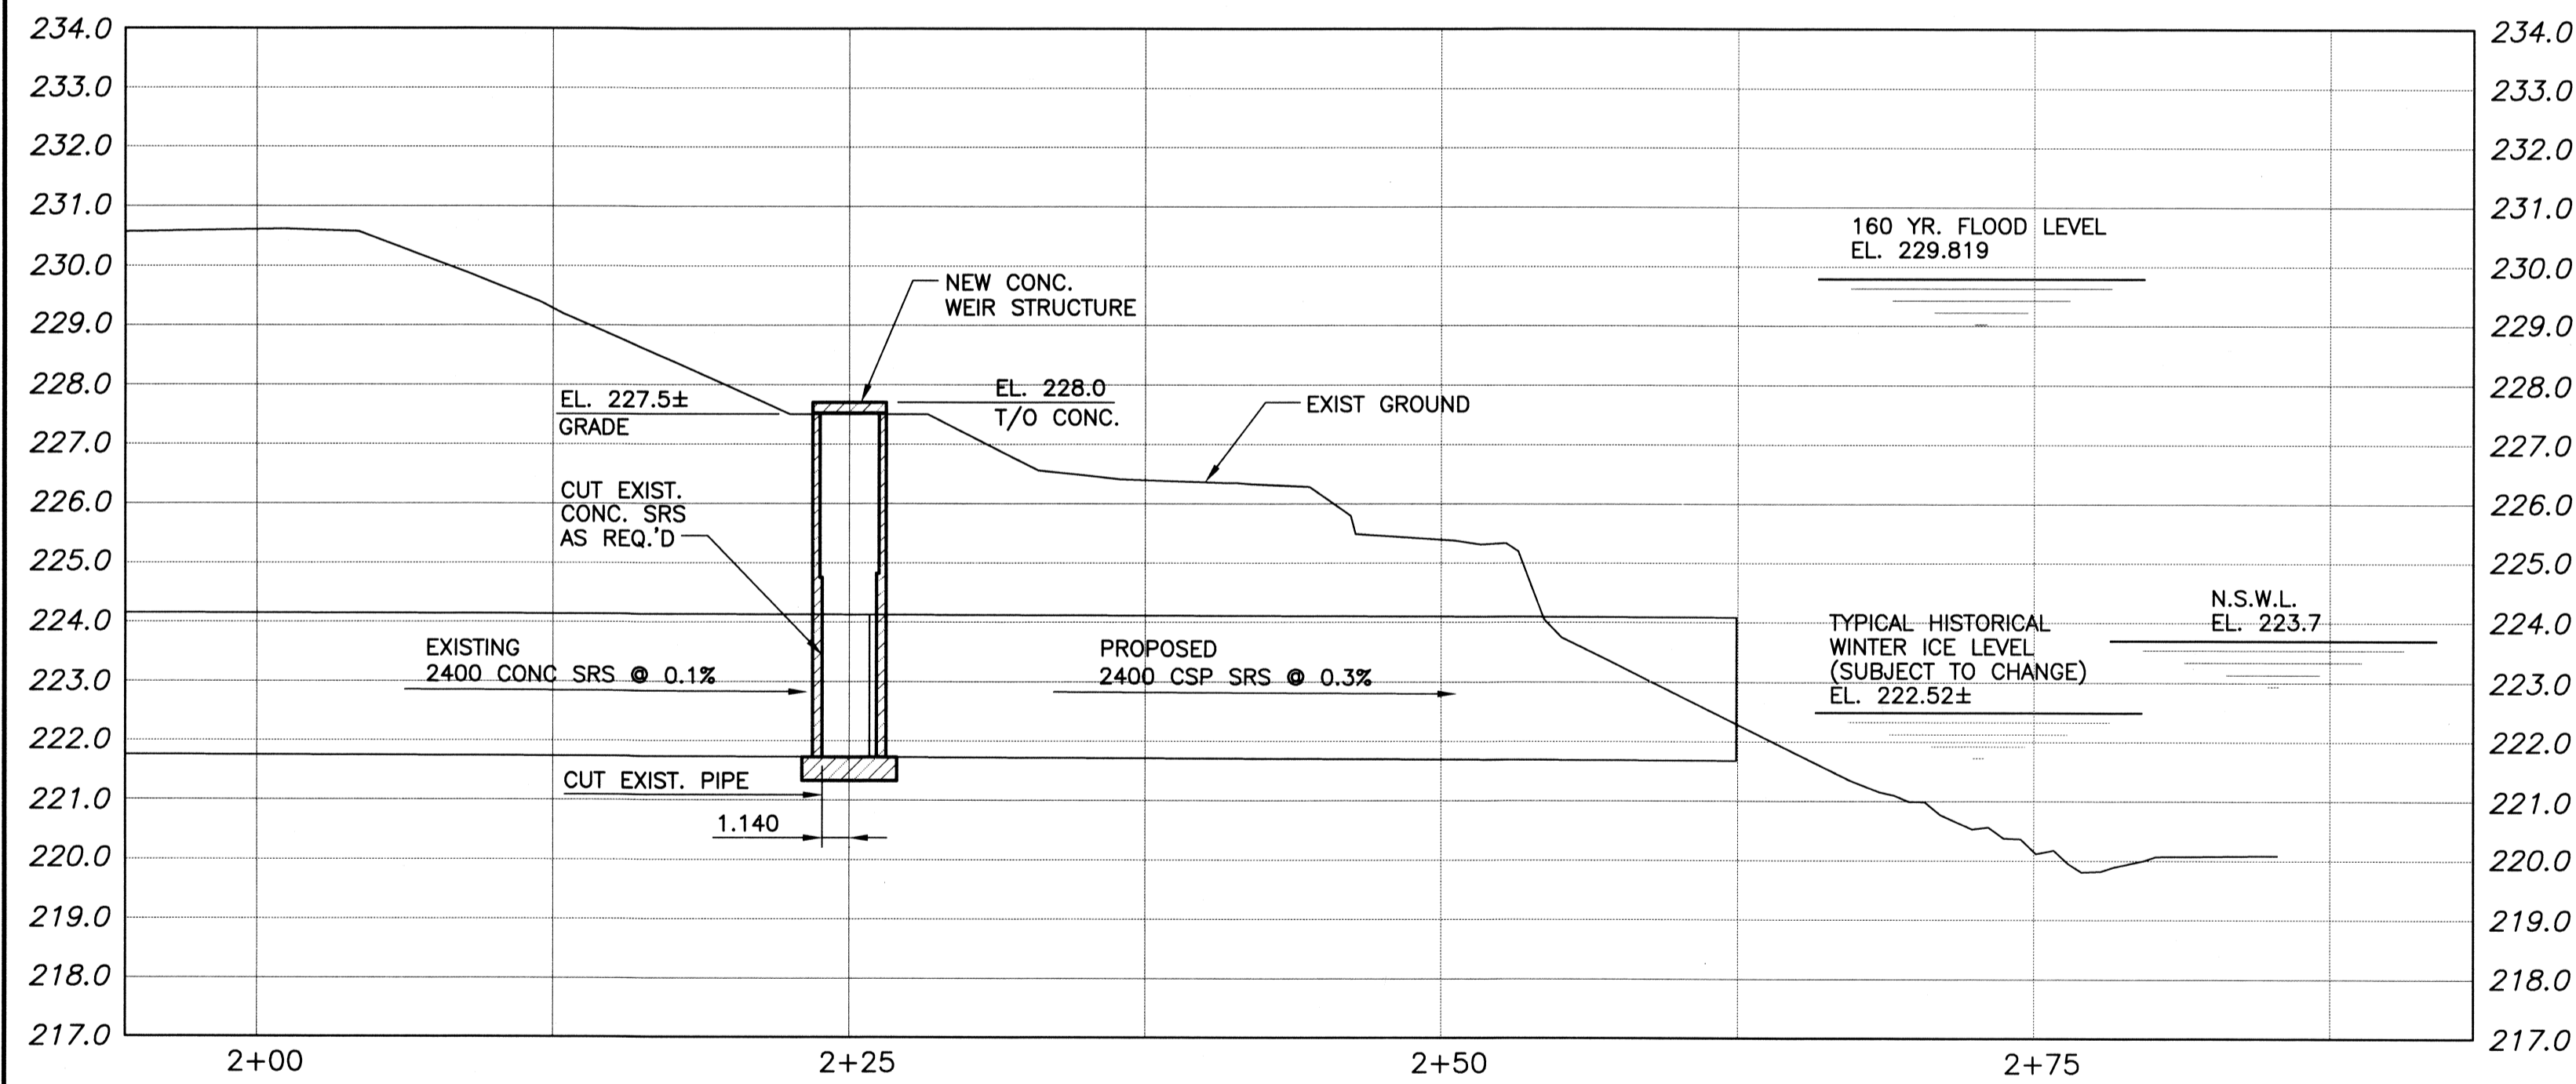

**A** **SECTION - PROFILE**  
SCALE: HOR 1:250  
VER 1:100

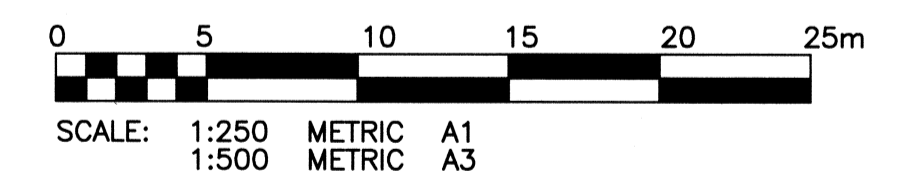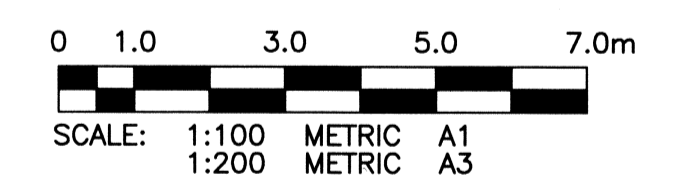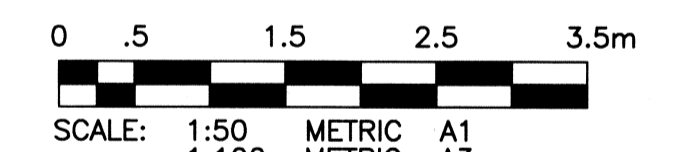

**METRIC**

WHOLE NUMBERS INDICATE MILLIMETRES  
DECIMALIZED NUMBERS INDICATE METRES



Certificate of Authorization

KGS Group

No. 245 Date: 11/29/07

PROJECT COMPLETION DATE

**THE CITY OF WINNIPEG**  
WATER & WASTE DEPARTMENT

FORT ROUGE PARK  
OUTFALL PIPE REPLACEMENT

**CONCRETE WEIR STRUCTURE**  
LOCATION PLAN AND PROFILE

SHEET **07** OF **10**  
CAD FILE DRAWING NUMBER  
**07-0107-08-07**  
CITY DRAWING NUMBER  
**LD-3779**

LOCATION APPROVED  
UNDERGROUND STRUCTURES


SUPV. U/G STRUCTURES DATE  
COMMITTEE

NOTE:  
LOCATION OF UNDERGROUND STRUCTURES AS SHOWN ARE BASED ON THE BEST INFORMATION AVAILABLE BUT NO GUARANTEE IS GIVEN THAT ALL EXISTING UTILITIES ARE SHOWN OR THAT THE GIVEN LOCATIONS ARE EXACT. CONFIRMATION OF EXISTENCE AND EXACT LOCATION OF ALL SERVICES MUST BE OBTAINED FROM THE INDIVIDUAL UTILITIES BEFORE PROCEEDING WITH CONSTRUCTION.

NO.	ISSUED FOR TENDER	03/12/07	RJH
NO.	REVISIONS	DATE	BY

**KGS GROUP** CONSULTING ENGINEERS & PROJECT MANAGERS  
WINNIPEG (204) 896-1209  
THUNDER BAY (807) 345-2233

DESIGNED BY	RJL	CHECKED BY	RJL
DRAWN BY	JF	APPROVED BY	
HOR. SCALE:	1:250	RELEASED FOR CONSTRUCTION:	
VERTICAL:		DATE	01/11/07

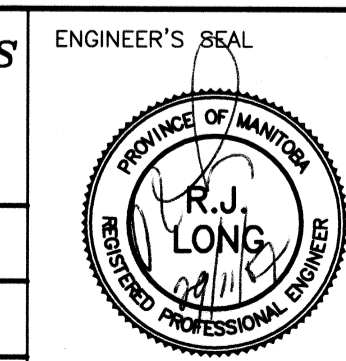

CONSULTANT DRAWING NO.  
**07-0107-08 07**