

A
B01 MAIN FLOOR PLAN
1:30


* PUMP CONTROL AND ALARM PANEL SUPPLIED BY THE CITY OF WINNIPEG.

BUILDING CODE SUMMARY:

BUILDING CLASSIFICATION: F3 UNDER HOUSING AND SMALL BUILDING
NBC 3.1.2.2. TABLE 3.1.2.1
BUILDING AREA: 28.96 m²
OCCUPANT LOAD: 0 PERSONS
FIRE RATING: NONE REQUIRED

PRELIMINARY

METRIC
WHOLE NUMBERS INDICATE MILLIMETERS
DECIMALIZED NUMBERS INDICATE METERS

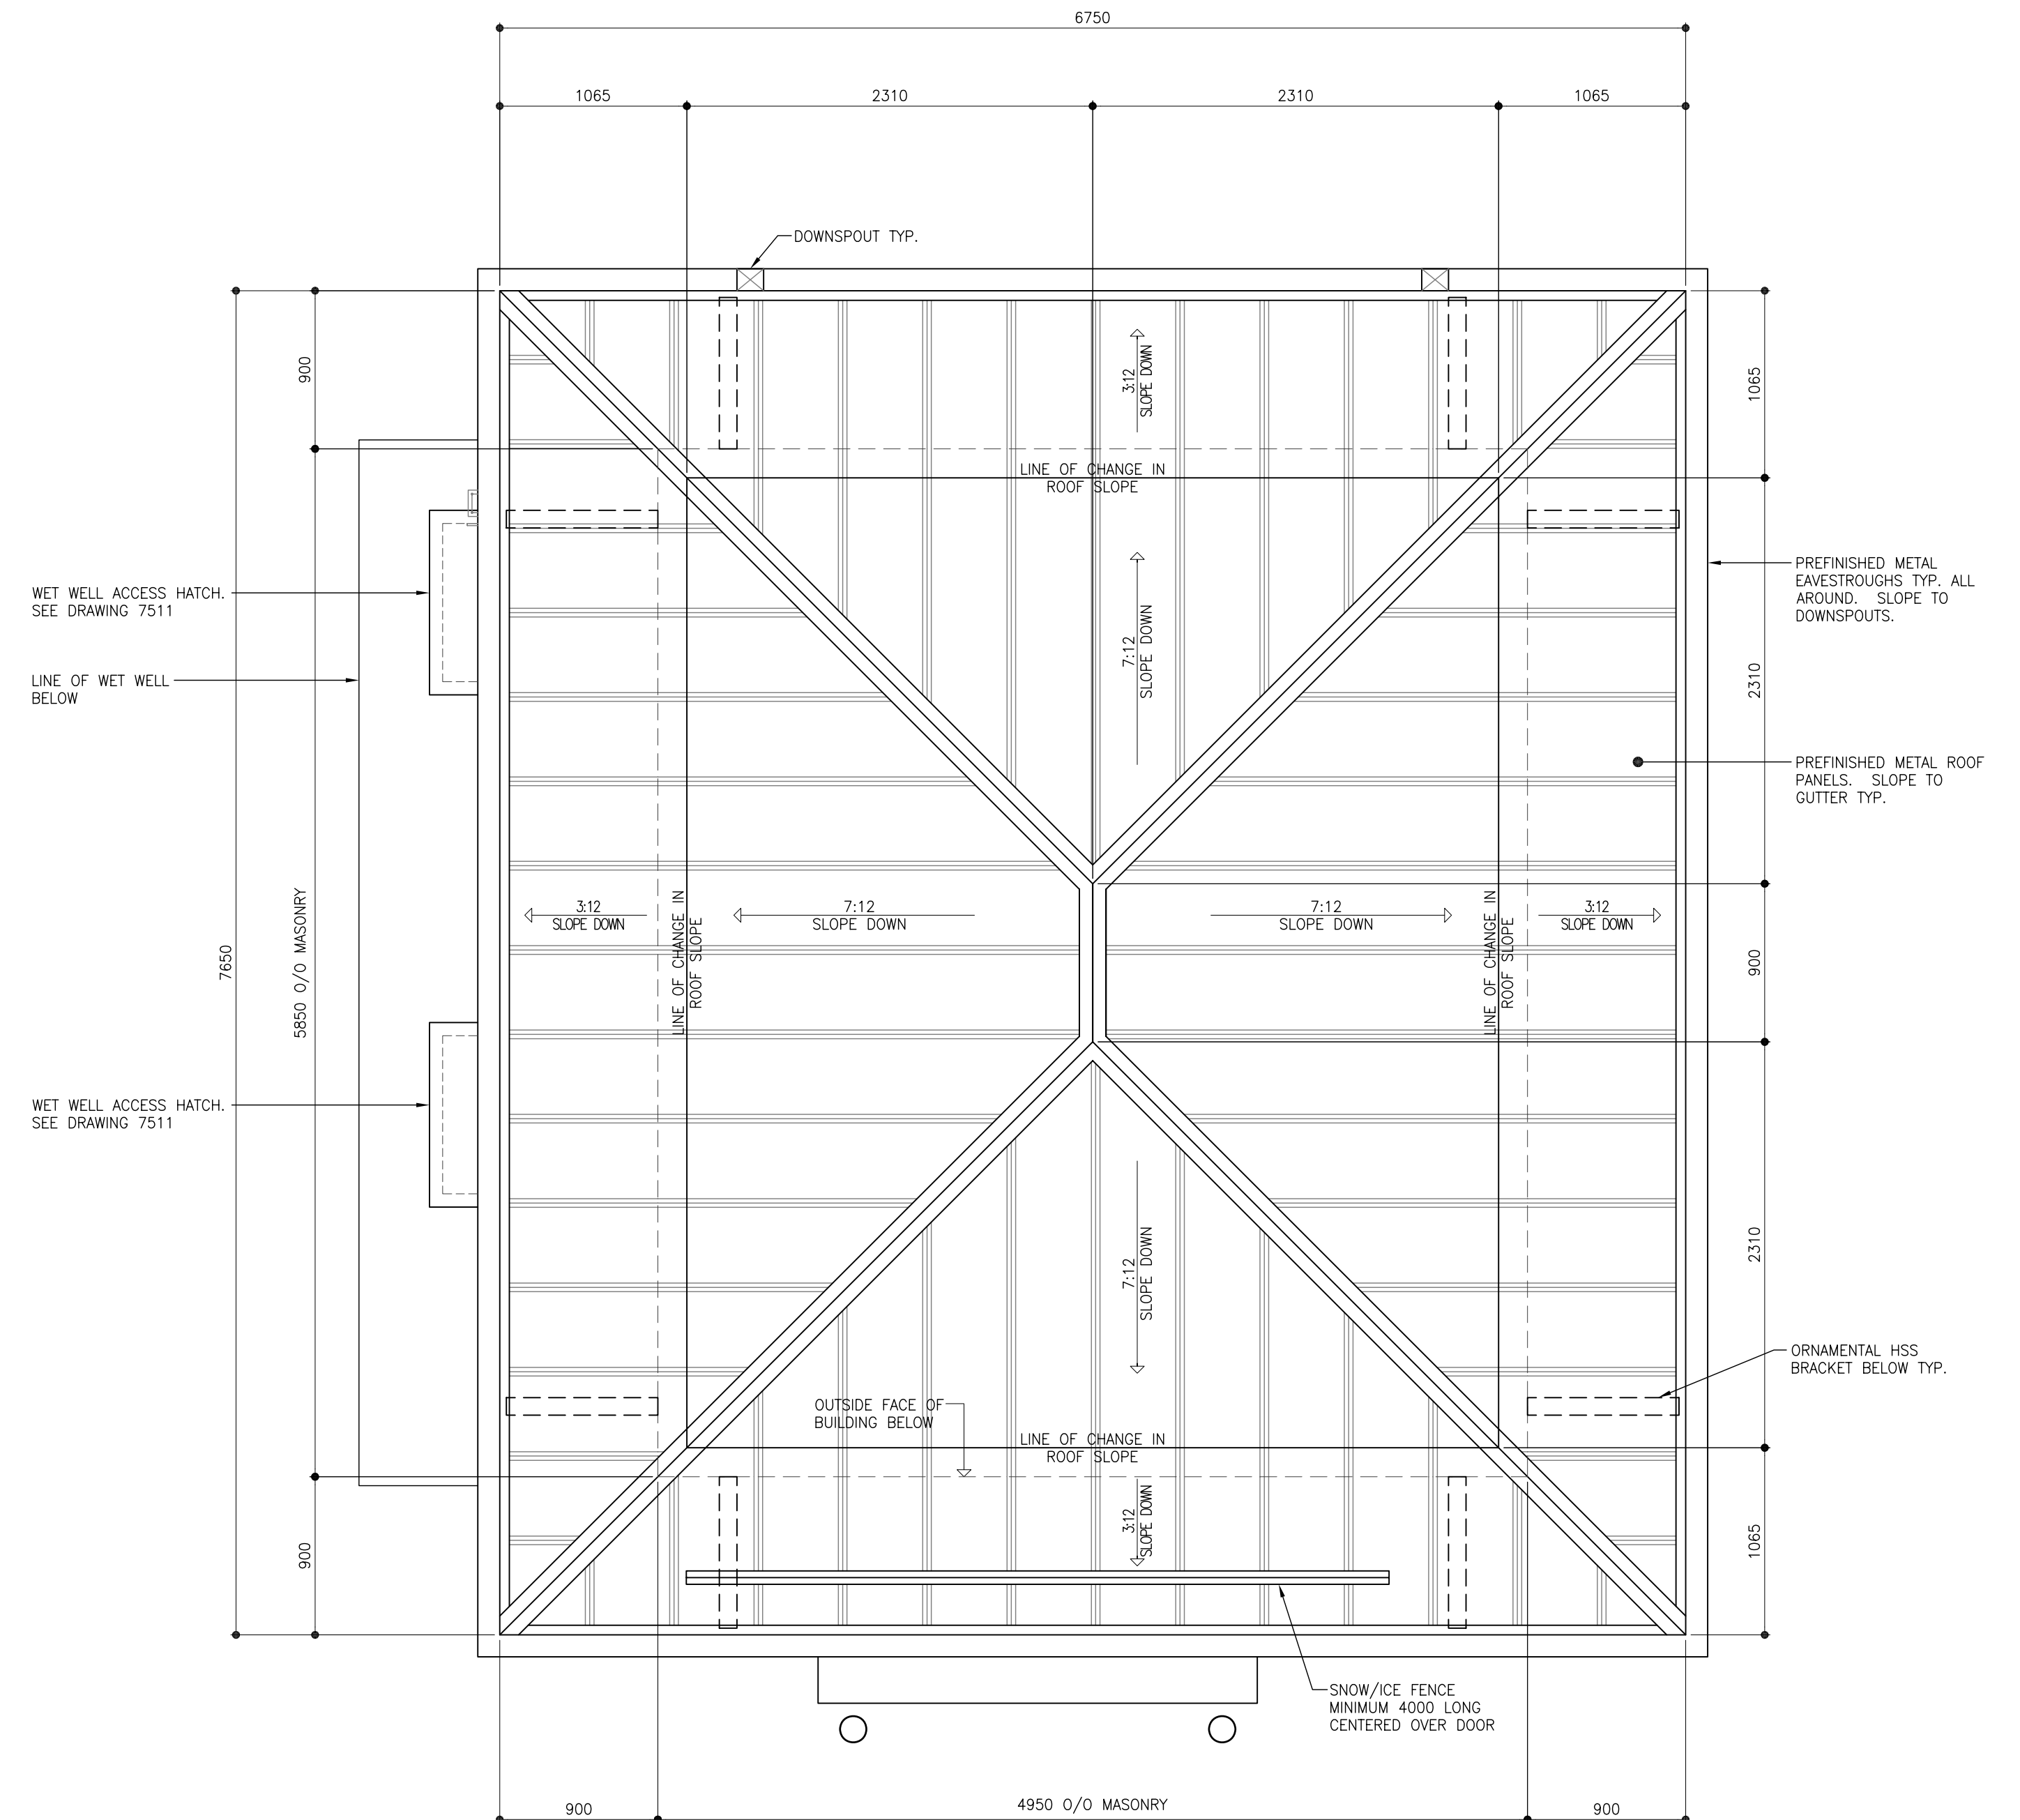

B
B01 ROOF PLAN
1:30

			<p>Accutech Engineering Inc. Tomorrow's Technology Today 605-287 Broadway, Winnipeg, Manitoba Canada R3C-0R9 Phone (204) 944-1353 Fax (204) 944-1444 www.accutech.org.ca</p>		ENGINEER'S SEAL ORIGINAL SIGNED BY K.R. DRYSDALE 08/02/11		<p>THE CITY OF WINNIPEG WATER AND WASTE DEPARTMENT</p>	
			DESIGNED BY PG DRAWN BY RK	CHECKED BY PG APPROVED BY KD		DUGALD ROAD WASTEWATER PUMPING STATION MAIN FLOOR AND ROOF PLAN		
			HOR. SCALE AS SHOWN VERTICAL AS SHOWN		RELEASED FOR CONSTRUCTION SIGNED BY K. ZUREK		CONSULTANT DRAWING NUMBER B01	
NO. REVISIONS DATE BY			DATE FEB 11, 2008 DATE 08/02/13		BID OPPORTUNITY 892-2007 PLOT DATE:		SHEET 2 OF 14 CITY DRAWING NUMBER 7501	