



1 TYPICAL WALL SECTION
B04 1:10


METRIC
WHOLE NUMBERS INDICATE MILLIMETRES
DECIMALIZED NUMBERS INDICATE METRES

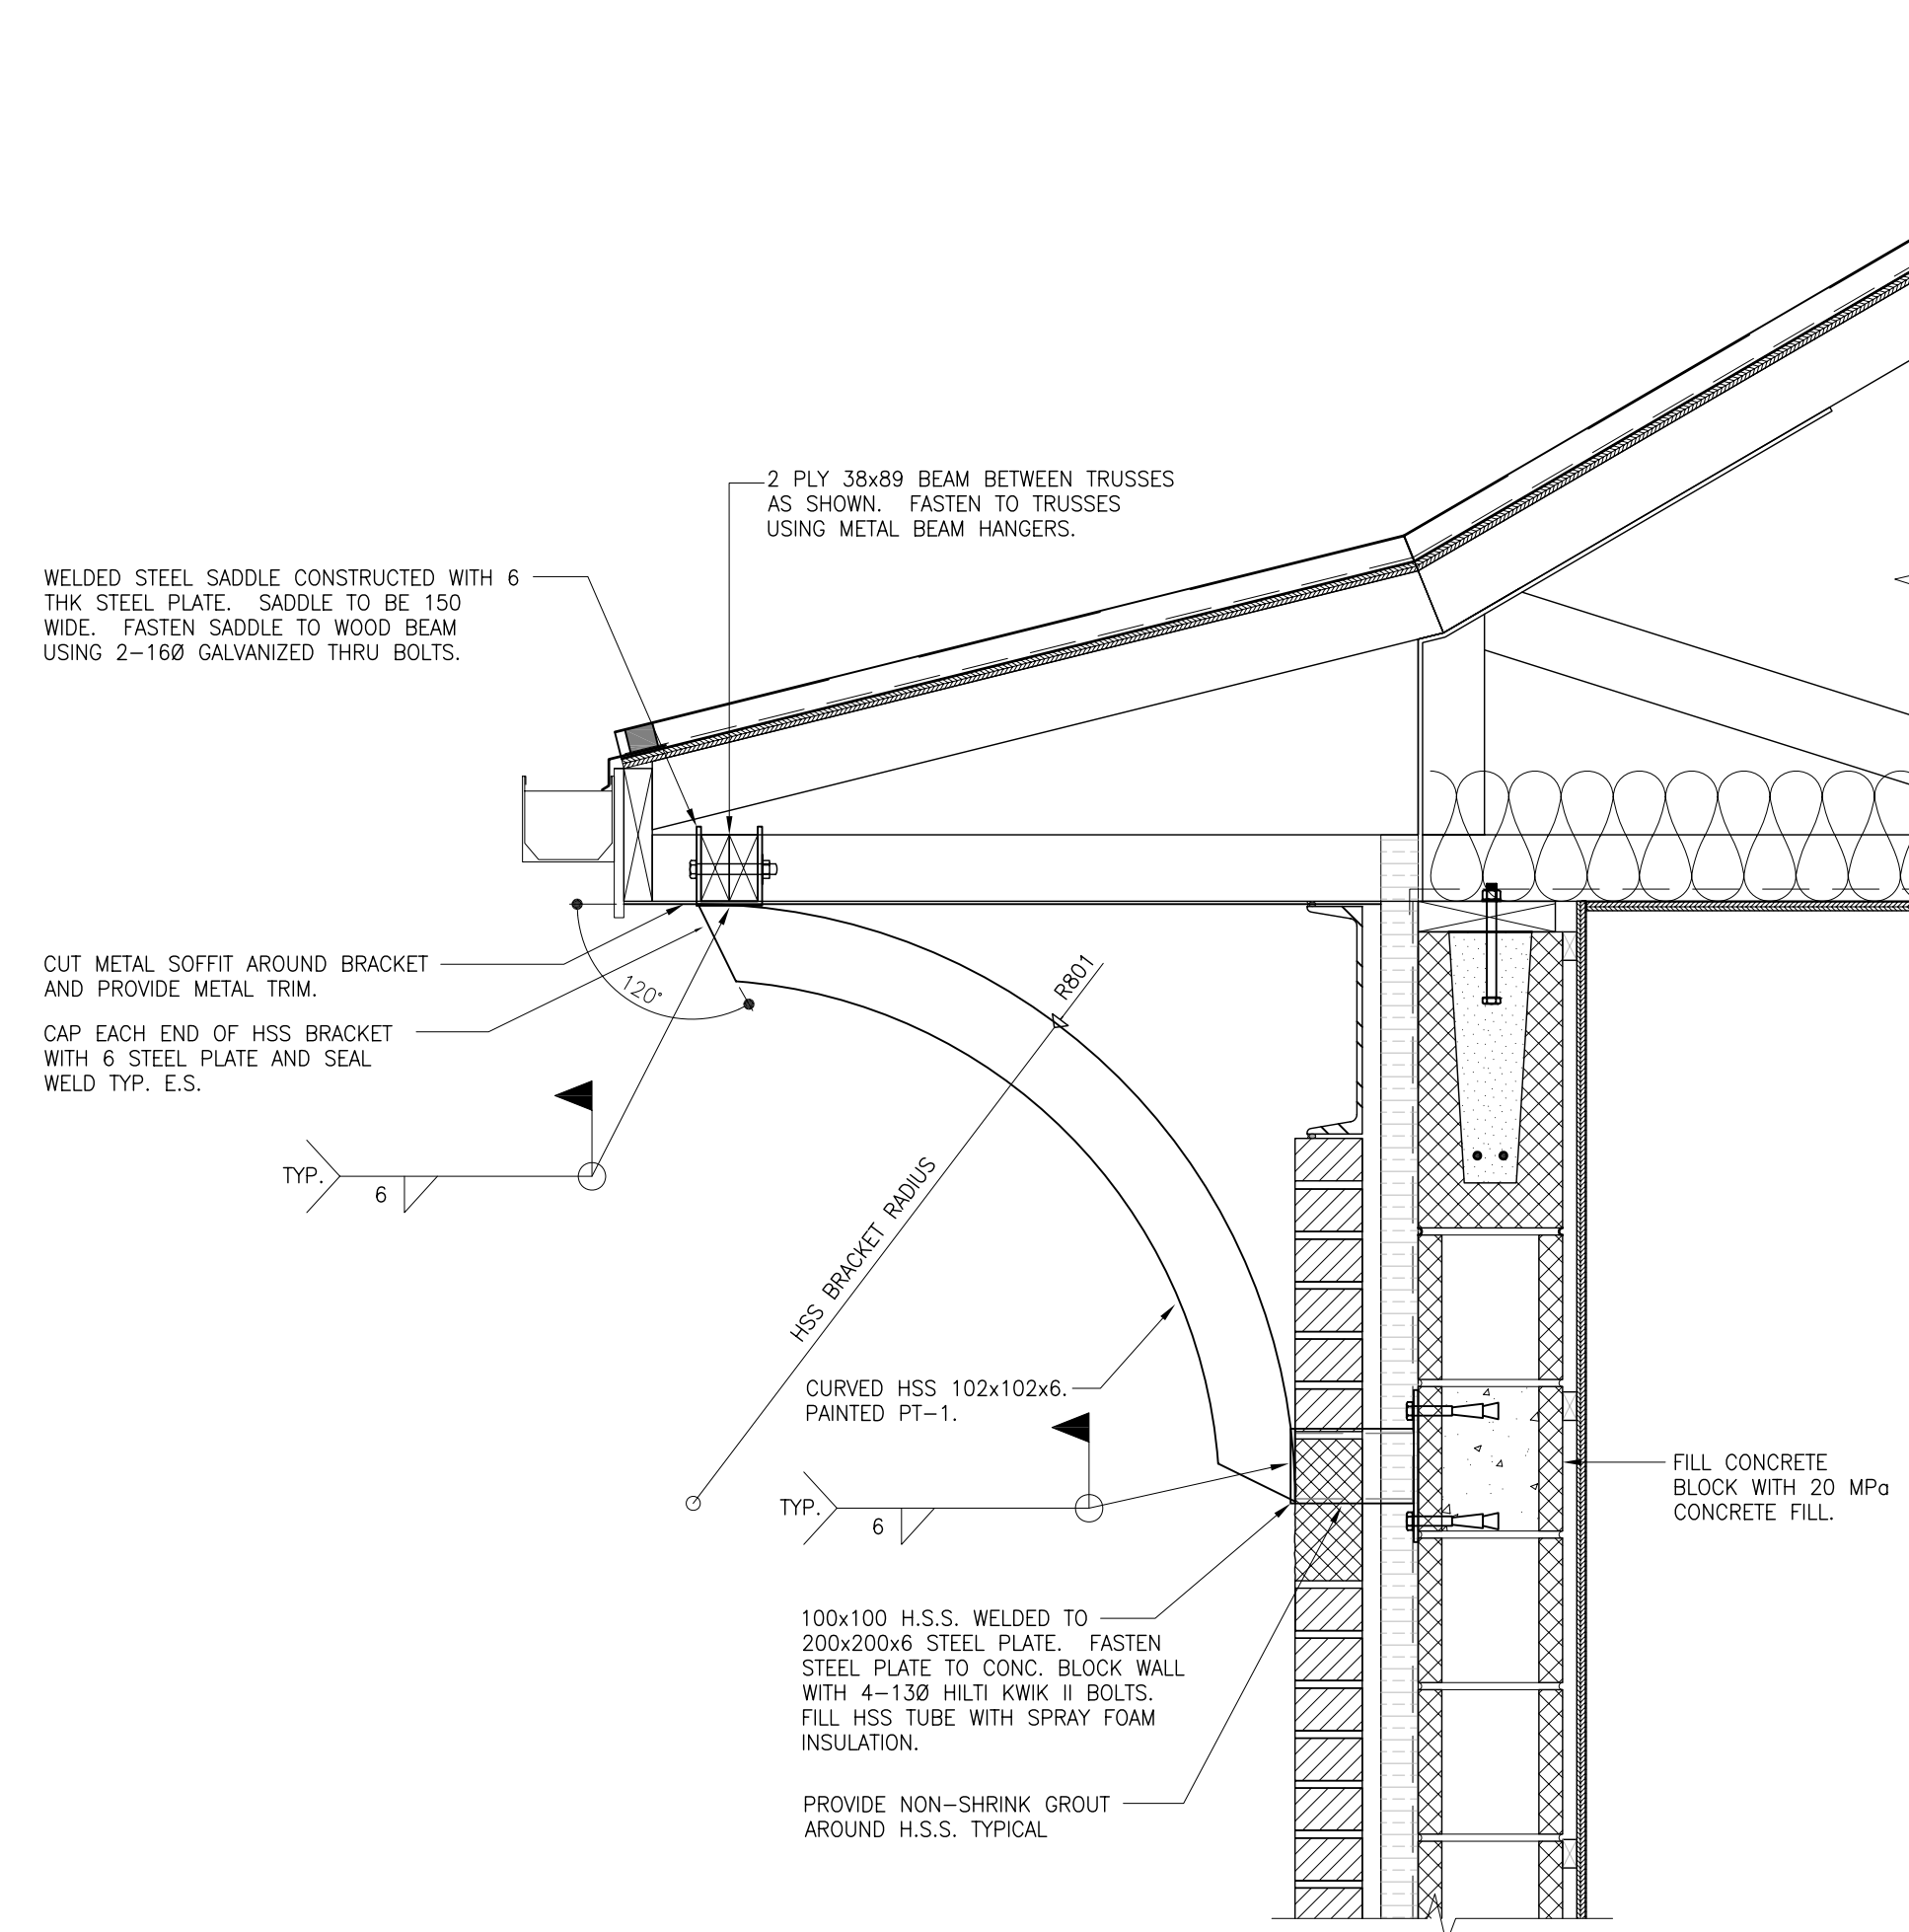


2 HSS BRACKET SECTION
B04 1:10

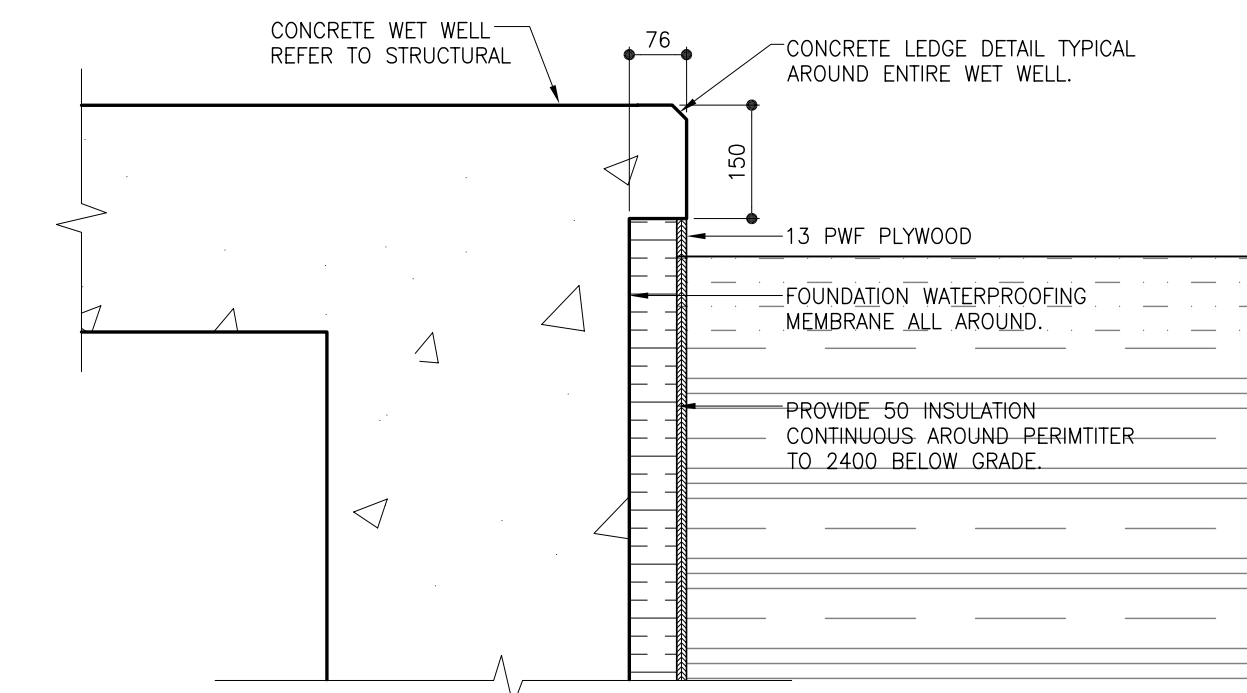


3 CONCRETE EDGE SECTION
B04 1:10

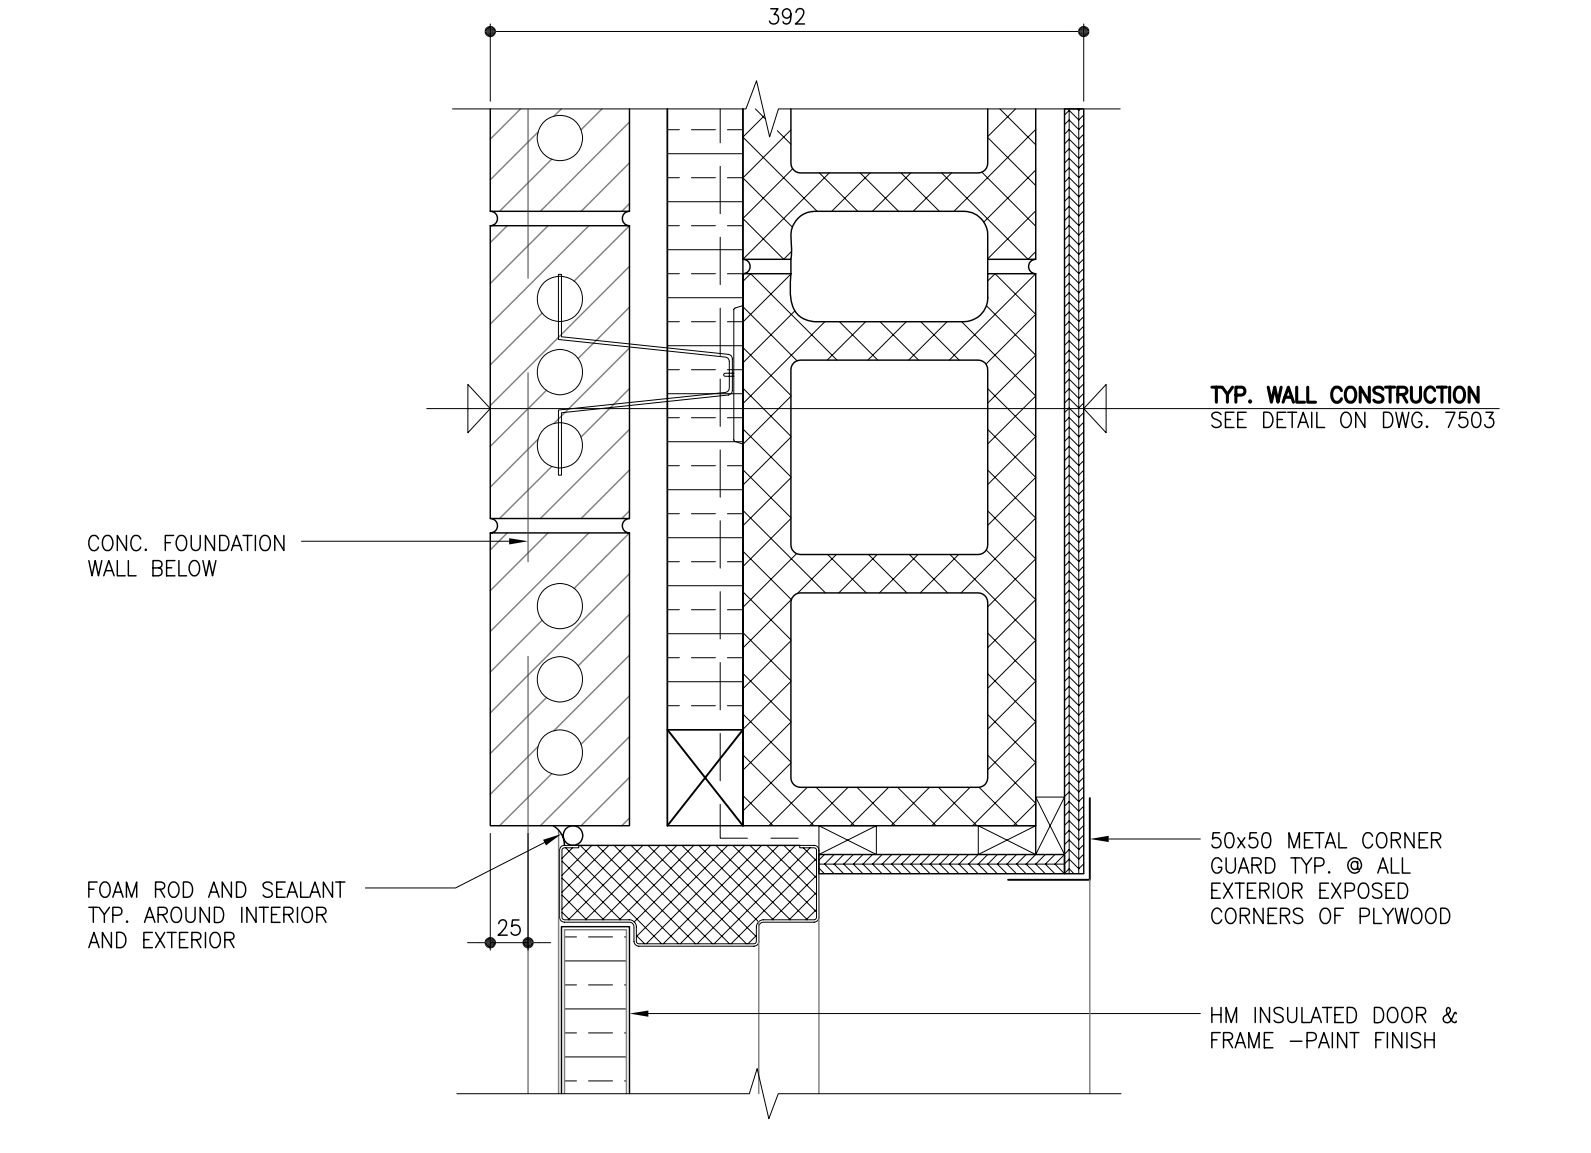

A JAMB DETAIL
B04 1:5

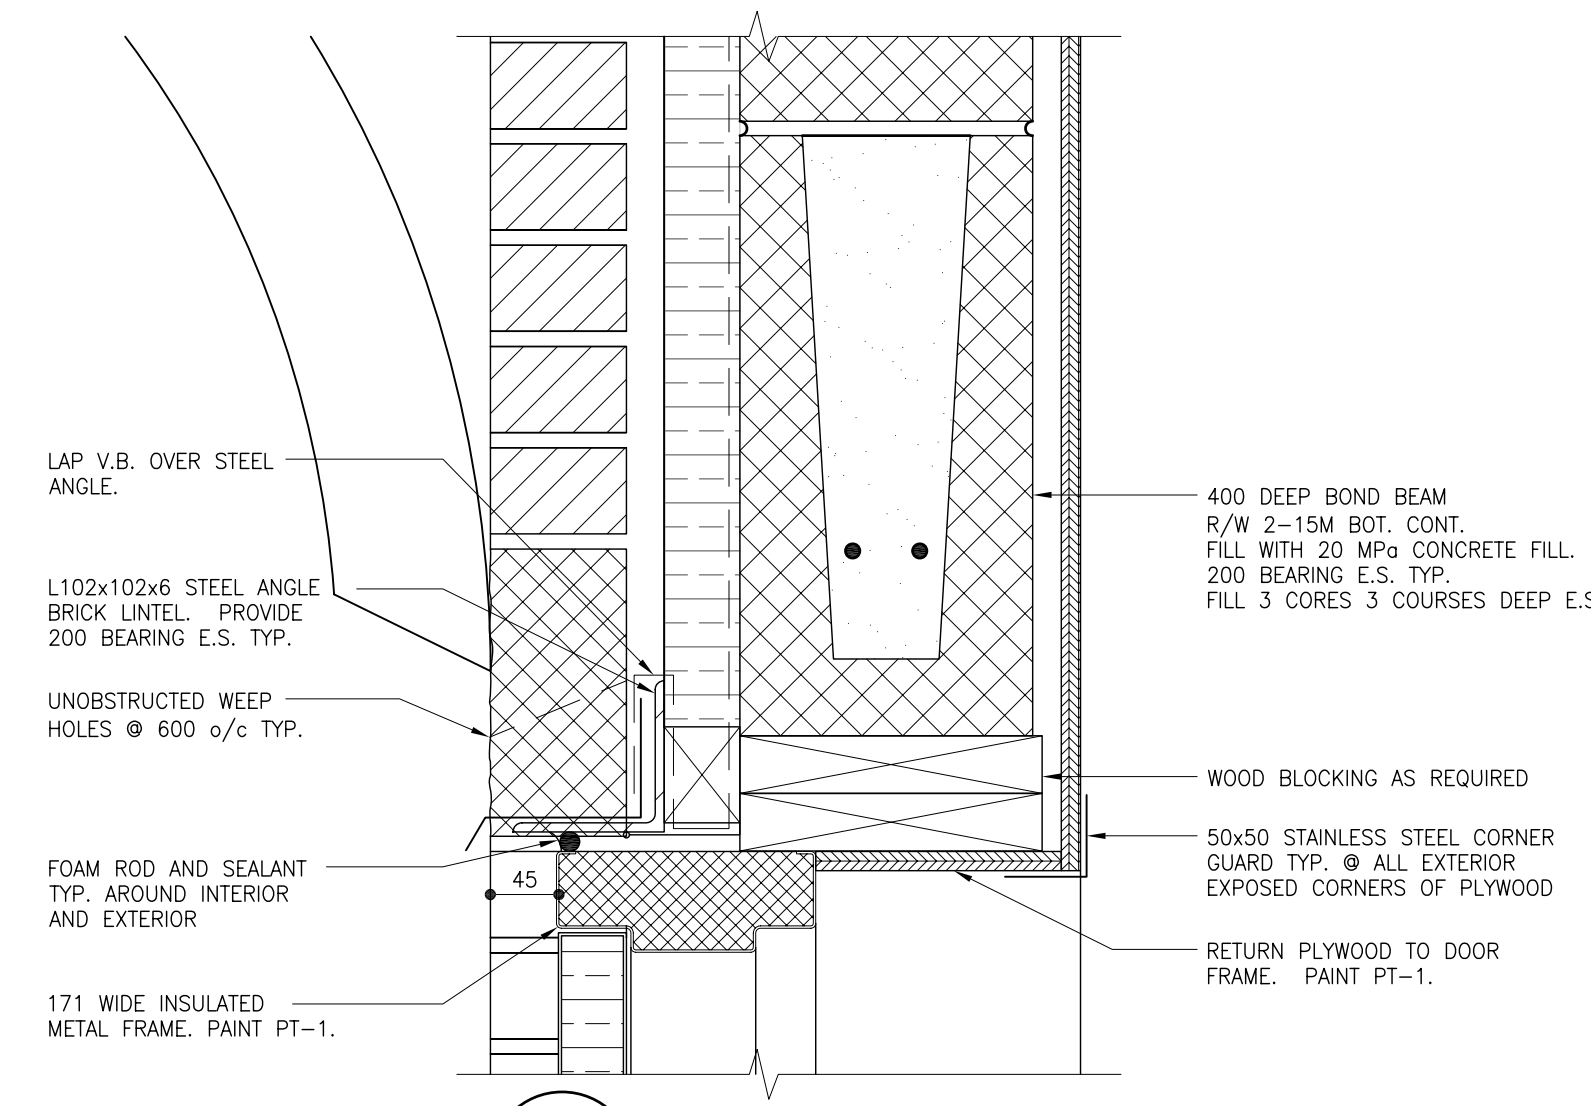

B LINTEL DETAIL
B04 1:5

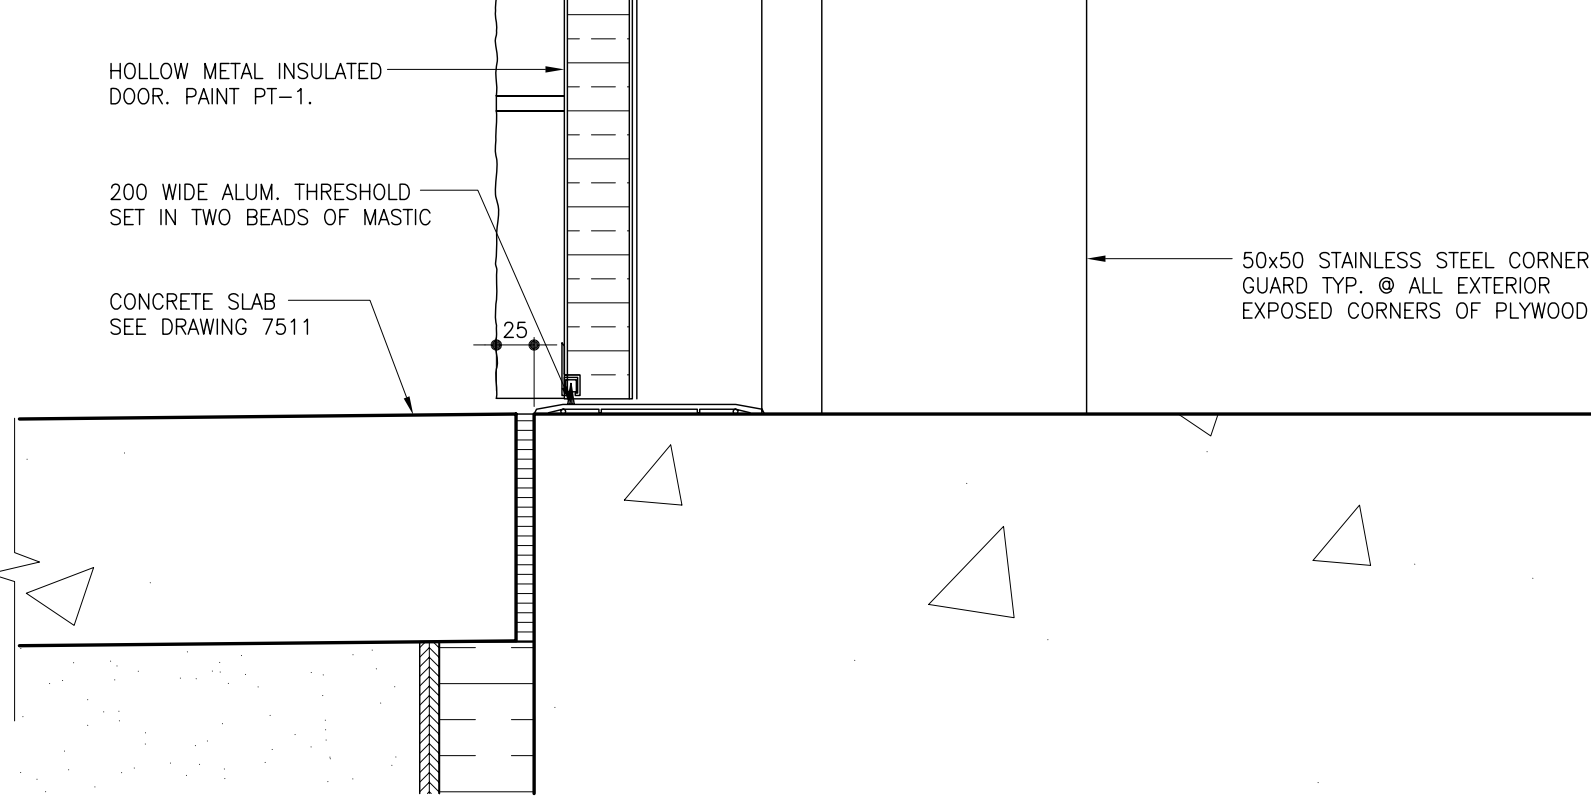

C THRESHOLD DETAIL
B04 1:5

<p>Accutech Engineering Inc. Tomorrow's Technology Today 605-287 Broadway, Winnipeg, Manitoba Canada R3C-0R9 Phone (204) 944-1555 Fax (204) 944-1444 www.accutechinc.ca</p>				<p>ENGINEER'S SEAL</p> <p>ORIGINAL SIGNED BY K.R. DRYSDALE 08/02/11</p>		<p>THE CITY OF WINNIPEG WATER AND WASTE DEPARTMENT</p> <p>DUGALD ROAD WASTEWATER PUMPING STATION SECTIONS AND DETAILS</p>		<p>CONSULTANT DRAWING NUMBER B04</p> <p>SHEET 5 OF 14</p> <p>CITY DRAWING NUMBER 7504</p>	
DESIGNED BY	PG	CHECKED BY	PG	APPROVED BY	KD	<p>BID OPPORTUNITY 892-2007 PLOT DATE:</p>			
DRAWN BY	RK	APPROVED BY	KD	<p>HOR. SCALE VERTICAL AS SHOWN</p>		<p>RELEASED FOR CONSTRUCTION SIGNED BY K. ZUREK</p>			
NO.	REVISIONS	DATE	BY	DATE	FEB 11, 2008	DATE	08/02/13		