


SITE PLAN

SCALE: 1:250

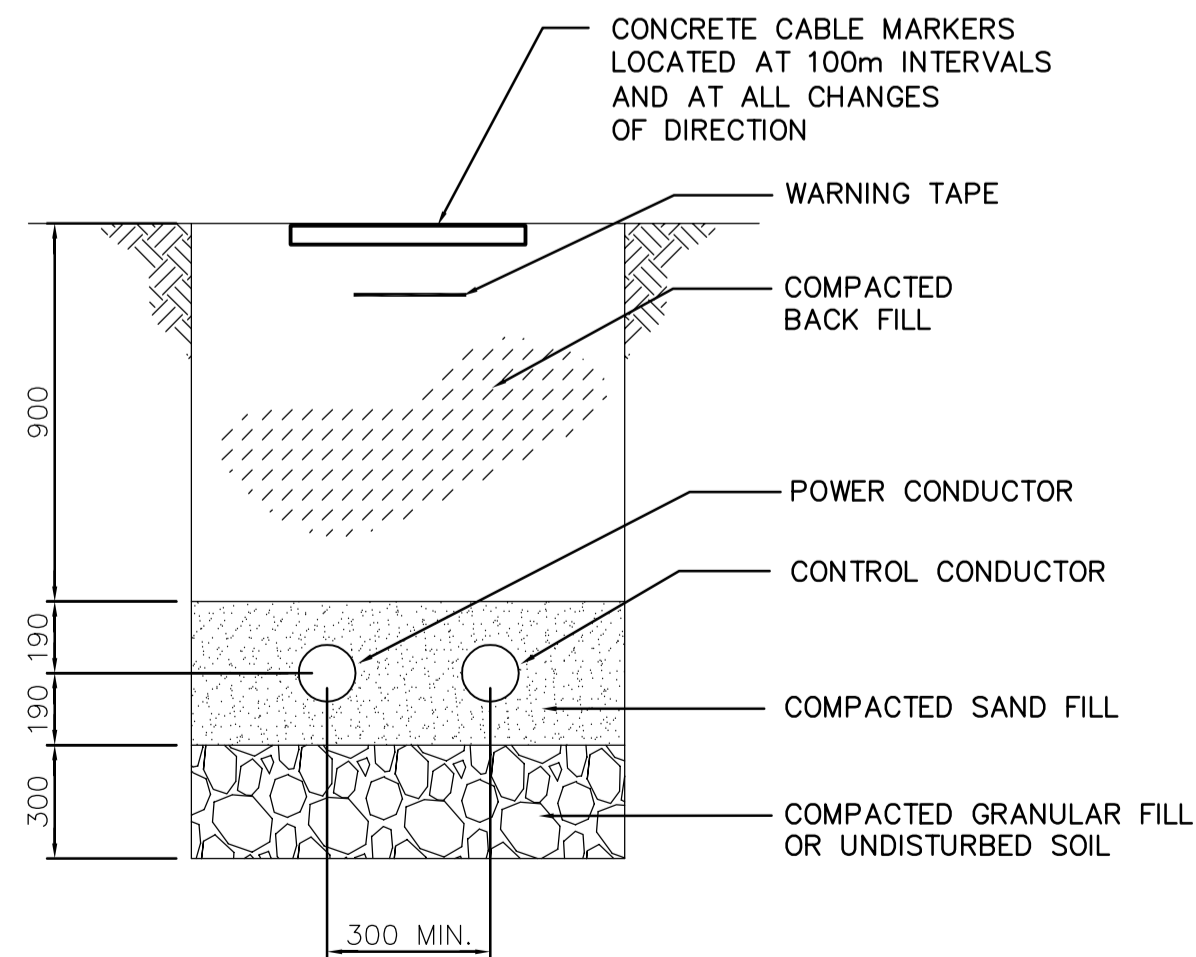

1 SECTION - CABLE TRENCH
N.T.S.

DRAWING NOTES

- ① IN PANEL 'C' PROVIDE AND INSTALL ONE NEW 15A-1P CIRCUIT BREAKER FOR CELL 3 RAW WATER VALVE CHAMBER AND ONE NEW 40A-1P BREAKER FOR THE SANITARY PUMP STATION CONTROL PANEL
- ② LOCATION AND INSTALLATION METHOD FOR THESE CONDUCTORS TO BE DETERMINED ON SITE.

 APECM Certificate of Authorization Earth Tech Canada Inc. No. 730 Expiry: April 30, 2007	B.M. ELEV.	 Frederickson Cooper ARCHITECTS	 A Tyco International Ltd. Company	ENGINEER'S SEAL	 THE CITY OF WINNIPEG WATER AND WASTE DEPARTMENT ENGINEERING DIVISION	CITY FILE NUMBER		
				DESIGNED BY: ERC		CHECKED BY: PS	ORIGINAL SIGNED BY: P. STRYK	SHEET OF
				DRAWN BY: ERC		APPROVED BY: AHL	2006/02/20	CITY DRAWING NUMBER
				SCALE: AS SHOWN		RELEASED FOR CONSTRUCTION BY: R.SOROKOWSKI	CONSULTANT DRAWING NO. WH-E0100	1-0601H-A-E0100-001-010
	01 REVISED CABLE LAYOUT 07/04/05 ERC							
	00 ISSUED FOR TENDER (94-2007) 07/02/20 ERC							
	NO. REVISIONS	DATE	BY	DATE				
		07/02/19		2006/02/22				