




1 WALL SECTION
WB-B0120 1 : 20

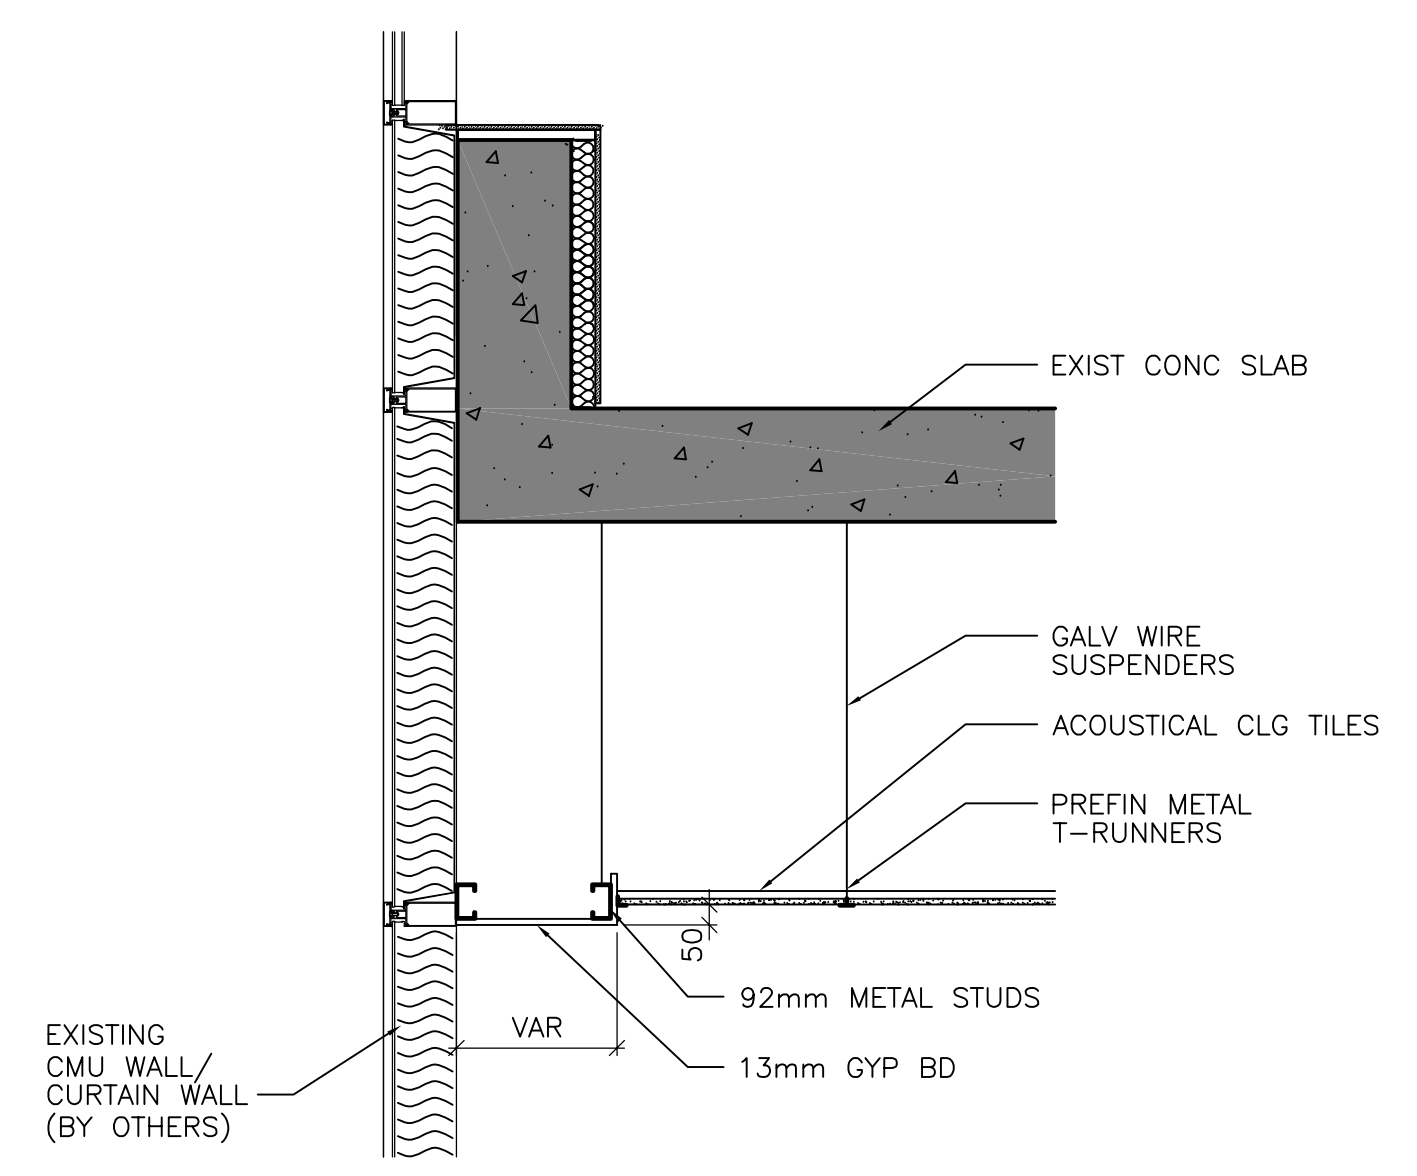


2 TYP CEILING DETAIL @ BULKHEAD
WB-B0152 1 : 20

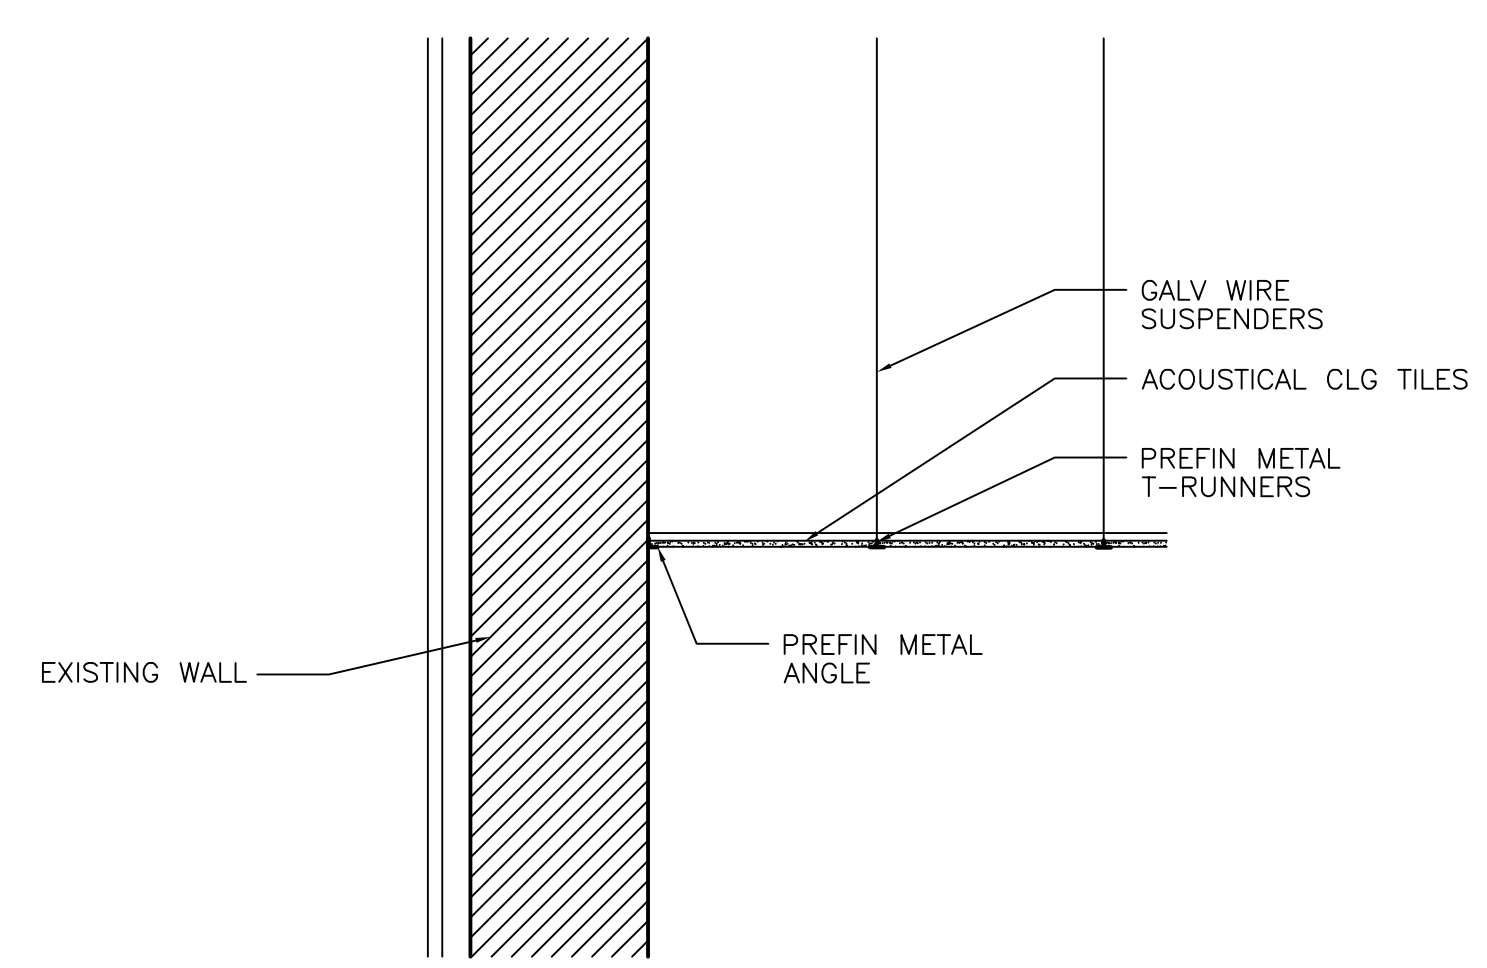

3 TYP CEILING DETAIL @ ACT
WB-B0153 1 : 20

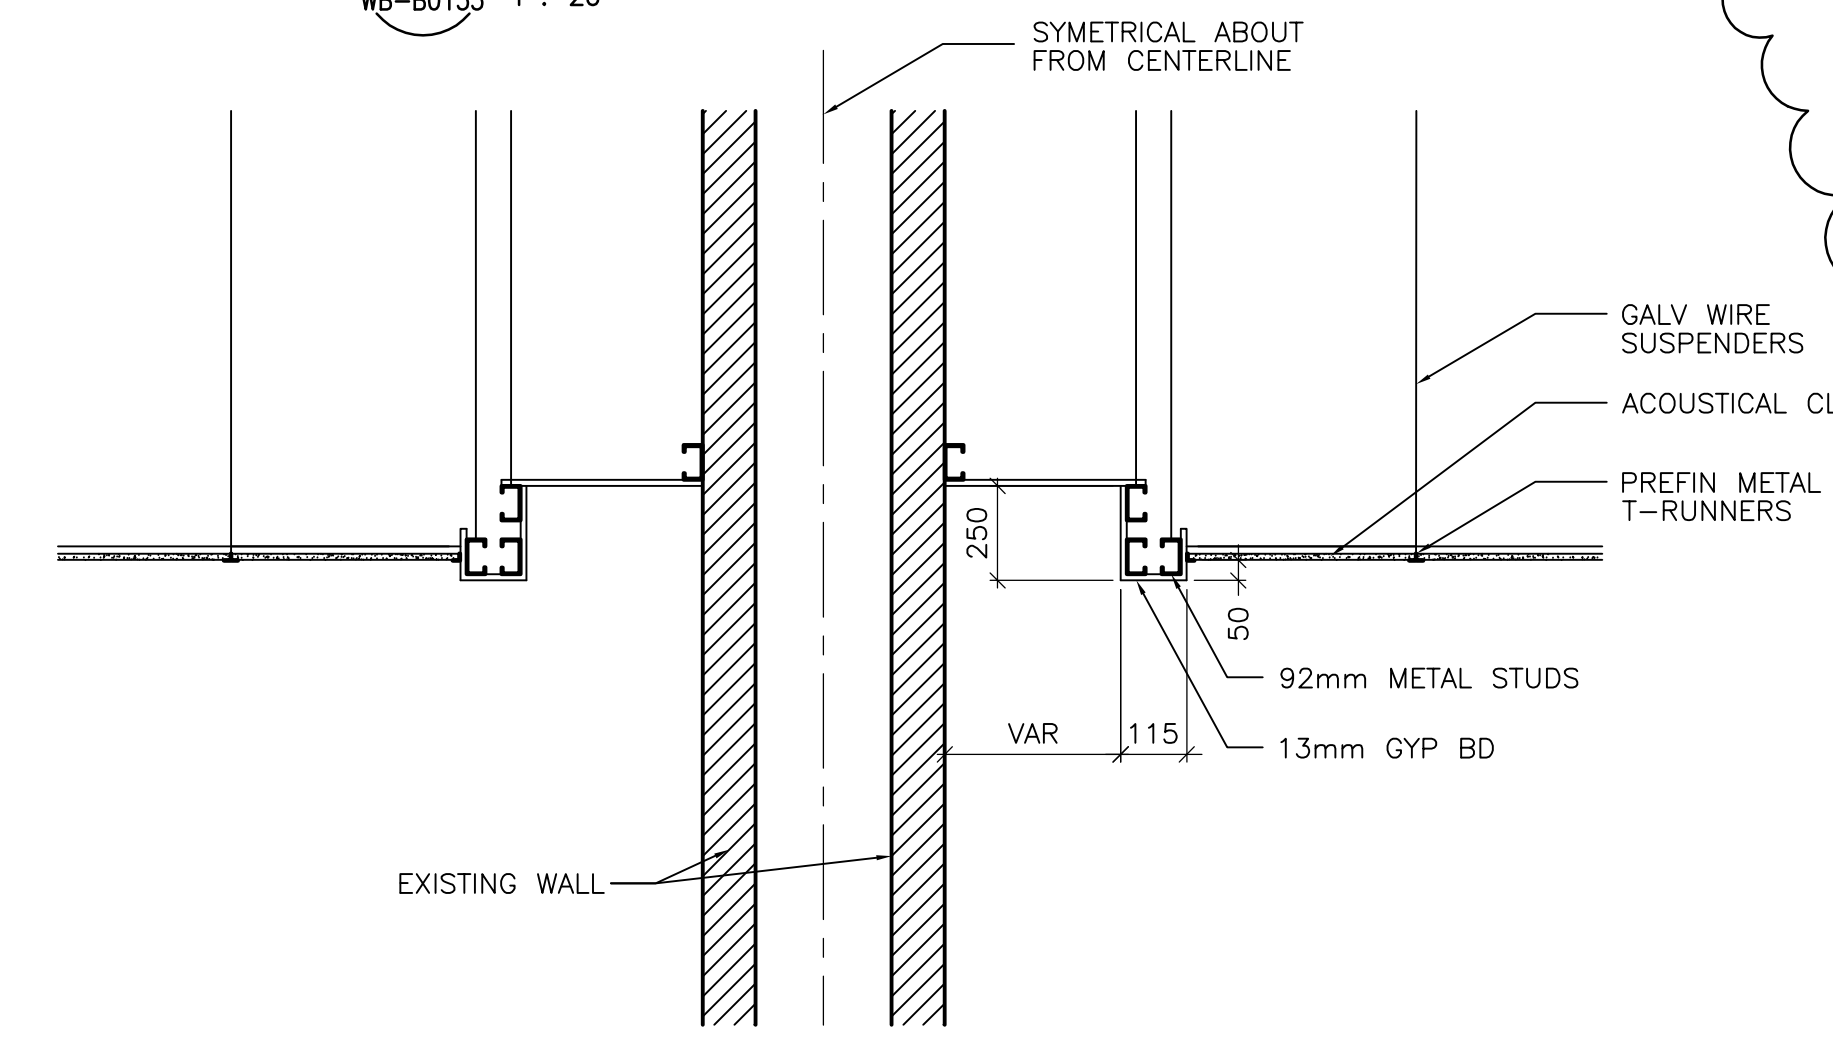


4 TYP CEILING DETAIL @ LIGHTING COVE
WB-B0152 1 : 20

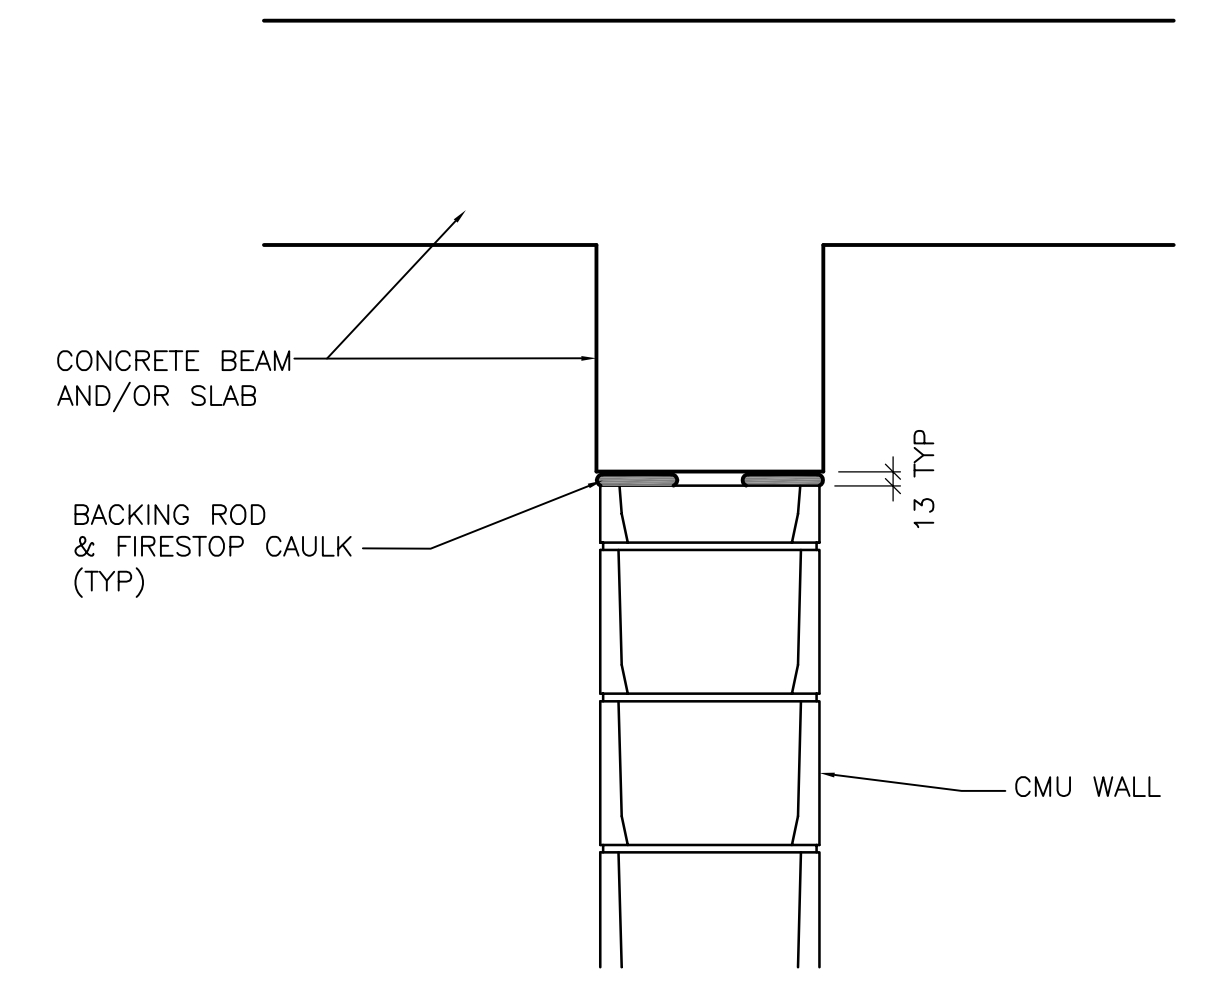

TYP DETAIL @ INTERIOR CMU WALLS
1 : 10

NOTE: FIRESTOPPING TO MEET REQUIREMENTS OF WALL FIRE RATINGS

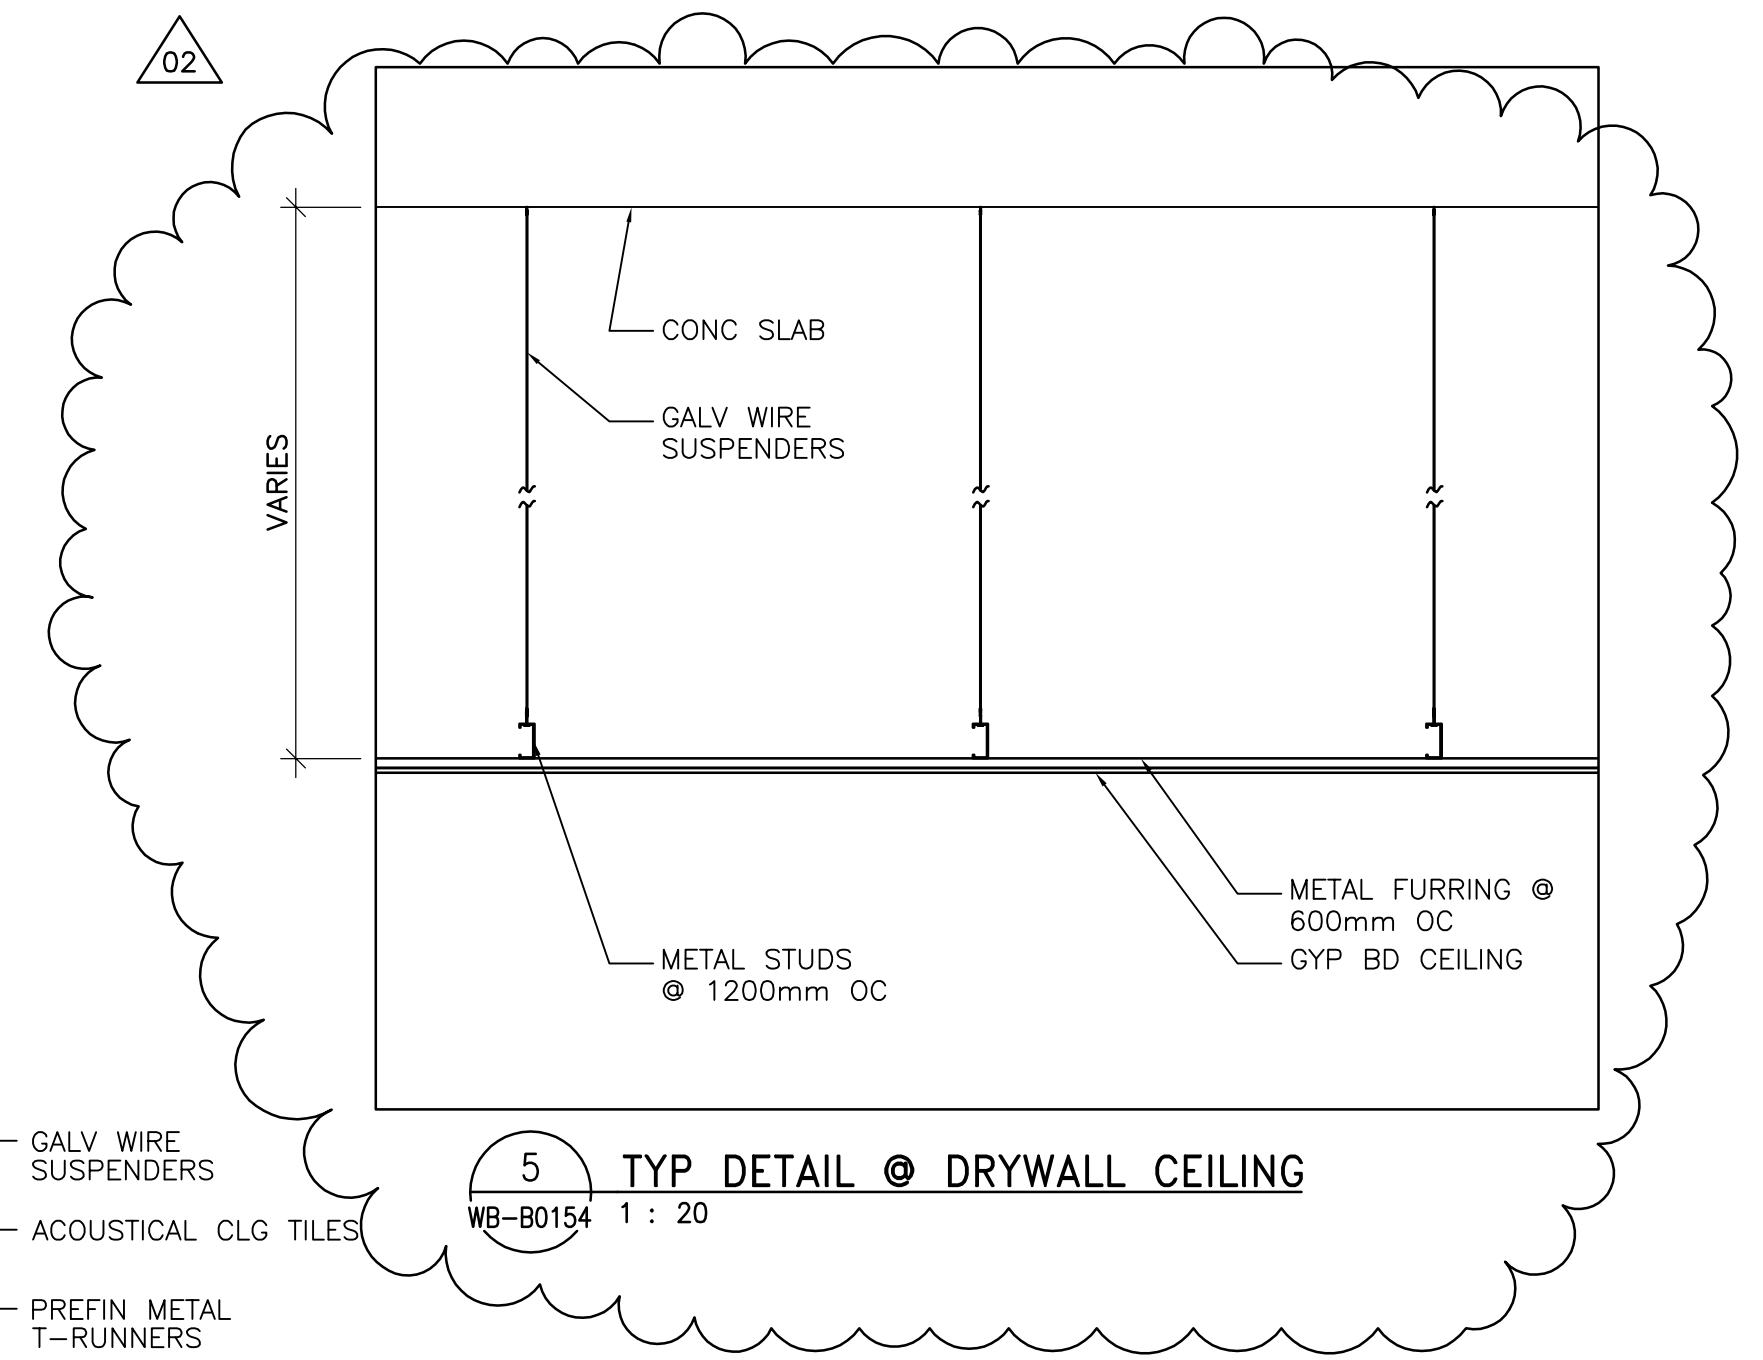

5 TYP DETAIL @ DRYWALL CEILING
WB-B0154 1 : 20



NO.	REVISIONS	DATE	BY
02	95-2007 ADDENDUM 05	07/07/13	LK
01	95-2007 ADDENDUM 01	07/06/12	LK
00	ISSUED FOR TENDER	07/06/05	LK

DESIGNED BY	CHECKED BY
MG	BJS
DRAWN BY	APPROVED BY
AL	AHL
SCALE:	RELEASED FOR CONSTRUCTION BY:
AS NOTED	R. SOROKOWSKI
DATE	DATE
2005/08/05	2007/06/05

ENGINEER'S SEAL
ORIGINAL SIGNED BY NEIL COOPER 2007/06/05
CONSULTANT DRAWING NO. WB-B0154

THE CITY OF WINNIPEG
WATER AND WASTE DEPARTMENT
ENGINEERING DIVISION

WATER TREATMENT PLANT
MAIN BUILDING
OFFICE AND PLANT INTERIOR FINISHES

ARCHITECTURAL
WALL SECTION AND CEILING DETAILS

CITY FILE NUMBER
SHEET OF
CITY DRAWING NUMBER
1-0601B-A-B0154-001-02D