


**A** WTP ADMINISTRATION AREA DETAIL  
 WY-E0180 SCALE: 1:100

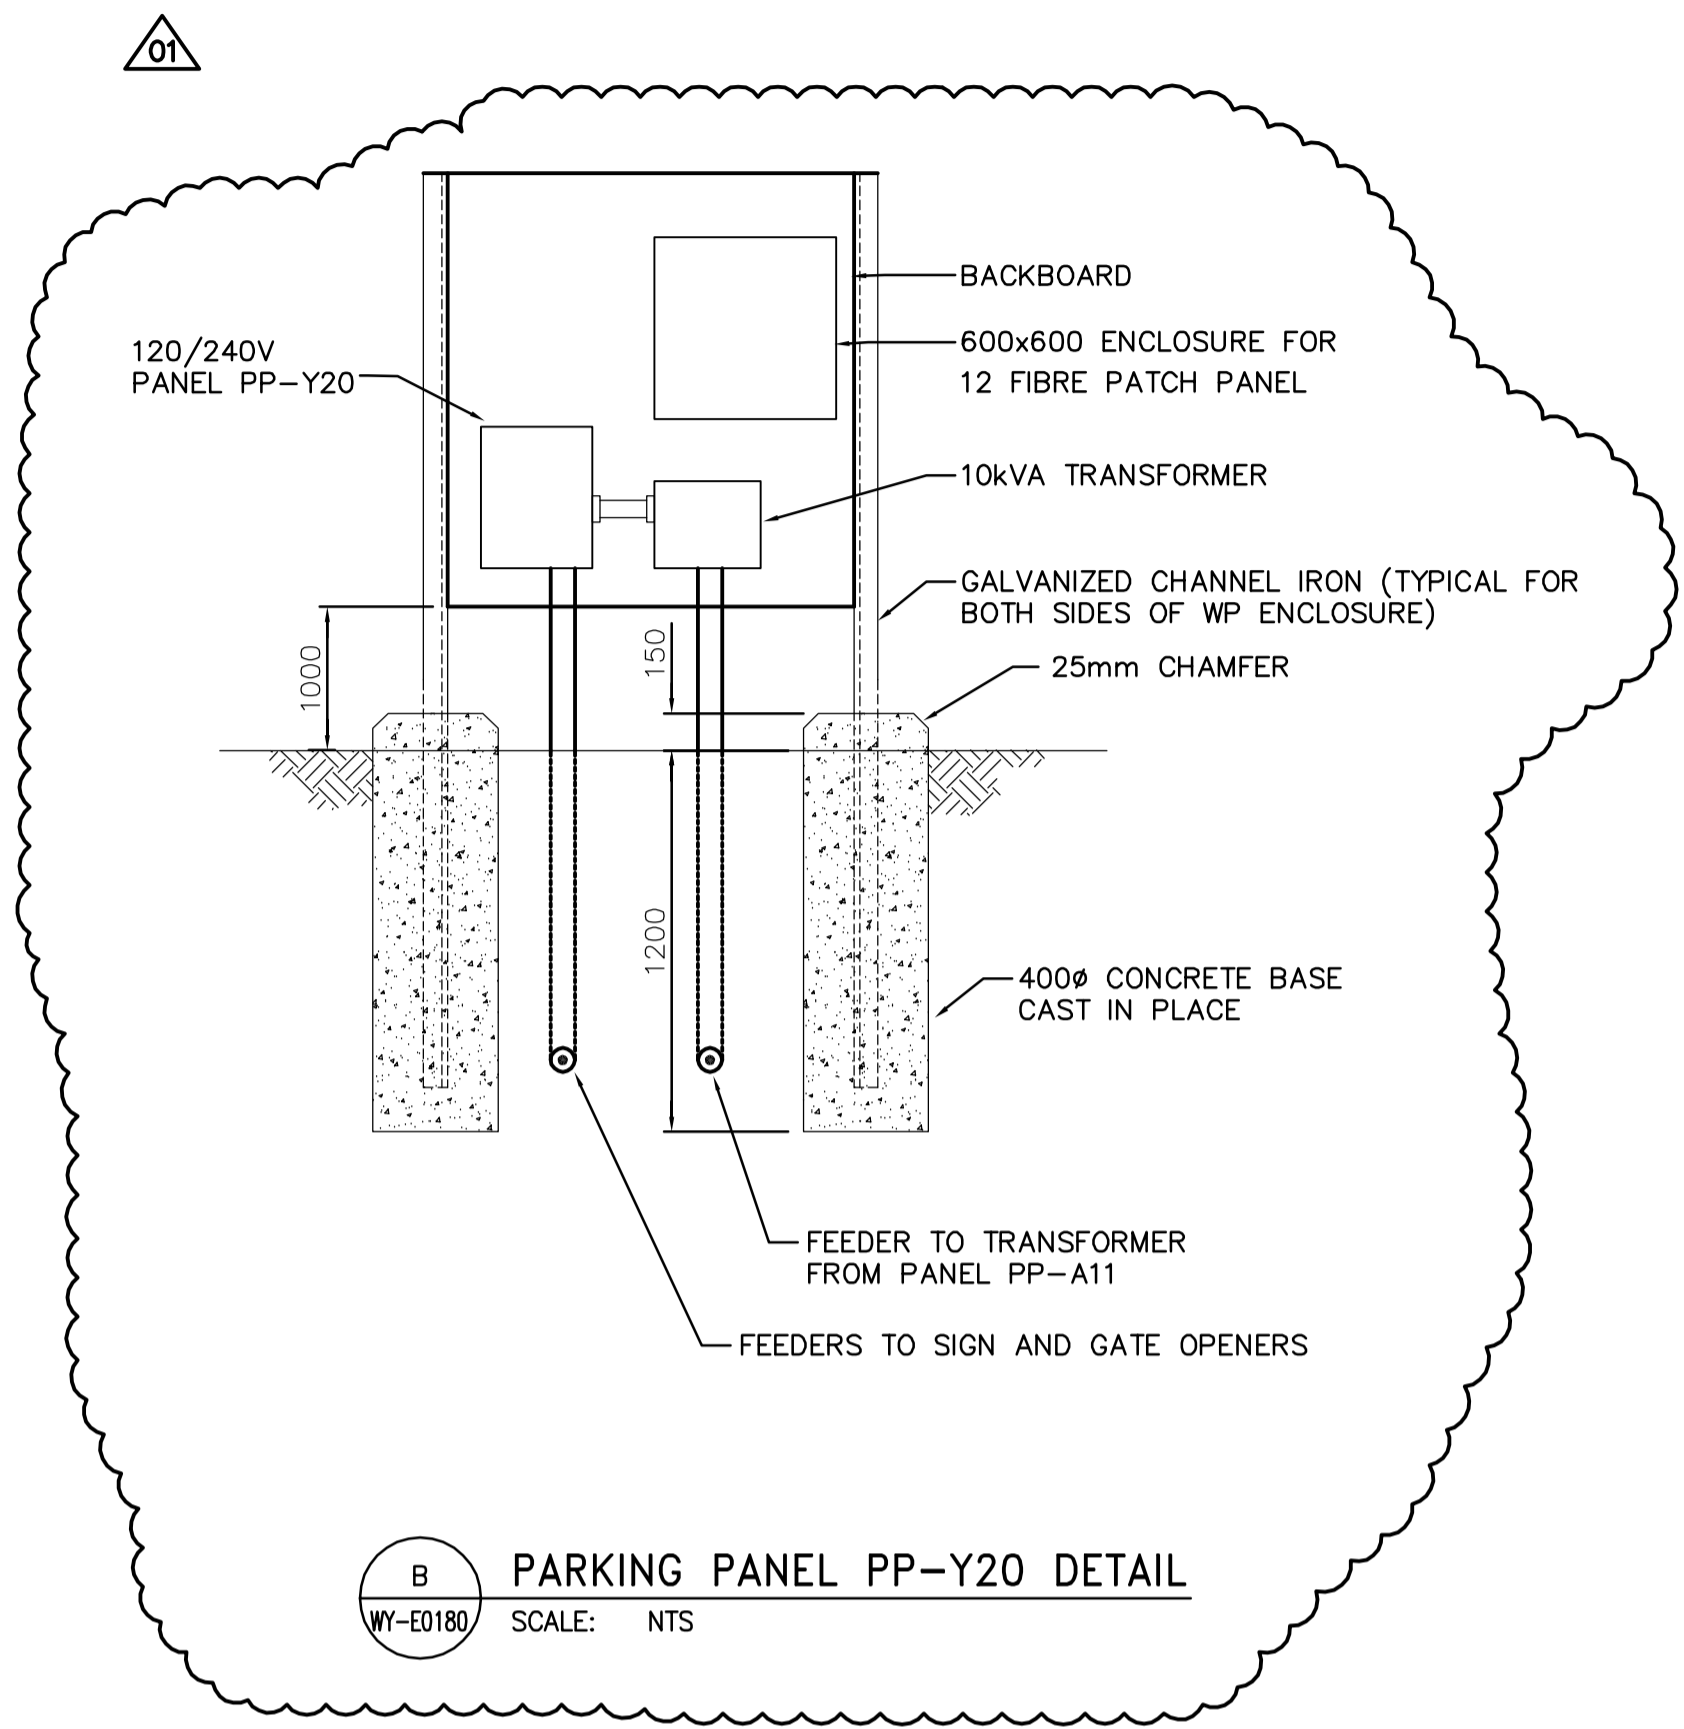

**B** PARKING PANEL PP-Y20 DETAIL  
 WY-E0180 SCALE: NTS

|   |   |                                       |   |                                 |  |   |                             |
|---|---|---------------------------------------|---|---------------------------------|--|---|-----------------------------|
| <br>Certificate of Authorization<br>Earth Tech Canada Inc.<br>No. 730 | B.M. ELEV.  | <br>Frederickson Cooper<br>ARCHITECTS | <br>A Tech International Ltd. Company       | ENGINEER'S SEAL                 | <br>THE CITY OF WINNIPEG<br>WATER AND WASTE DEPARTMENT<br>ENGINEERING DIVISION | CITY FILE NUMBER  |                             |
|   |   |                                       |   | DESIGNED BY BLM                 |  | CHECKED BY PS   | ORIGINAL SIGNED BY P. STRYK |
|   |   | DRAWN BY ERC                          | APPROVED BY AHL                             | 2007/11/09                      |  | WATER TREATMENT PLANT CONSTRUCTION OF ROADS AND LANDSCAPING | CITY DRAWING NUMBER         |
|   | 01 ISSUED FOR ADDENDUM 4 07/12/14 ERC<br>00 ISSUED FOR TENDER 07/11/09 ERC<br>NO. REVISIONS DATE BY | SCALE: NTS                            | RELEASED FOR CONSTRUCTION BY: R. SOROKOWSKI | CONSULTANT DRAWING NO. WY-E0481 |  | ELECTRICAL DETAILS  | 1-0601Y-D-E0481-001-010     |