

SYMBOL QUANT. DESCRIPTION

- (A) 9 SPRINKLER RISER - GRINNELL 6" MODEL A
- (B) 3 SPRINKLER RISER - GRINNELL 8" MODEL A
- (C) 2 SPRINKLER RISER - RELIABLE 6" MODEL E
- (D) 3 FLOW SWITCH - PADDLE TYPE
- (E) 3 GLYCAL SRPINKLER SYSTEM
- (F) 2 FIRE HOSE
- (G) 10 WATER GONG
- (H) 4 WALL HYDRANT - McAVITY
- (J) 3 UNDERGROUND VALVE PIT c/w VALVES, CHECK VALVES, FIRE DEPARTMENT CONNECTIONS AND INCOMING WATER MAIN


SYMBOL DESCRIPTION

- Z CHECK VALVE
- I ISOLATION VALVE

SPRINKLER ZONE SPRINKLER ZONE - Identified by boxed in text, which describes location in the building.

Y FIRE DEPARTMENT CONNECTIONS

NOTE: LABELS (eg. like N1L1M01 or N2L1M01) NEXT TO EQUIPMENT ARE MODULE ADDRESSES FOR THE FACILITIES FIRE ALARM SYSTEM.

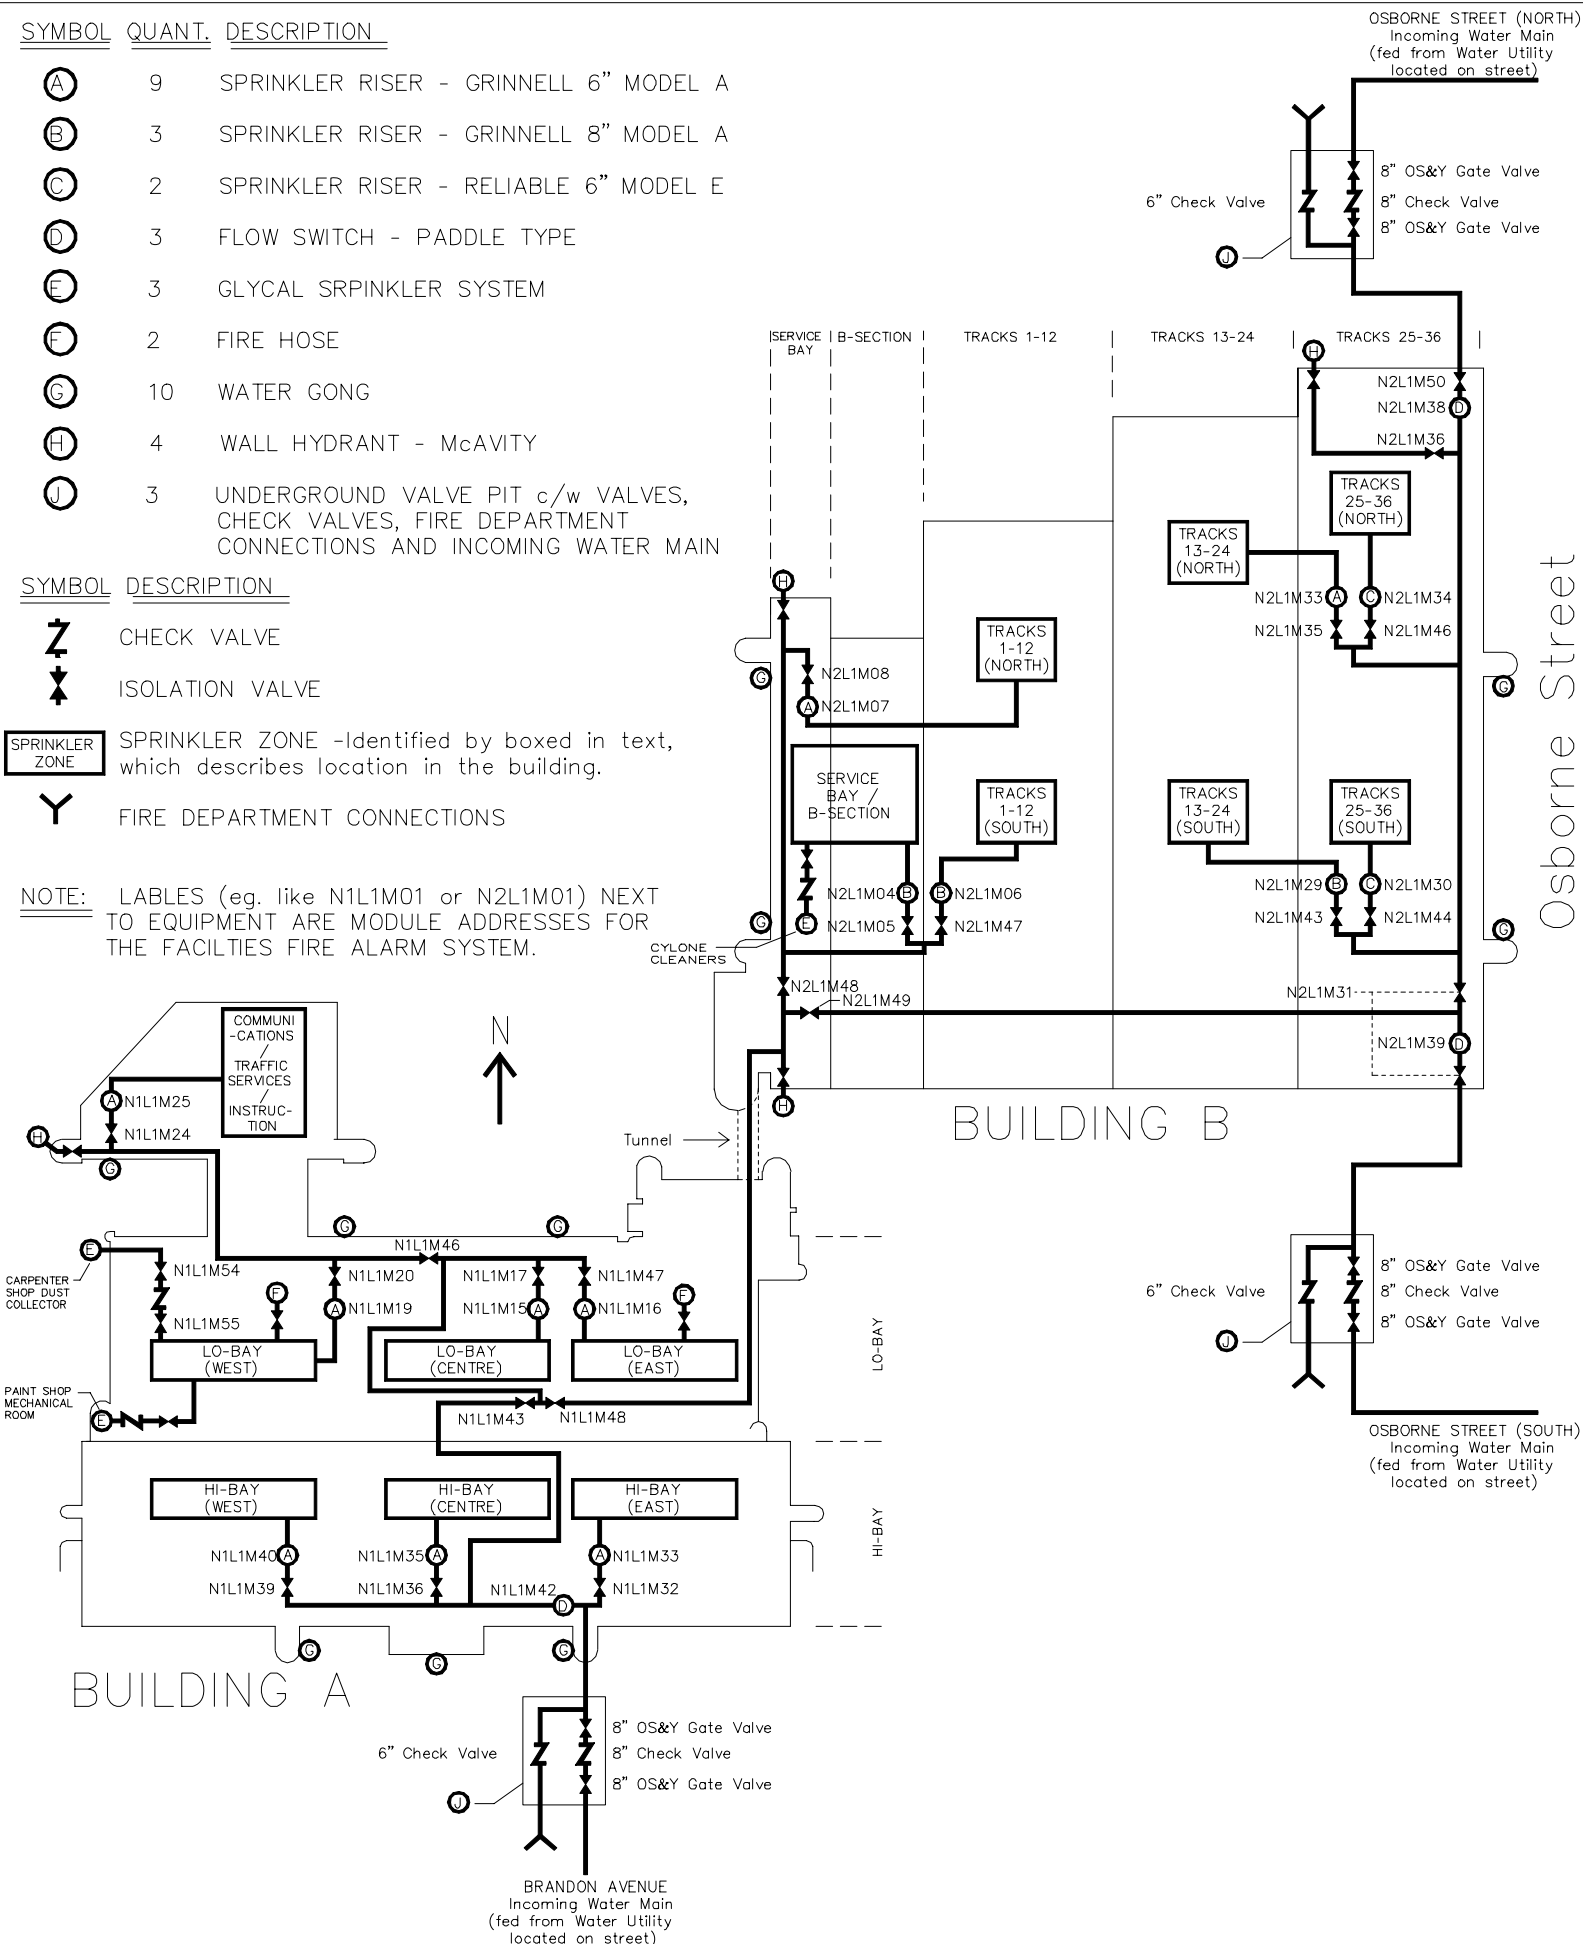

Brandon Avenue

FORT ROUGE GARAGE
SPRINKLER SYSTEM -
BUILDING A & B -
SINGLE LINE DIAGRAM

REVISION 0
REF NO FRG_208
DRAWING NO.
FRG SPR 02