


SECTION 1-1
1:20

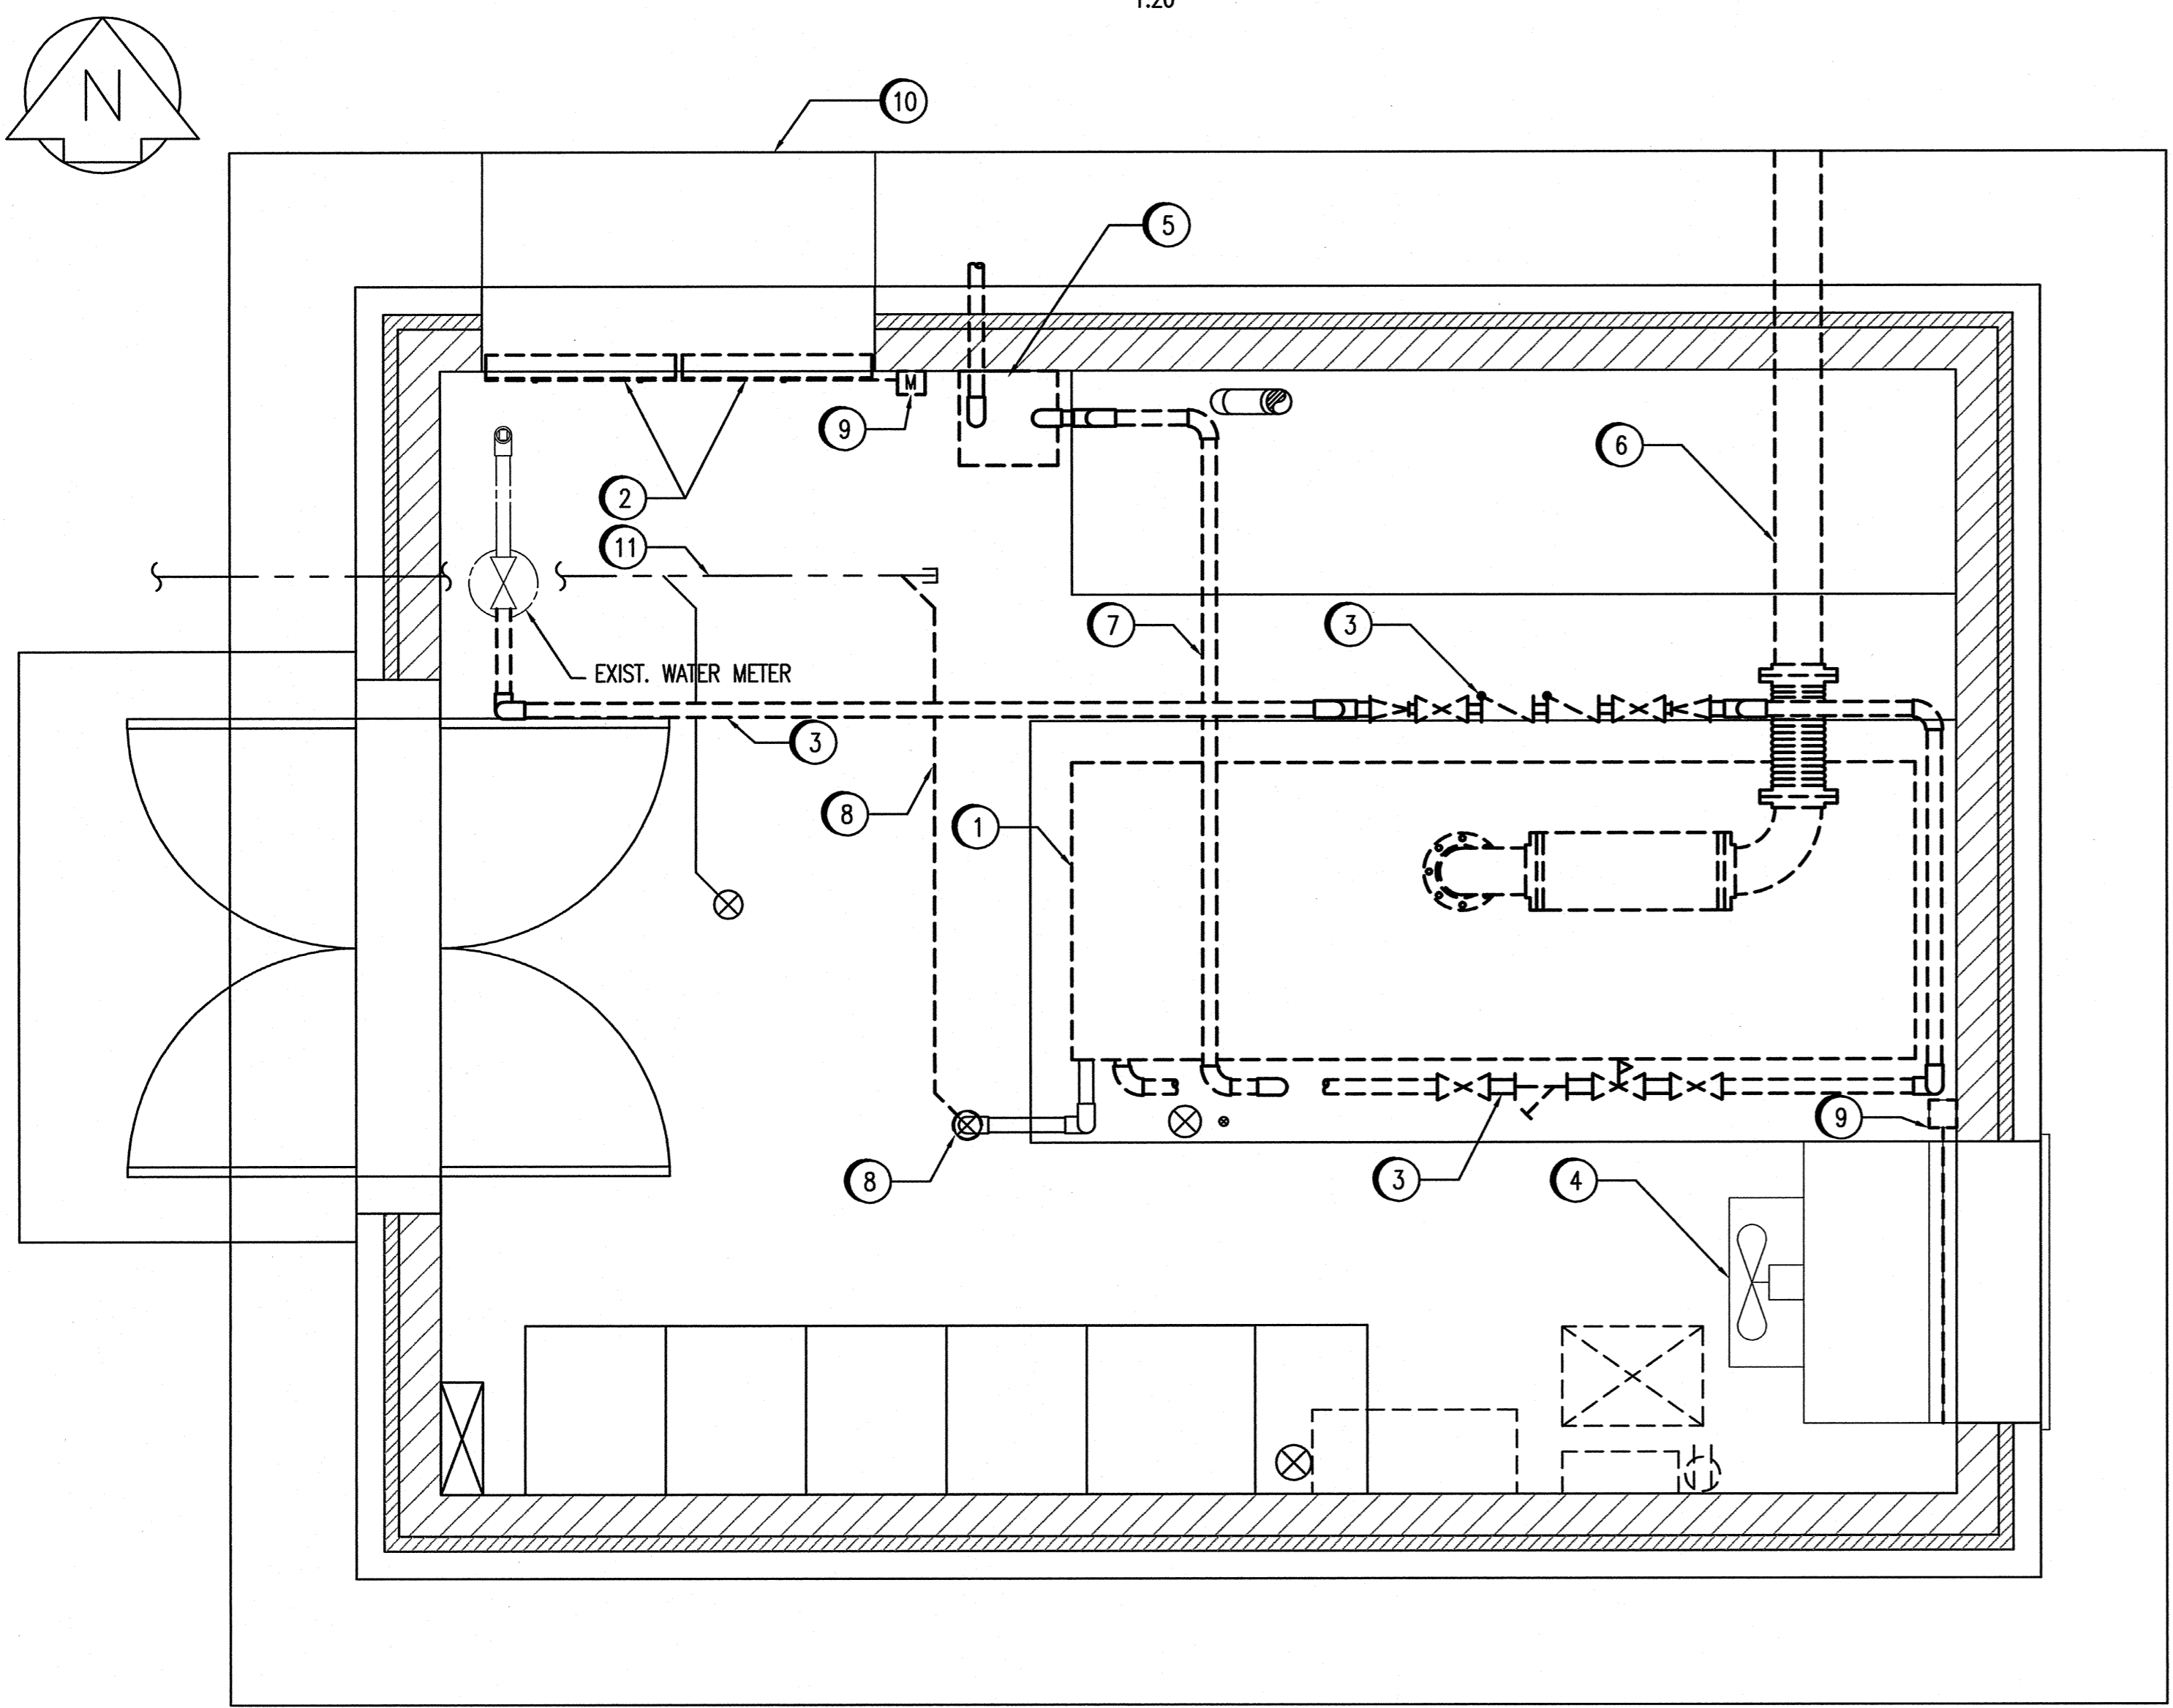

PLAN - GENERATOR BUILDING
1:20

GENERAL NOTES:


- ASBESTOS CONTAINING MATERIAL HAS BEEN IDENTIFIED ON THE ENGINE EXHAUST PIPING. ASBESTOS ABATEMENT WORK TO BE CARRIED OUT BY ABATEMENT CONTRACTOR AS OUTLINED IN THE ASBESTOS SPECIFICATIONS.

SPECIFIC NOTES:

- REMOVE EXISTING 250 KW NATURAL GAS GENERATOR SET, INCLUDING NATURAL GAS REGULATOR.
- EXISTING DAMPERS TO REMAIN.
- REMOVE EXISTING 50mm WATER PIPING, VALVES, FITTINGS, SUPPORTS AND BACKFLOW PREVENTER. MAINTAIN EXISTING METER, HEAT TRACING AND INSULATION. MAINTAIN EXISTING CUSHION/EXPANSION TANK AND LOW WATER PRESSURE SWITCH MOUNTED ON EAST WALL.
- EXISTING EXHAUST FAN AND DUCTWORK TO REMAIN.
- EXISTING GAS METER TO BE RELOCATED OUTSIDE OF BUILDING BY OTHERS. CONTRACTOR TO CONFIRM LOCATION WITH CITY OF WINNIPEG AND GAS COMPANY.
- REMOVE EXISTING ENGINE EXHAUST, SILENCER, EXPANSION COMPENSATER AND SUPPORTS AFTER ASBESTOS REMOVAL.
- EXISTING 50mm GAS PIPING, VALVES, FITTINGS AND SUPPORTS TO BE REMOVED.
- EXISTING 100mm FLOOR DRAIN AND PIPING TO BE REMOVED BACK TO MAIN SANITARY WATER PIPING. (REFER TO DWG 06053)
- EXISTING PNEUMATIC ACTUATOR AND ASSOCIATED PIPING TO BE REMOVED. (TYPICAL OF 4)
- EXISTING INTAKE HOOD TO REMAIN.
- EXISTING 100mm SANITARY PIPING TO REMAIN.
- REMOVE EXISTING WINDOW COVERINGS.

1042	SUPERSEDED DRAWING SET
06053	STRUCTURAL DRAWING SET
06051	MECHANICAL DRAWING SET
06090-06092	ELECTRICAL DRAWING SET
06044-06049	ELECTRICAL DRAWING SET
DRAWING NUMBER	REFERENCE DRAWINGS

 APECM
 Certificate of Authorization
SNC-Lavalin Inc.
 No. 4489 Expiry: April 30, 2008



B.M. ELEV.	FIELD BOOK #:	SNC-LAVALIN 148 Nature Park Way Winnipeg, MB, Canada R3P 0X7 204-786-8080	ENGINEER'S SEAL NORSWORTHY Member 20725
POSTED TO LBIS			
DESIGNED BY S. NORSWORTHY	CHECKED BY	HOR. SCALE 1:20 VERTICAL 1:20	RELEASED FOR CONSTRUCTION
DRAWN BY D. CALVERLEY	APPROVED BY		
00 ISSUED FOR CONSTRUCTION	08/01/18 AEO	DATE 07/07/11	DATE
NO. REVISIONS	DATE	BY	FILENAME: 113049-4500-0000-0001.dwg

THE CITY OF WINNIPEG
 WATER AND WASTE DEPARTMENT
WINDSOR PARK WASTEWATER PUMPING STATION
 GENERATOR UPGRADE
 PLAN
 MECHANICAL LAYOUT
 DEMOLITION

CITY DRAWING NUMBER: 06052
 SHEET: 001
 REV: 00
 SIZE: D