




SITE PLAN OF REMOTE SENSOR
SCALE 1" = 40'

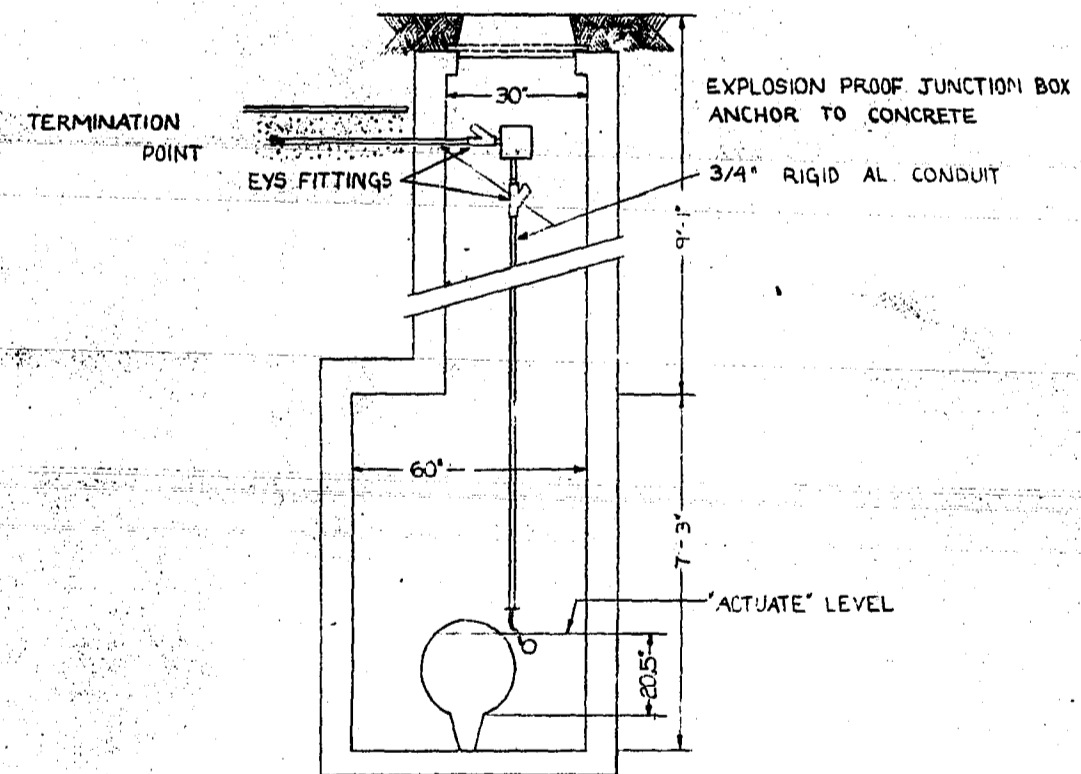

DETAIL OF FLOAT SWITCH IN MANHOLE #9
SCALE 3/8" = 1"

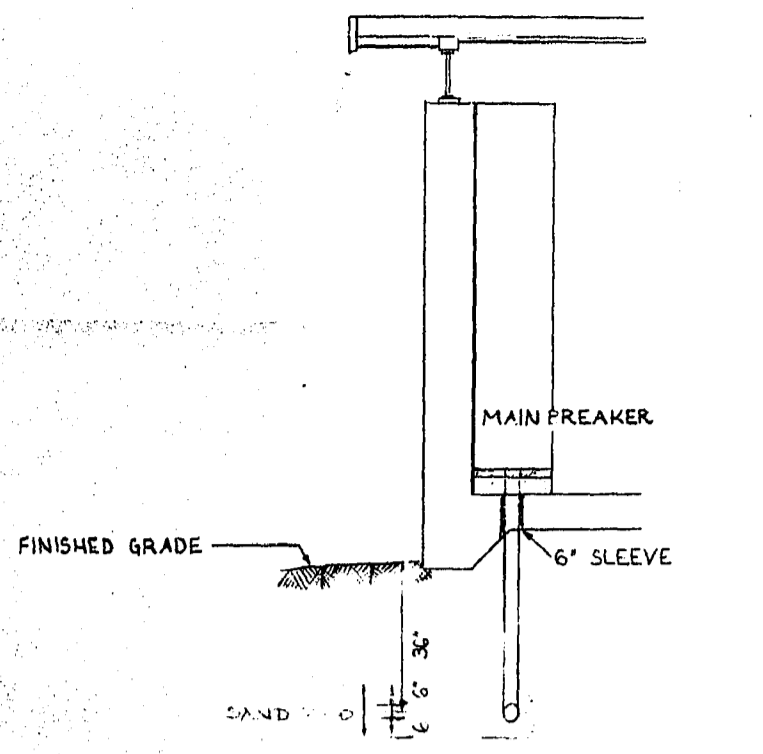


2 EB HYDRO ENTRANCE DETAIL
SCALE 3/8" = 1"

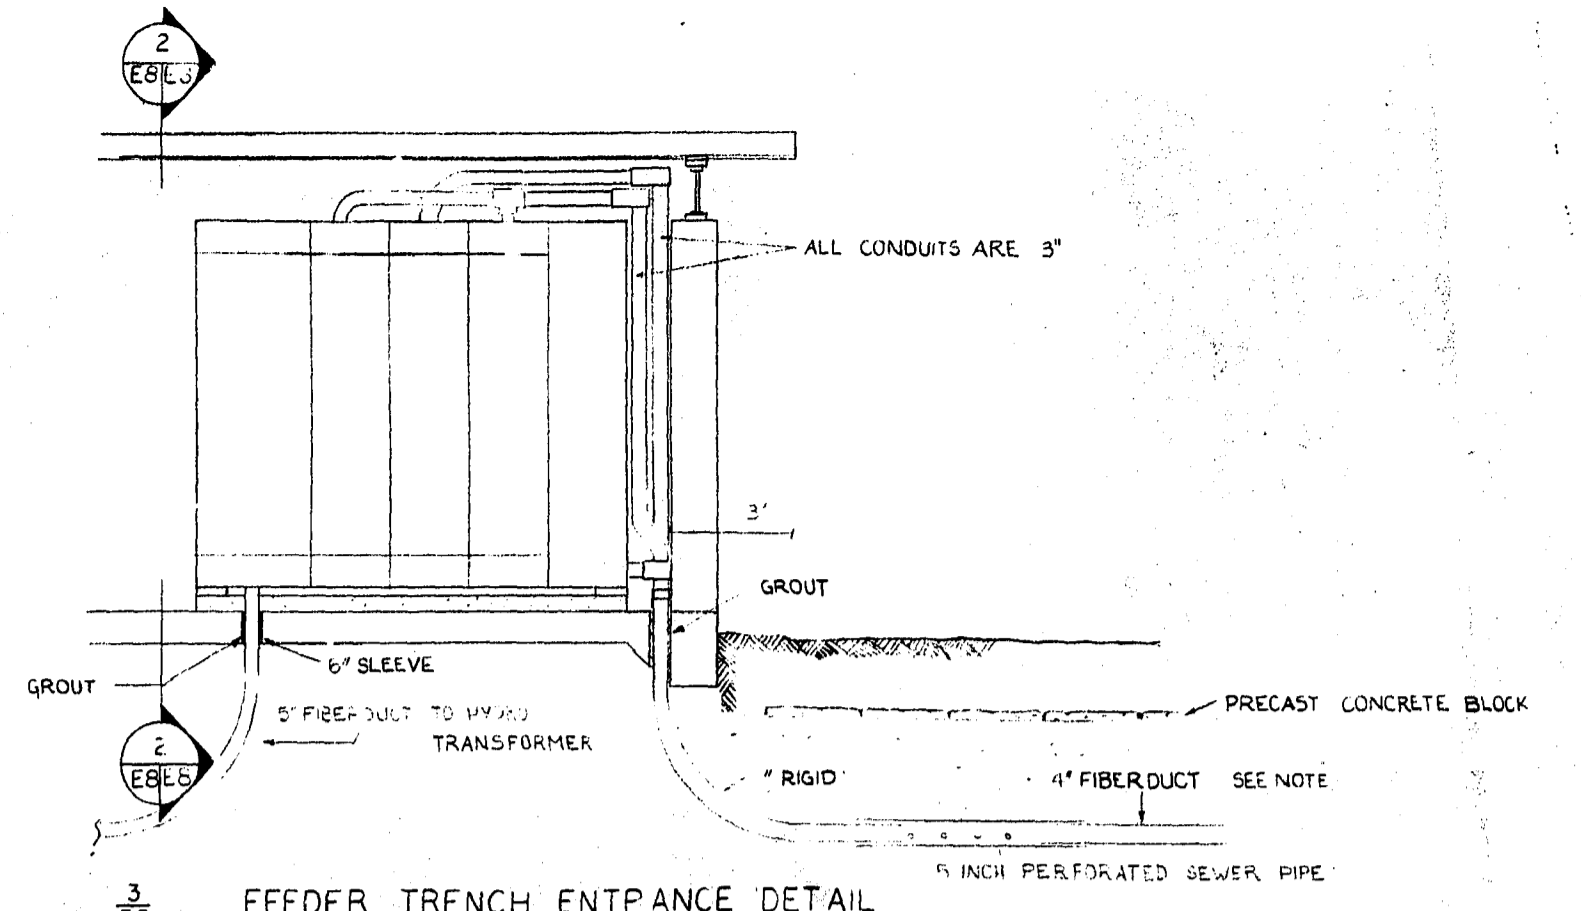


3 EB FEEDER TRENCH ENTRANCE DETAIL
SCALE 3/8" = 1"

NOTE: UNDER A SEPARATE CONTRACT, THE FIBER DUCT TO THE LIFT STATION W/V CABLES HAD BEEN INSTALLED TO WITHIN 10'-0" OF THE BUILDING UNDER THIS CONTRA. THIS TURT IS TO BE EXTENDED AS SHOWN.

THIS OPENING FOR FUTURE SPLITTER BOX. NO USE AT PRESENT.

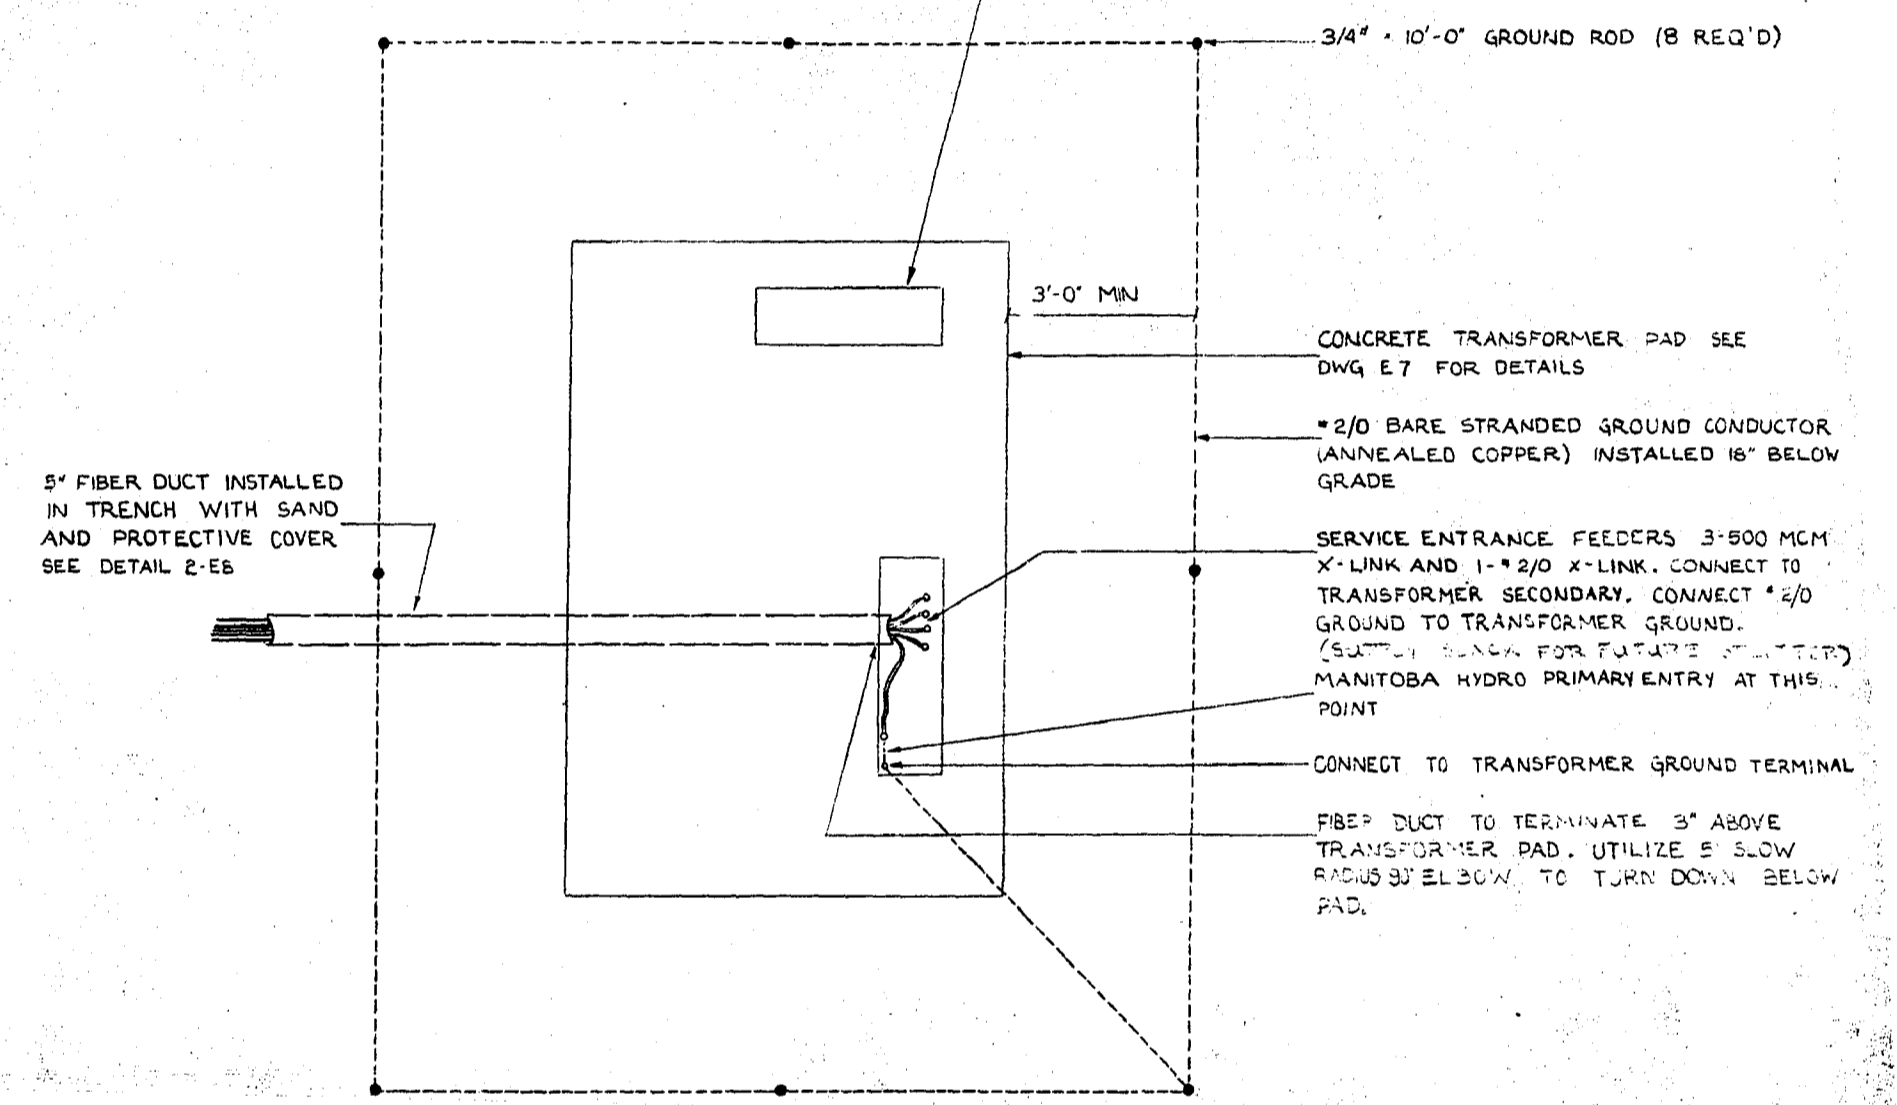

TRANSFORMER CONNECTION & GROUND DETAIL
SCALE 1/2" = 1"

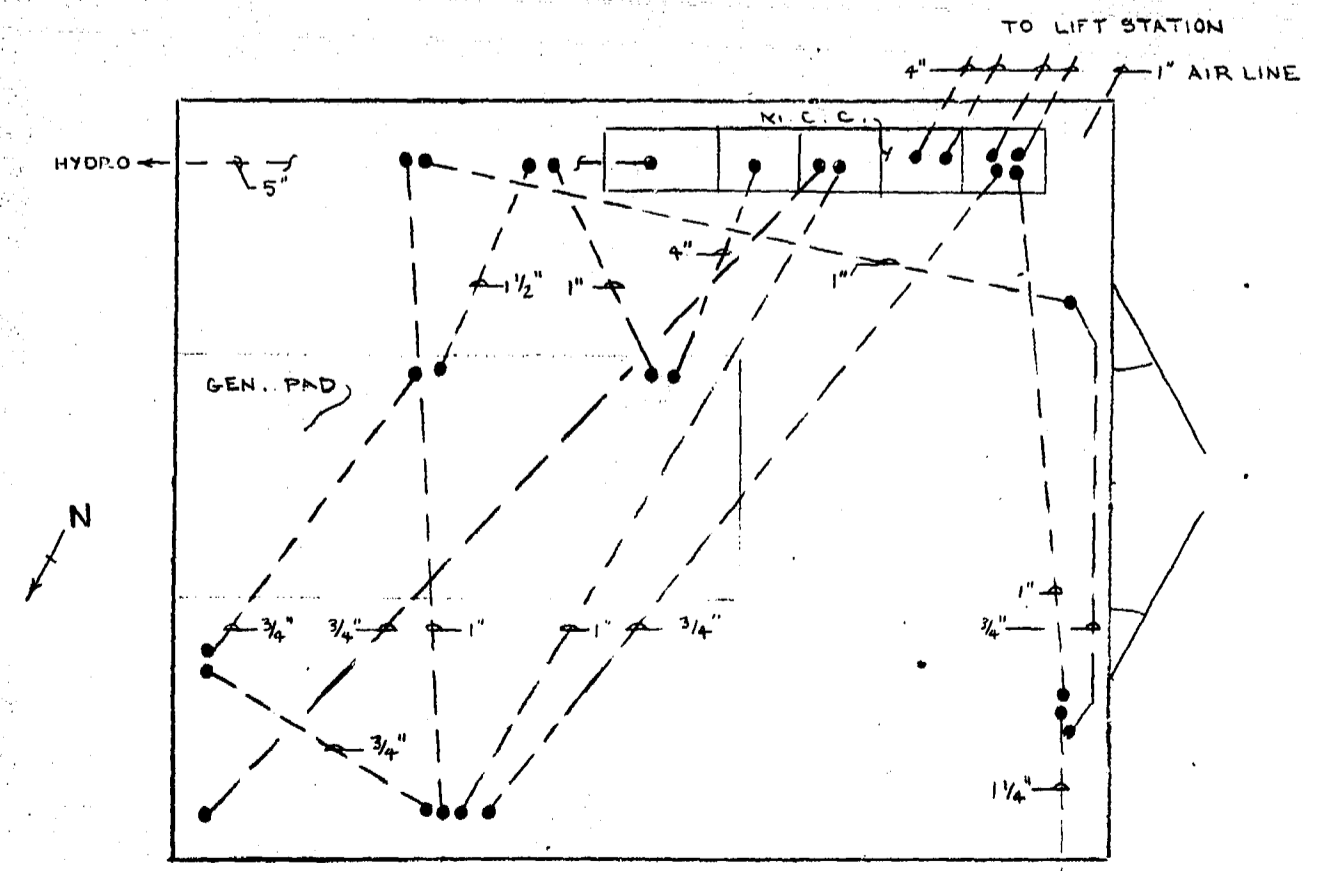

GENERATOR BUILDING SLAB CONDUIT LAYOUT

NO.	DESCRIPTION	DATE	BY
REVISIONS			
CITY OF WINNIPEG WORKS AND OPERATIONS DIVISION DISTRICT 5			
W. L. WARDROP & ASSOCIATES LTD. ENGINEERING CONSULTANTS WINNIPEG • THUNDER BAY • REGINA • BARRIE • EDMONTON			
WINDSOR PARK LIFT STATION RENOVATION			
MISCELLANEOUS DETAILS			
DESIGNED BY:	DRAWN BY:	CHECKED BY:	
JEH	KFM		
APPROVED BY:			
SCALE:	AS NOTED	DATE:	1/76
DRAWING NO:	76012-04-E8	PAGE:	10

AS - BUILT
DATE: Dec/76
MICROFILMED OCT 23 1987

