


- NOTES:**
- ① LOCATION REQUIRES CONDUIT AND BOX IN ADDITION TO SPECIFIED CAT6 CABLE



- LEGEND:**
- EXISTING BOX INSTALL FACEPLATE
 - ▼ BOX REQUIRES ONE CAT6 CABLE TO INDICATED TERMINATION CABINET FOR BUSINESS LAN OR VOICE (BLUE OR WHITE JACK)
 - ▾ BOX REQUIRES TWO CAT6 CABLES TO INDICATED TERMINATION CABINET FOR BUSINESS LAN AND VOICE (BLUE AND WHITE JACK)

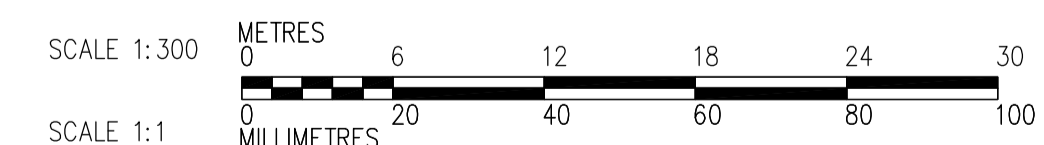

B.M. ELEV.	
DESIGNED BY	ERC
CHECKED BY	BLM
DRAWN BY	ERC
APPROVED BY	SRB
SCALE:	1:300
RELEASED FOR CONSTRUCTION BY:	R. SOROKOWSKI
NO. REVISIONS	DATE BY
0	ISSUED FOR TENDER 09/02/27 ERC
	DATE 2008/10/01

CH2MHILL
Frederickson Cooper ARCHITECTS

EarthTech
A Tyco International Ltd. Company

DESIGNED BY: ERC
CHECKED BY: BLM
DRAWN BY: ERC
APPROVED BY: SRB
SCALE: 1:300
RELEASED FOR CONSTRUCTION BY: R. SOROKOWSKI
DATE: 2007/03/19

ENGINEER'S SEAL
ORIGINAL SIGNED BY
B.L. MOORE
2009/02/27
CONSULTANT DRAWING NO.
WB-E0621

THE CITY OF WINNIPEG
WATER AND WASTE DEPARTMENT
ENGINEERING DIVISION

WATER TREATMENT PLANT
MAIN BUILDING
TELEPHONE AND DATA INSTALLATION

TELEPHONE AND DATA
OVERALL BUILDING
SECOND FLOOR PLAN

CITY FILE NUMBER
SHEET OF
CITY DRAWING NUMBER
1-0601A-B-E0621-001-000