


- NOTES:**
- ① LOCATION REQUIRES CONDUIT AND BOX IN ADDITION TO SPECIFIED CAT6 CABLE

THIRD FLOOR PLAN
1:300

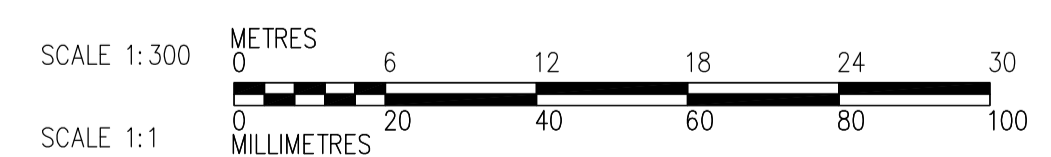

- LEGEND:**
- EXISTING BOX INSTALL FACEPLATE
 - ▼ BOX REQUIRES ONE CAT6 CABLE TO INDICATED TERMINATION CABINET FOR BUSINESS LAN OR VOICE (BLUE OR WHITE JACK)
 - ▾ BOX REQUIRES TWO CAT6 CABLES TO INDICATED TERMINATION CABINET FOR BUSINESS LAN AND VOICE (BLUE AND WHITE JACK)

 Certificate of Authorization AECOM Canada Ltd. Original dated on: No. 4671 Date: 2009/02/27	B.M. ELEV.	 Frederickson Cooper ARCHITECTS	 A Tyco International Ltd. Company	ENGINEER'S SEAL	 THE CITY OF WINNIPEG WATER AND WASTE DEPARTMENT ENGINEERING DIVISION
	DESIGNED BY: ERC DRAWN BY: ERC SCALE: 1:300	CHECKED BY: BLM APPROVED BY: SRB RELEASED FOR CONSTRUCTION BY: R. SOROKOWSKI	ORIGINAL SIGNED BY: B.L. MOORE 2009/02/27	WATER TREATMENT PLANT MAIN BUILDING TELEPHONE AND DATA INSTALLATION	CITY FILE NUMBER SHEET OF
0 ISSUED FOR TENDER 09/02/27 ERC NO. REVISIONS DATE BY	DATE: 2008/10/01 DATE: 2007/03/19	CONSULTANT DRAWING NO. WB-E0631	TELEPHONE AND DATA OVERALL BUILDING THIRD FLOOR PLAN	CITY DRAWING NUMBER 1-0601A-B-E0631-001-000	