


B PARTIAL DBPS FLOOR PLAN
SCALE: NTS

A PARTIAL SITE PLAN
SCALE: 1 : 750

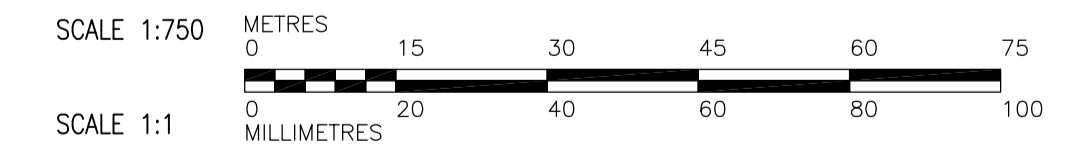

 Certificate of Authorization AECOM Canada Ltd. No. 4671 Date: 2009/02/27	B.M. ELEV.	 Frederickson Cooper ARCHITECTS AECOM	ENGINEER'S SEAL	 THE CITY OF WINNIPEG WATER AND WASTE DEPARTMENT ENGINEERING DIVISION	CITY FILE NUMBER		
			DESIGNED BY: ERC		CHECKED BY: BLM	ORIGINAL SIGNED BY: B.L. MOORE	SHEET OF
			DRAWN BY: ERC		APPROVED BY: SRB	2009/02/27	CITY DRAWING NUMBER
			SCALE: AS SHOWN		RELEASED FOR CONSTRUCTION BY: R. SOROKOWSKI	CONSULTANT DRAWING NO. WM-E0600	1-0601A-M-E0600-001-000
	0 ISSUED FOR TENDER 09/02/27 ERC	DATE 2008/11/15	DATE 2009/02/27	WATER TREATMENT PLANT TELEPHONE AND DATA INSTALLATION TELEPHONE AND DATA SITE PLAN			