

DRAWING LISTS:

ARCHITECTURAL

A1.0 _____

STRUCTURAL


S1.0 _____

MECHANICAL

- M1.0 MECHANICAL 7TH FLOOR PROPOSED LOCATION FOR NEW EQUIPMENT
- M2.0 SUB-BASEMENT MECHANICAL ROOM PROPOSED LOCATION FOR NEW EQUIPMENT
- M3.0 SUB-BASEMENT AND BASEMENT PLANS PROPOSED LOCATION FOR FUEL OIL PIPING RUN

ELECTRICAL


- E0.1 ELECTRICAL DRAWING LIST AND SYMBOL LEGEND
- E1.0 SITE PLAN AND BASEMENT LEVEL PLAN
- E2.0 ELECTRICAL 7TH FLOOR LOCATION FOR NEW EQUIPMENT
- E3.0 NEW EMERGENCY GENERATOR SINGLE LINE SCHEMATIC OF NEW EMERGENCY SYSTEM UPGRADE
- E3.1 NEW SINGLE LINE DISTRIBUTION OF NEW EMERGENCY SYSTEM UPGRADE
- E3.2 EXISTING EMERGENCY GENERATOR SINGLE LINE SCHEMATIC

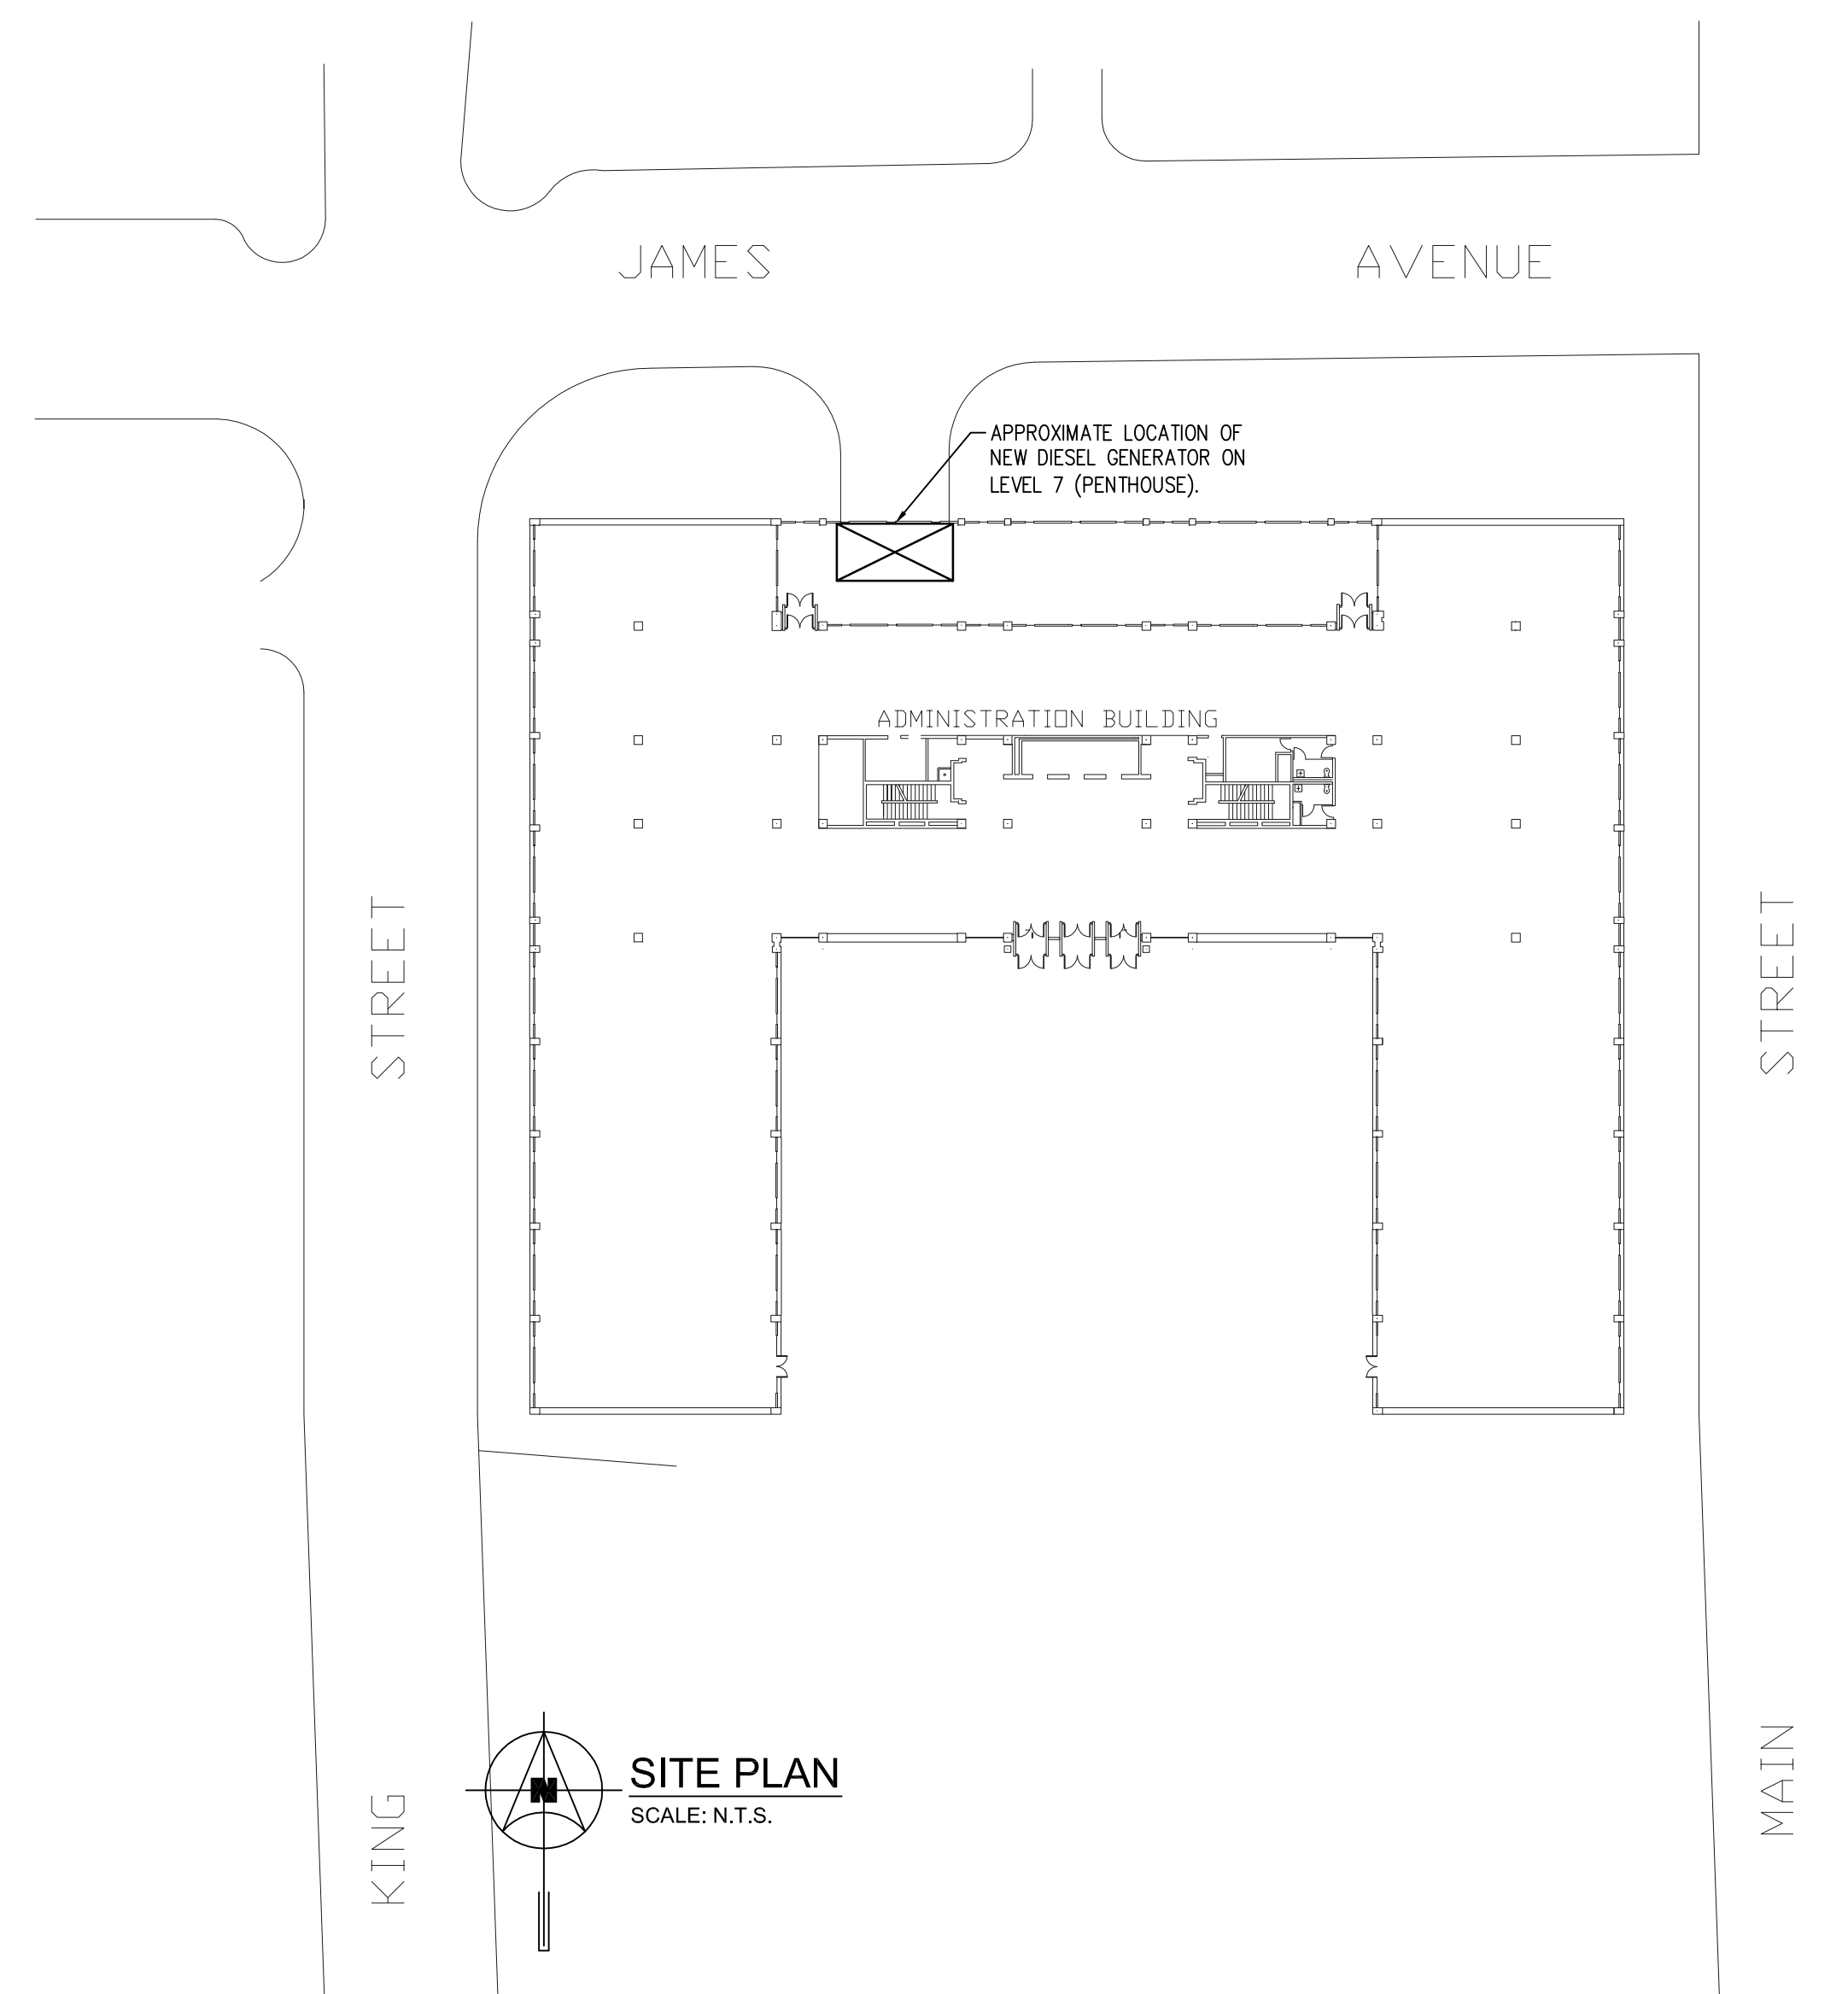

1. ISSUED FOR OWNER'S FINAL REVIEW CB 09.04.24

NO.	REVISION/DESCRIPTION	BY	DATE

SEALS

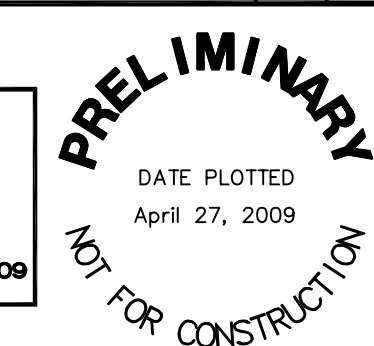

DRAWN BY	CHECKED BY	APPROVED CH
KAM	CR	
DATE	USER APPROVAL	

CITY OF WINNIPEG
 PLANNING, PROPERTY &
 DEVELOPMENT DEPARTMENT
 CIVIC ACCOMMODATIONS DIVISION
 300 - 65 GARRY ST. R3C 4K4

PROJECT
 CITY OF WINNIPEG 510 MAIN ST.
 EMERGENCY DISTRIBUTION UPGRADE
 PHASE 1

SHEET TITLE
 SITE PLAN & DRAWING LIST

SMS ENGINEERING

SMS Engineering Ltd. Consulting Engineers
 770 Bradford Street Winnipeg MB Canada R3B 0K1
 Telephone: 204.775.0291 Fax: 204.772.2153
 sms@smseng.com

SCALE	PROJECT NO.	SHEET NO.
NONE	07-232-01	G0.1