



NORTH ELEVATION

SCALE 1:50

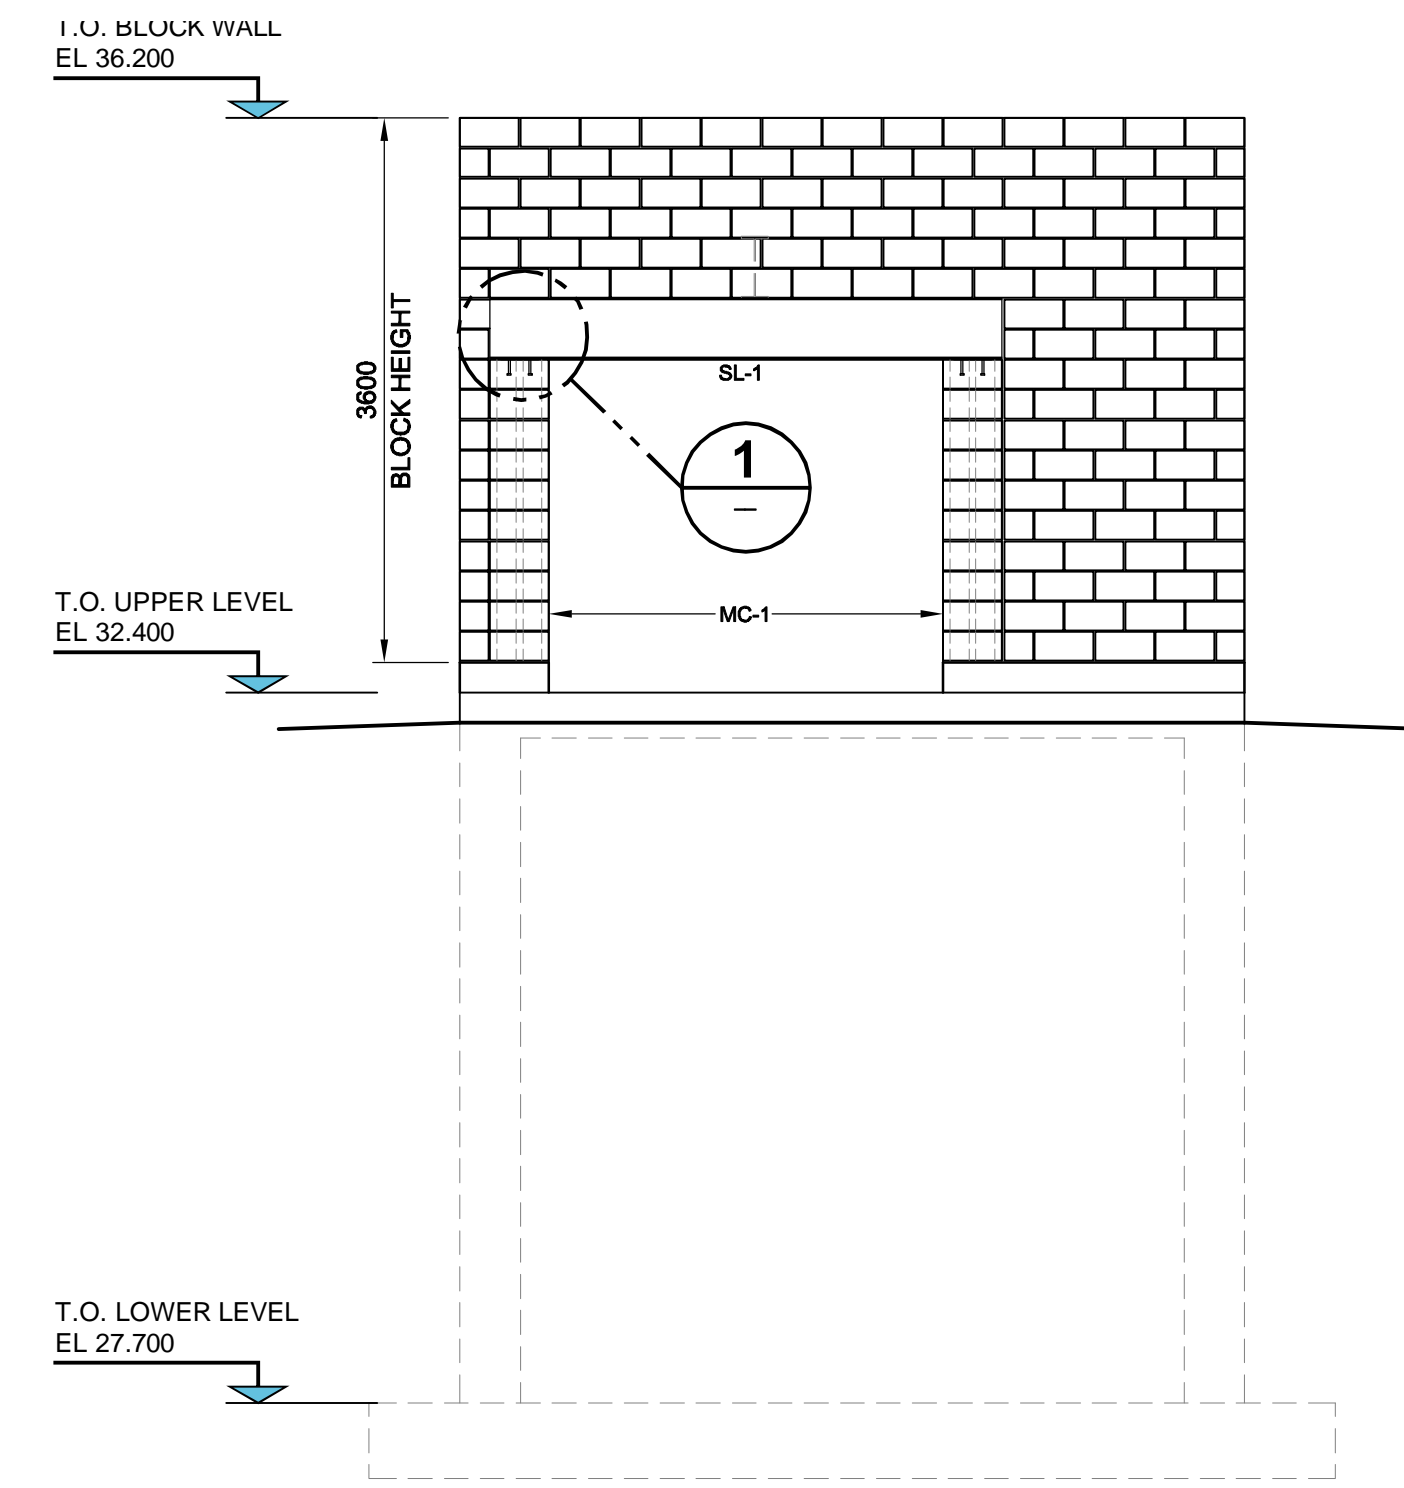

EAST ELEVATION


SCALE 1:50

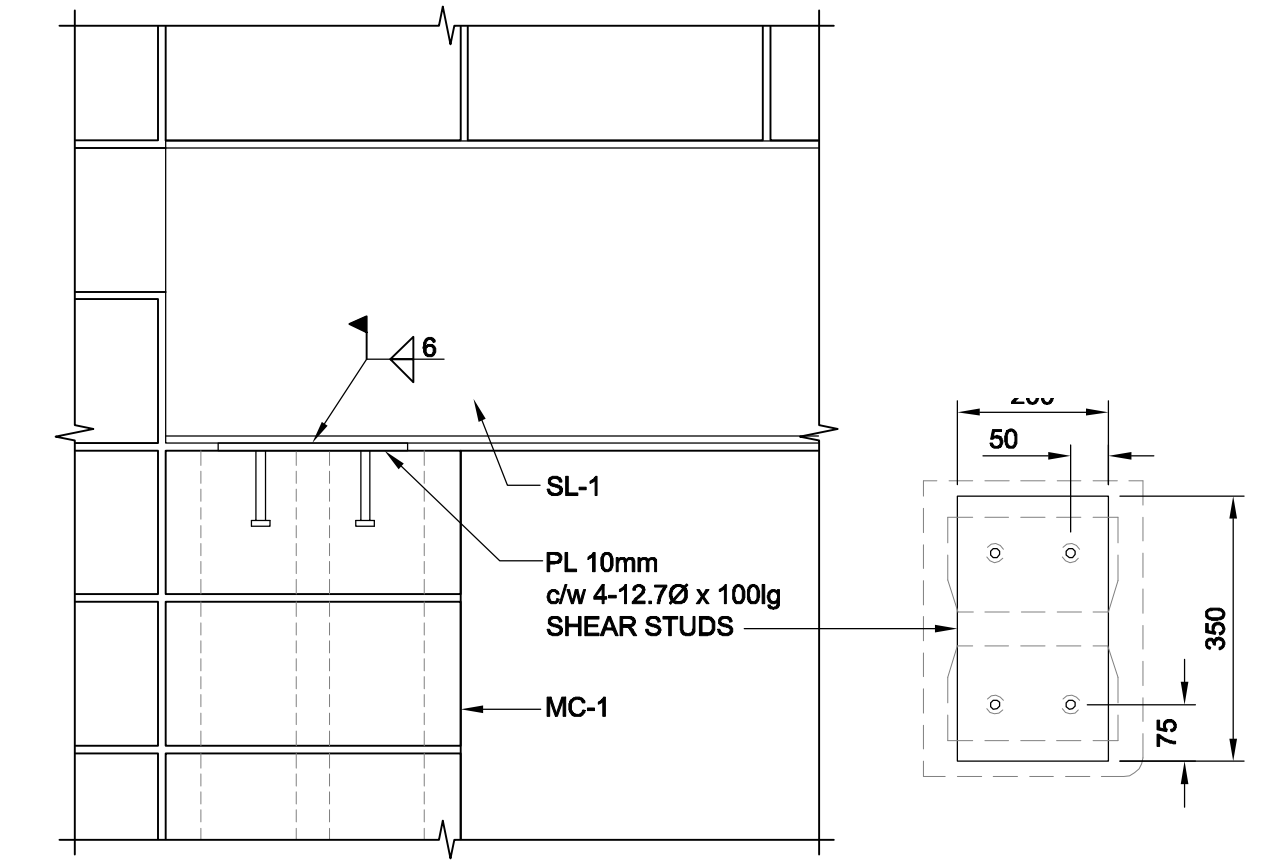

DETAIL

1


SCALE 1:10

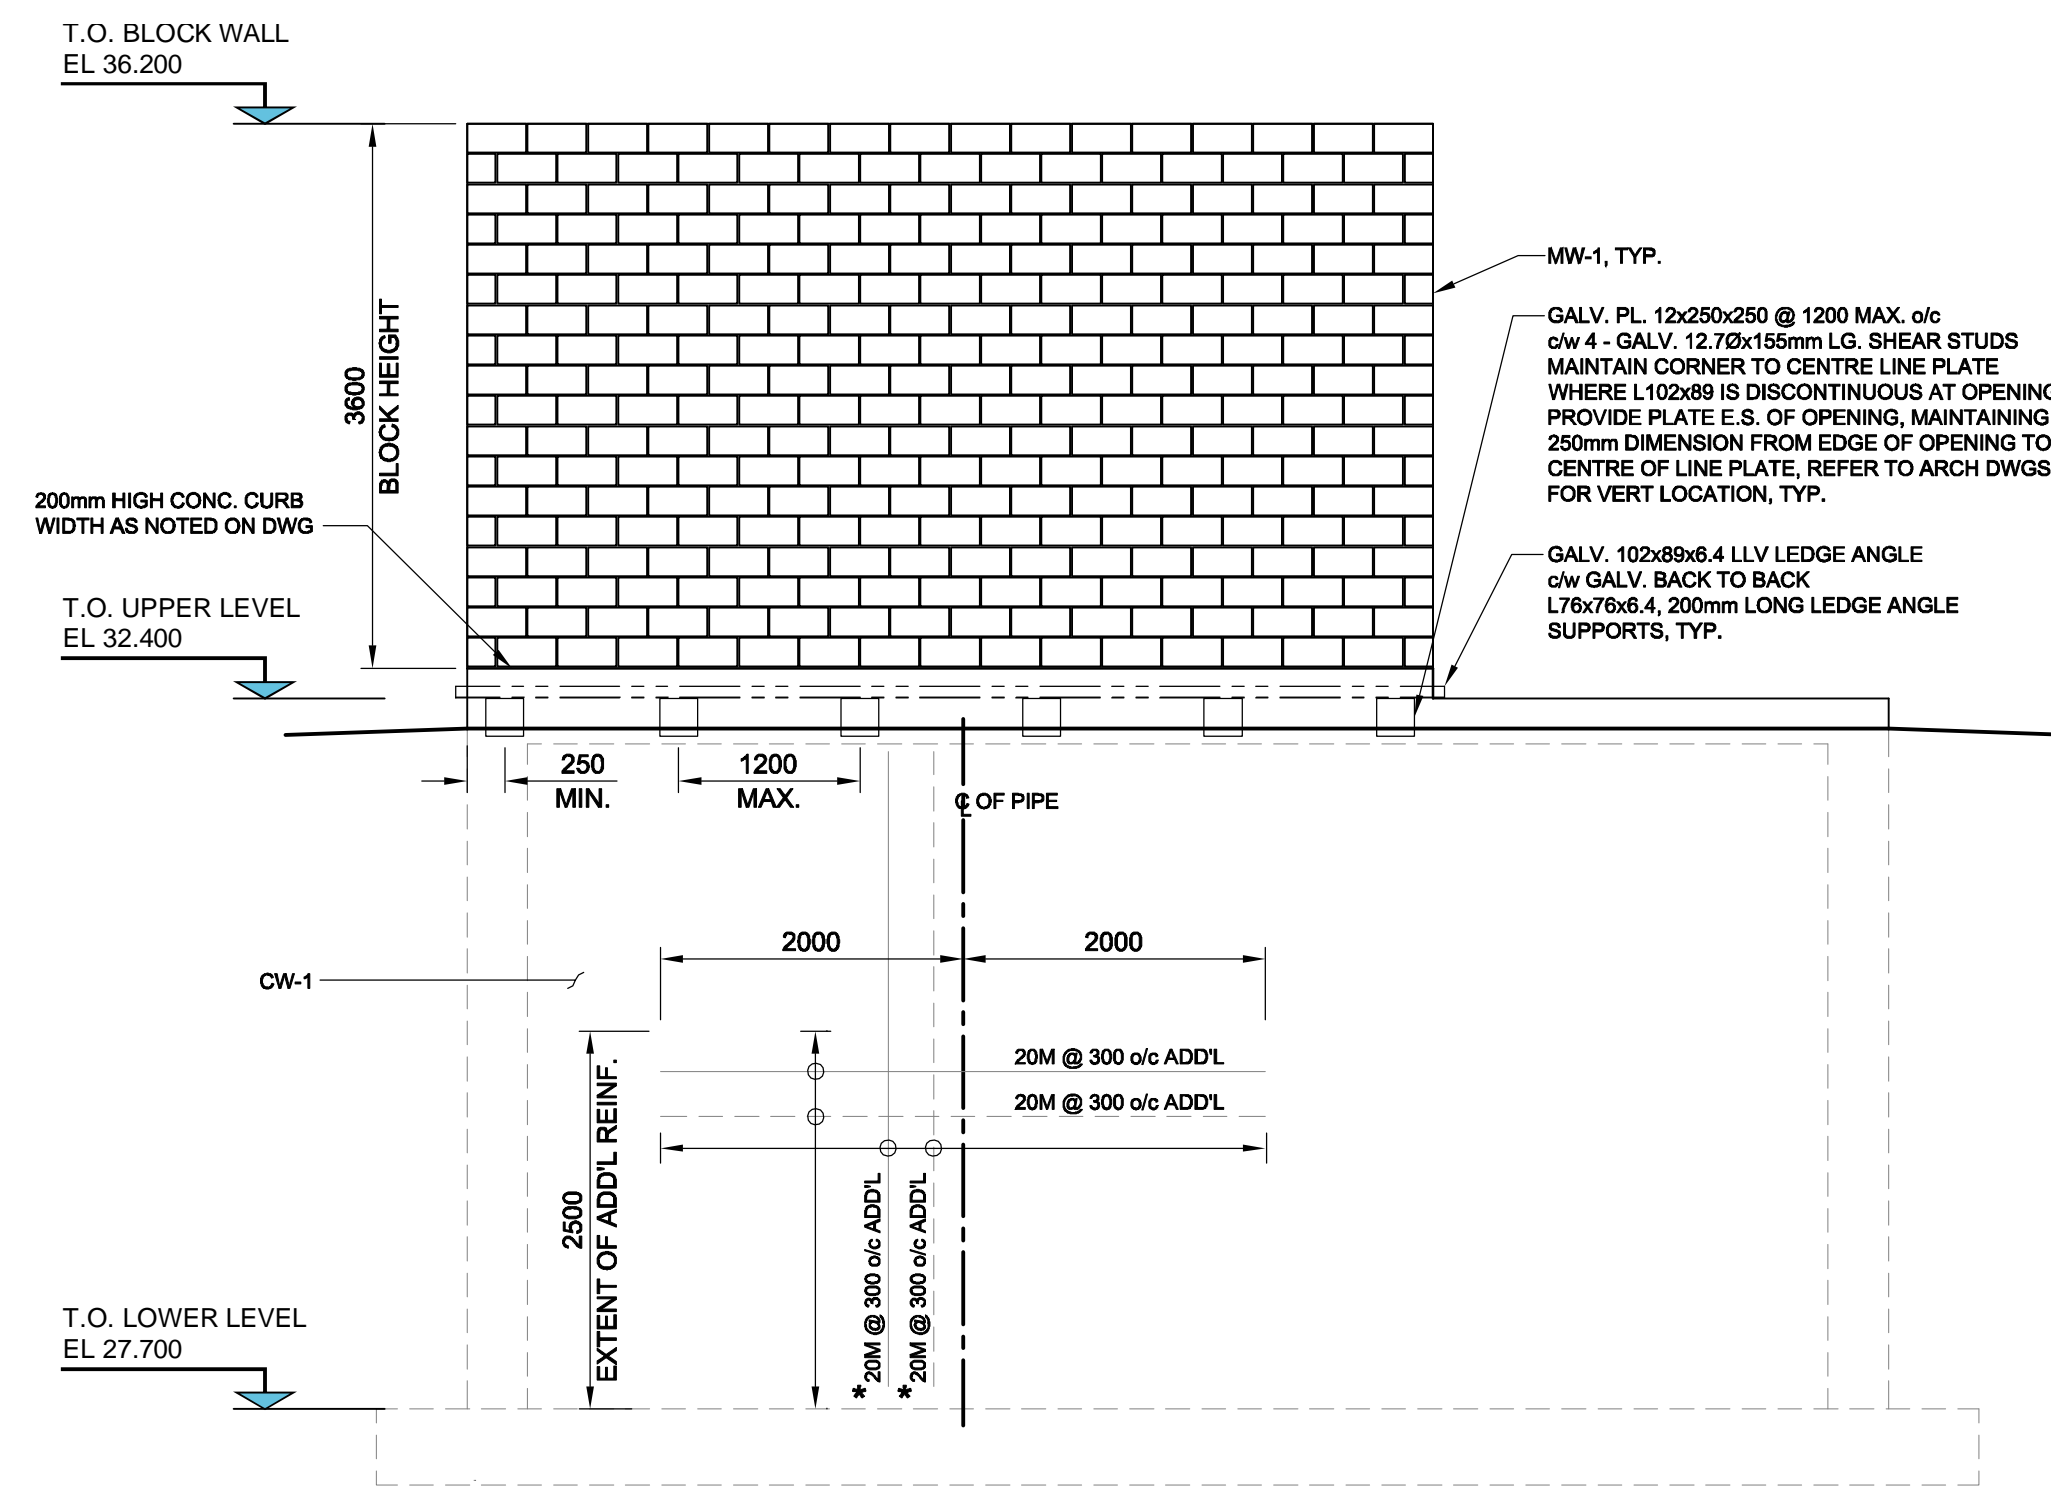

SOUTH ELEVATION

SCALE 1:50

*VERTICAL BARS MATCH DOWEL BARS TO BASE SLAB

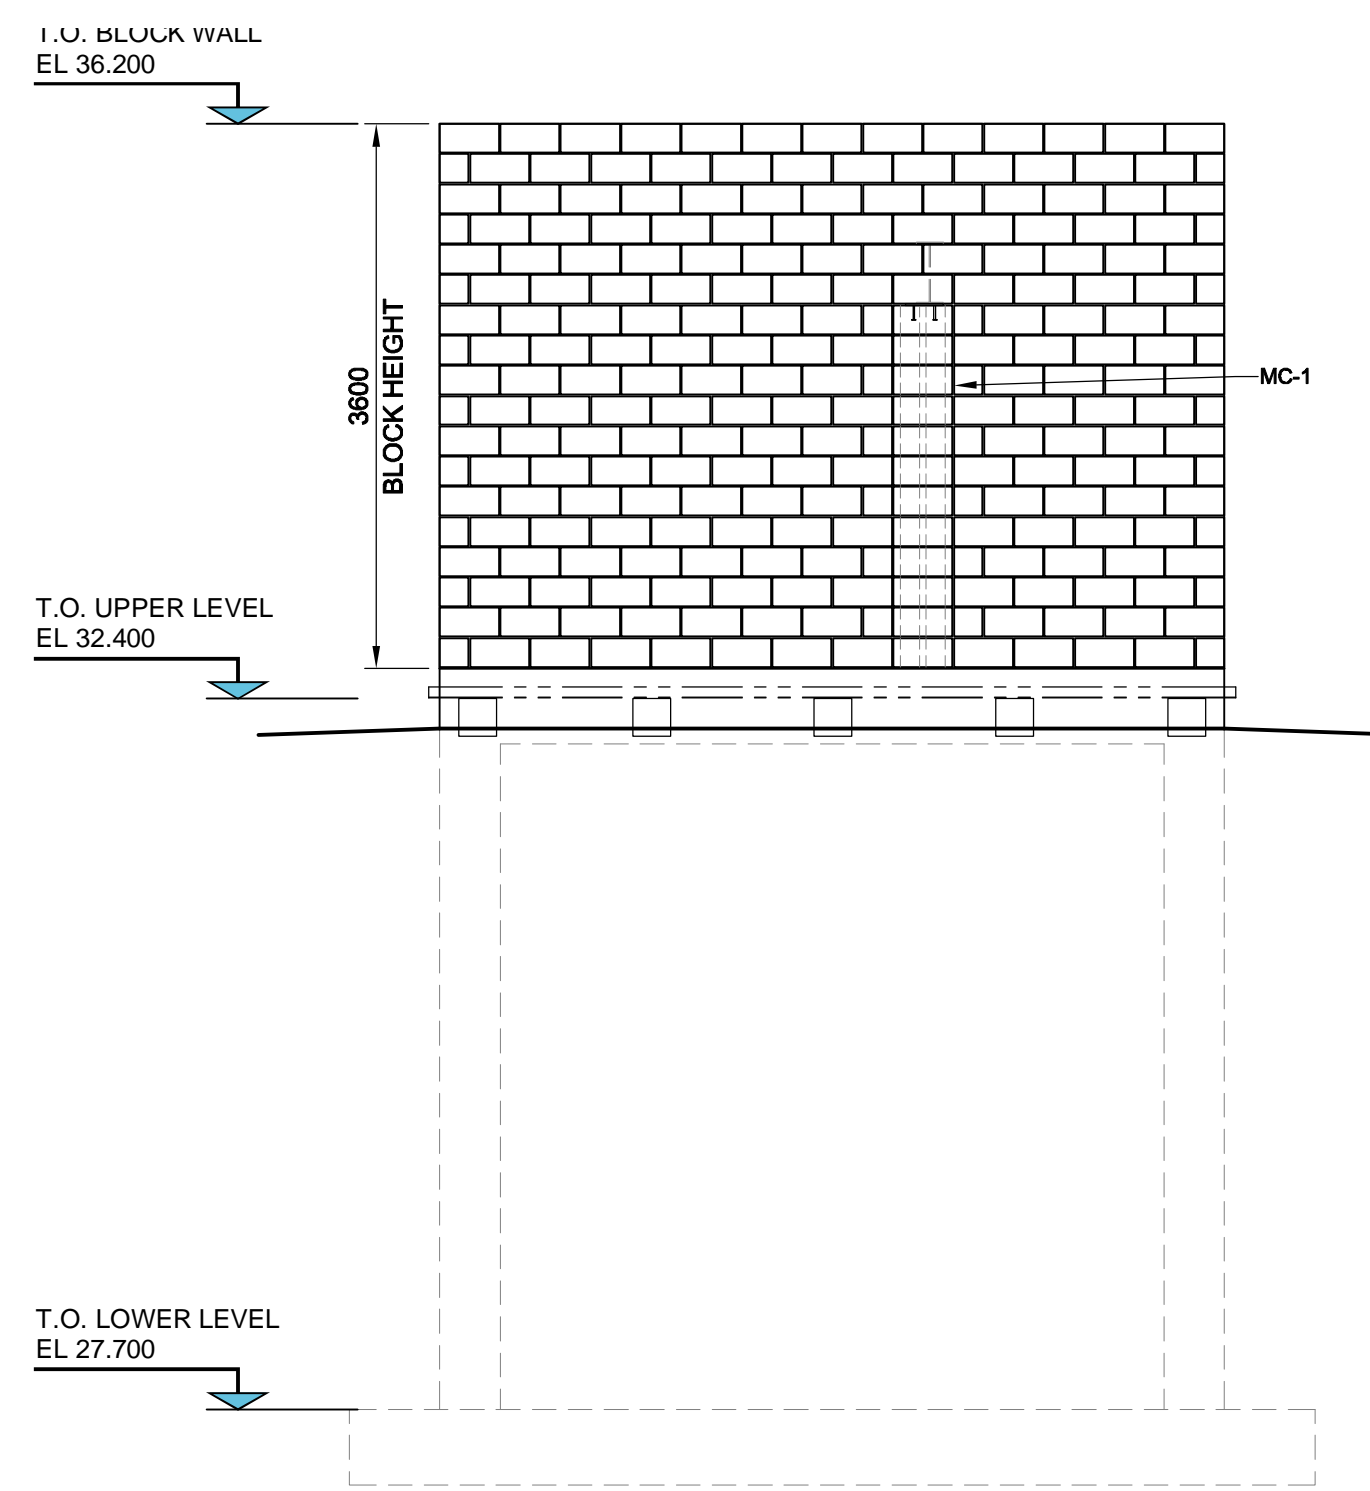

WEST ELEVATION

SCALE 1:50

LOCATION APPROVED UNDERGROUND STRUCTURES

SUPR. U/G STRUCTURES DATE COMMITTEE

NOTE:
LOCATION OF UNDERGROUND STRUCTURES AS SHOWN ARE BASED ON THE BEST INFORMATION AVAILABLE. BUT NO GUARANTEE IS GIVEN THAT ALL EXISTING UTILITIES ARE SHOWN OR THAT THE GIVEN LOCATIONS ARE EXACT. CONFIRMATION OF EXISTENCE AND EXACT LOCATION OF ALL SERVICES MUST BE OBTAINED FROM THE INDIVIDUAL UTILITIES BEFORE PROCEEDING WITH CONSTRUCTION.



Certificate of Authorization
AECOM Canada Ltd.
No. 4671 Date: FEB. 08, 2010

NO.	REVISIONS	YYMMDD	BY
0	ISSUED FOR CONSTRUCTION	10/02/08	KK

AECOM		This drawing has been prepared for the use of AECOM's client and may not be used, reproduced or relied upon by third parties, except as agreed by AECOM and its client, as required by law or for use by governmental reviewing agencies. AECOM accepts no responsibility, and denies any liability whatsoever, to any party that modifies this drawing without AECOM's express written consent. Do not scale this document. All measurements must be obtained from stated dimensions.	
DESIGNED BY	KK/GGP	CHECKED BY	GGP
DRAWN BY	KK	APPROVED BY	Bryan Weber
HOR. SCALE	AS SHOWN	RELEASED FOR CONSTRUCTION	KZ
VERT. SCALE	-	DATE	FEB. 9/10

PROFESSIONAL'S SEAL	ORIGINAL SIGNED BY
	B.F. ABDUL WAHID
	2010/02/08
CONSULTANT DRAWING NO.	D265-250-00_01-S-2001_RX.dwg

BID OPPORTUNITY NO. 16-2010

THE CITY OF WINNIPEG
WATER AND WASTE DEPARTMENT

BRANCH I AQUEDUCT VALVE CHAMBER
AT McPHILLIPS STREET
PUMPING STATION

STRUCTURAL ELEVATIONS

SHEET 16 OF 28	REV 0
CITY DRAWING NUMBER	D-11926