


FEEDER SCHEDULE

TYPE	DESCRIPTION	AMPACITY
①	2X (4- #750MCM RA90 AL. DIRECT BURIED) AS PER CEC TABLE D9B, DIAGRAM B4-1, DETAIL 2	1140
②	4- #3 RW90 CU. IN 35mmC	105
③	4- #4/0 RW90 CU. IN 53mmC	235
④	4- #3/0 RW90 CU. IN 53mmC	210
⑤	REFER TO MECHANICAL SCHEDULE	
⑥	4- #4/0 RA90 AL. DIRECT BURIED AS PER CEC TABLE D9B, DIAGRAM B4-1, DETAIL 1	210

NOTES:

- PROVIDE LEED APPROVED DIGITAL MONITOR/METERING DEVICE.
 - PROVIDE 30A/8P RELAY/CONTACTOR FOR EXTERIOR HOCKEY RINK LIGHTING CONTROL C/W KEY ON AND MUSHROOM OFF SWITCH.
 - PROVIDE ONE (1) JUNCTION BOX FOR EACH LOAD TYPE C/W LEED APPROVED DIGITAL MONITOR/METERING DEVICE TO MONITOR THE FOLLOWING LOADS INDIVIDUALLY:
 - LIGHTING
 - RINK LIGHTING
 - ELECTRIC HEATING
 - MISCELLANEOUS POWER
- TOTAL OF FOUR(4) JUNCTION BOXES C/W FOUR(4) METERS SHALL BE PROVIDED.

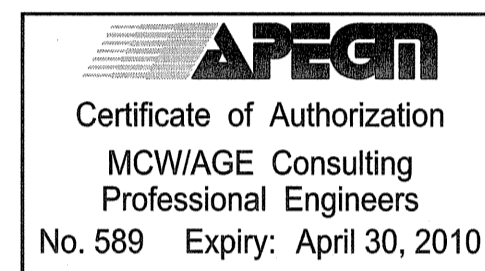


D ISSUED FOR TENDER FEB 26, 2010
 C ISSUED FOR 99% REVIEW FEB 10, 2010
 B ISSUED FOR 90% REVIEW JAN 08, 2010
 A ISSUED FOR 60% REVIEW DEC 02, 2009

This drawing must not be scaled.
 The general Contractor must verify all dimensions, datums and levels prior to commencement of work. All errors and omissions must be reported immediately to the Architect.

Variations and modifications to work shown on this drawing shall not be carried out without written permission from the Architect.

This drawing is the exclusive property of the Architect and cannot be reproduced without written permission of the Architect. Reproduction must bear the name of the Architect. Copyright © 2009.

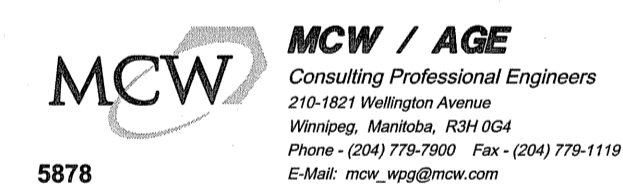

project
SINCLAIR COMMUNITY CENTRE ADDITION & RENOVATIONS
 490 Sinclair Street, Winnipeg

sheet title
ELECTRICAL SINGLE LINE DISTRIBUTION SCHEMATIC

project number: 5878 drawing number:
 scale: N.T.S. **E4.1**
 drawn by: P.A.S.
 approved by: K.B.G.
 date: 2010-02-26