


**1 BASEMENT PLAN- HVAC DEMOLITION LAYOUT**  
 M1.1 SCALE: 1:100

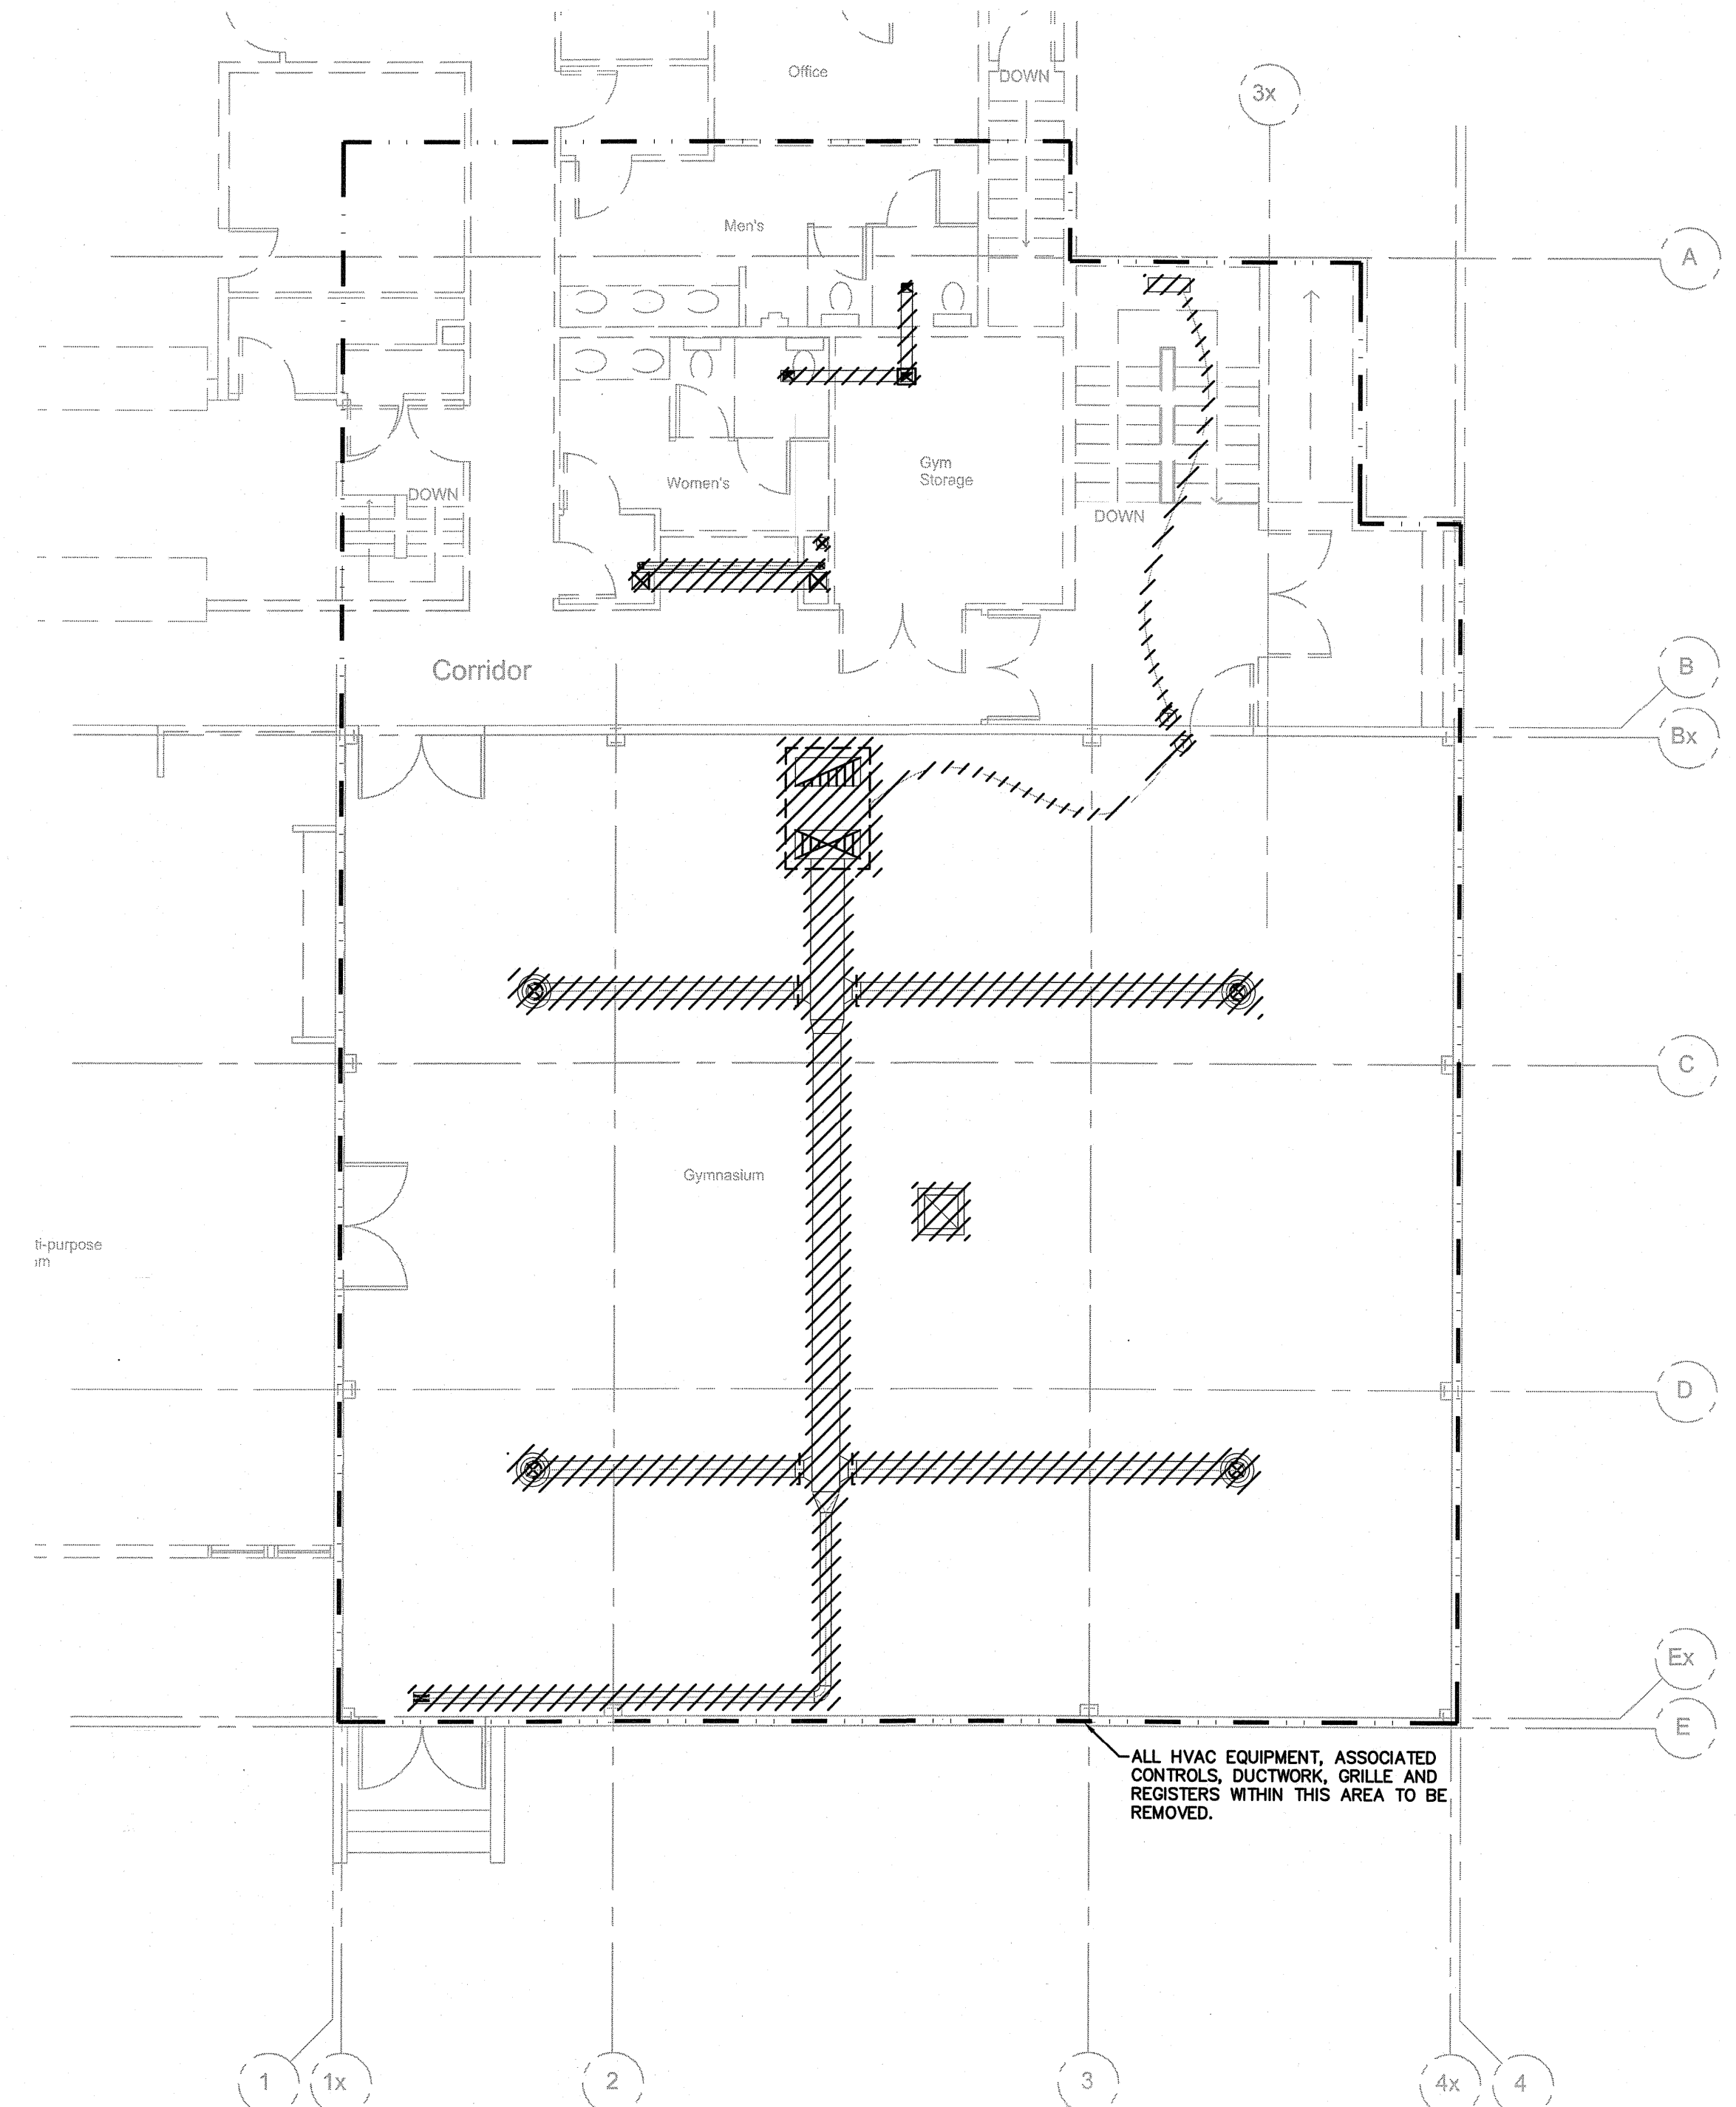

**2 MAIN FLOOR PLAN- HVAC DEMOLITION LAYOUT**  
 M1.1 SCALE: 1:100

- GENERAL NOTES:**
1. THIS DRAWING IS DIAGRAMMATIC ONLY. DO NOT SCALE.
  2. CONTRACTOR TO CONFIRM EXACT LOCATION AND SIZES OF EXISTING EQUIPMENT ON SITE PRIOR TO TENDER.



**APEGM**  
 Certificate of Authorization  
 MCW/AGE Consulting  
 Professional Engineers  
 No. 589 Expiry: April 30, 2010

- |                         |              |
|-------------------------|--------------|
| D ISSUED FOR TENDER     | FEB 26, 2010 |
| C ISSUED FOR 99% REVIEW | FEB 10, 2010 |
| B ISSUED FOR 90% REVIEW | JAN 08, 2010 |
| A ISSUED FOR 60% REVIEW | DEC 02, 2009 |

This drawing must not be scaled.

The general Contractor must verify all dimensions, datums and levels prior to commencement of work. All errors and omissions must be reported immediately to the Architect.

Variations and modifications to work shown on this drawing shall not be carried out without written permission from the Architect.

This drawing is the exclusive property of the Architect and cannot be reproduced without written permission of the Architect. Reproduction must bear the name of the Architect. Copyright © 2009.

**MCW / AGE**  
 Consulting Professional Engineers  
 210-1621 Wellington Avenue  
 Winnipeg, Manitoba, R2W 0C4  
 Phone - (204) 779-7900 Fax - (204) 779-1119  
 E-Mail: mcw\_age@mcw.com  
 5878

**harold funk architect inc.**  
 Harold Funk Architect Inc.  
 Architecture and Urban Design  
 401-55 Donald Street, Winnipeg, Manitoba R3C 1L8  
 T (204) 943-5087 info@funkarchitect.com  
 F (204) 949-9331 funkarchitect.com

project  
**SINCLAIR COMMUNITY CENTRE**  
**ADDITION & RENOVATIONS**  
 490 Sinclair Street, Winnipeg

sheet title  
**BASEMENT AND MAIN FLOOR PLAN- HVAC DEMOLITION LAYOUT**

project number: 5878	drawing number:
scale: N.T.S.	<b>M2.1</b>
drawn by: KLG	
approved by: GSR	
date: 2010-02-26	