


GENERAL NOTES:

1. THIS DRAWING IS DIAGRAMMATIC ONLY. DO NOT SCALE.
2. CONTRACTOR SHALL BE RESPONSIBLE FOR COORDINATING EXACT LAYOUTS, ROUTING ETC.

DRAWING NOTES:

- ① ELECTRIC BASEBOARD, C/W EXPANDED METAL COVER. REFER TO ELECTRICAL DRAWINGS.
- ② ELECTRIC FORCE FLOW. REFER TO ELECTRICAL DRAWINGS.
- ③ THERMOSTAT C/W LOCKABLE LEXAN COVER.

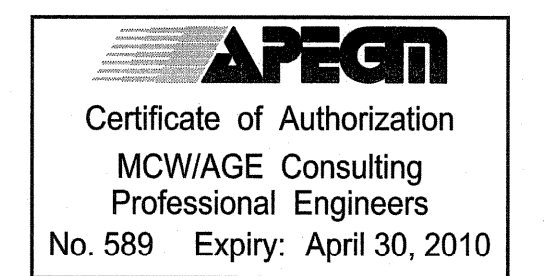


D ISSUED FOR TENDER	FEB 26, 2010
C ISSUED FOR 99% REVIEW	FEB 10, 2010
B ISSUED FOR 90% REVIEW	DEC 18, 2009
A ISSUED FOR 60% REVIEW	DEC 02, 2009

This drawing must not be scaled.

The general Contractor must verify all dimensions, datums and levels prior to commencement of work. All errors and omissions must be reported immediately to the Architect.

Variations and modifications to work shown on this drawing shall not be carried out without written permission from the Architect.

This drawing is the exclusive property of the Architect and cannot be reproduced without written permission of the Architect. Reproduction must bear the name of the Architect. Copyright © 2009.

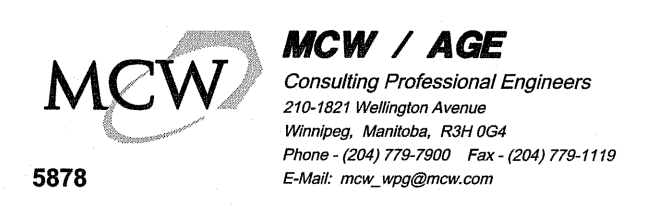

project
**SINCLAIR COMMUNITY CENTRE
 ADDITION & RENOVATIONS**
 490 Sinclair Street, Winnipeg

sheet title
**MAIN FLOOR PLAN-
 HEATING LAYOUT**

project number: 5878 drawing number:
 scale: N.T.S. **M4.2**
 drawn by: KLG
 approved by: GSR
 date: 2010-02-26

1 MAIN FLOOR PLAN- HEATING LAYOUT
 M4.2 SCALE: 1:100