




PLAN OF DIGESTION TANKS & ELUTRIATION BUILDING
SCALE: 3/8" = 1'-0"

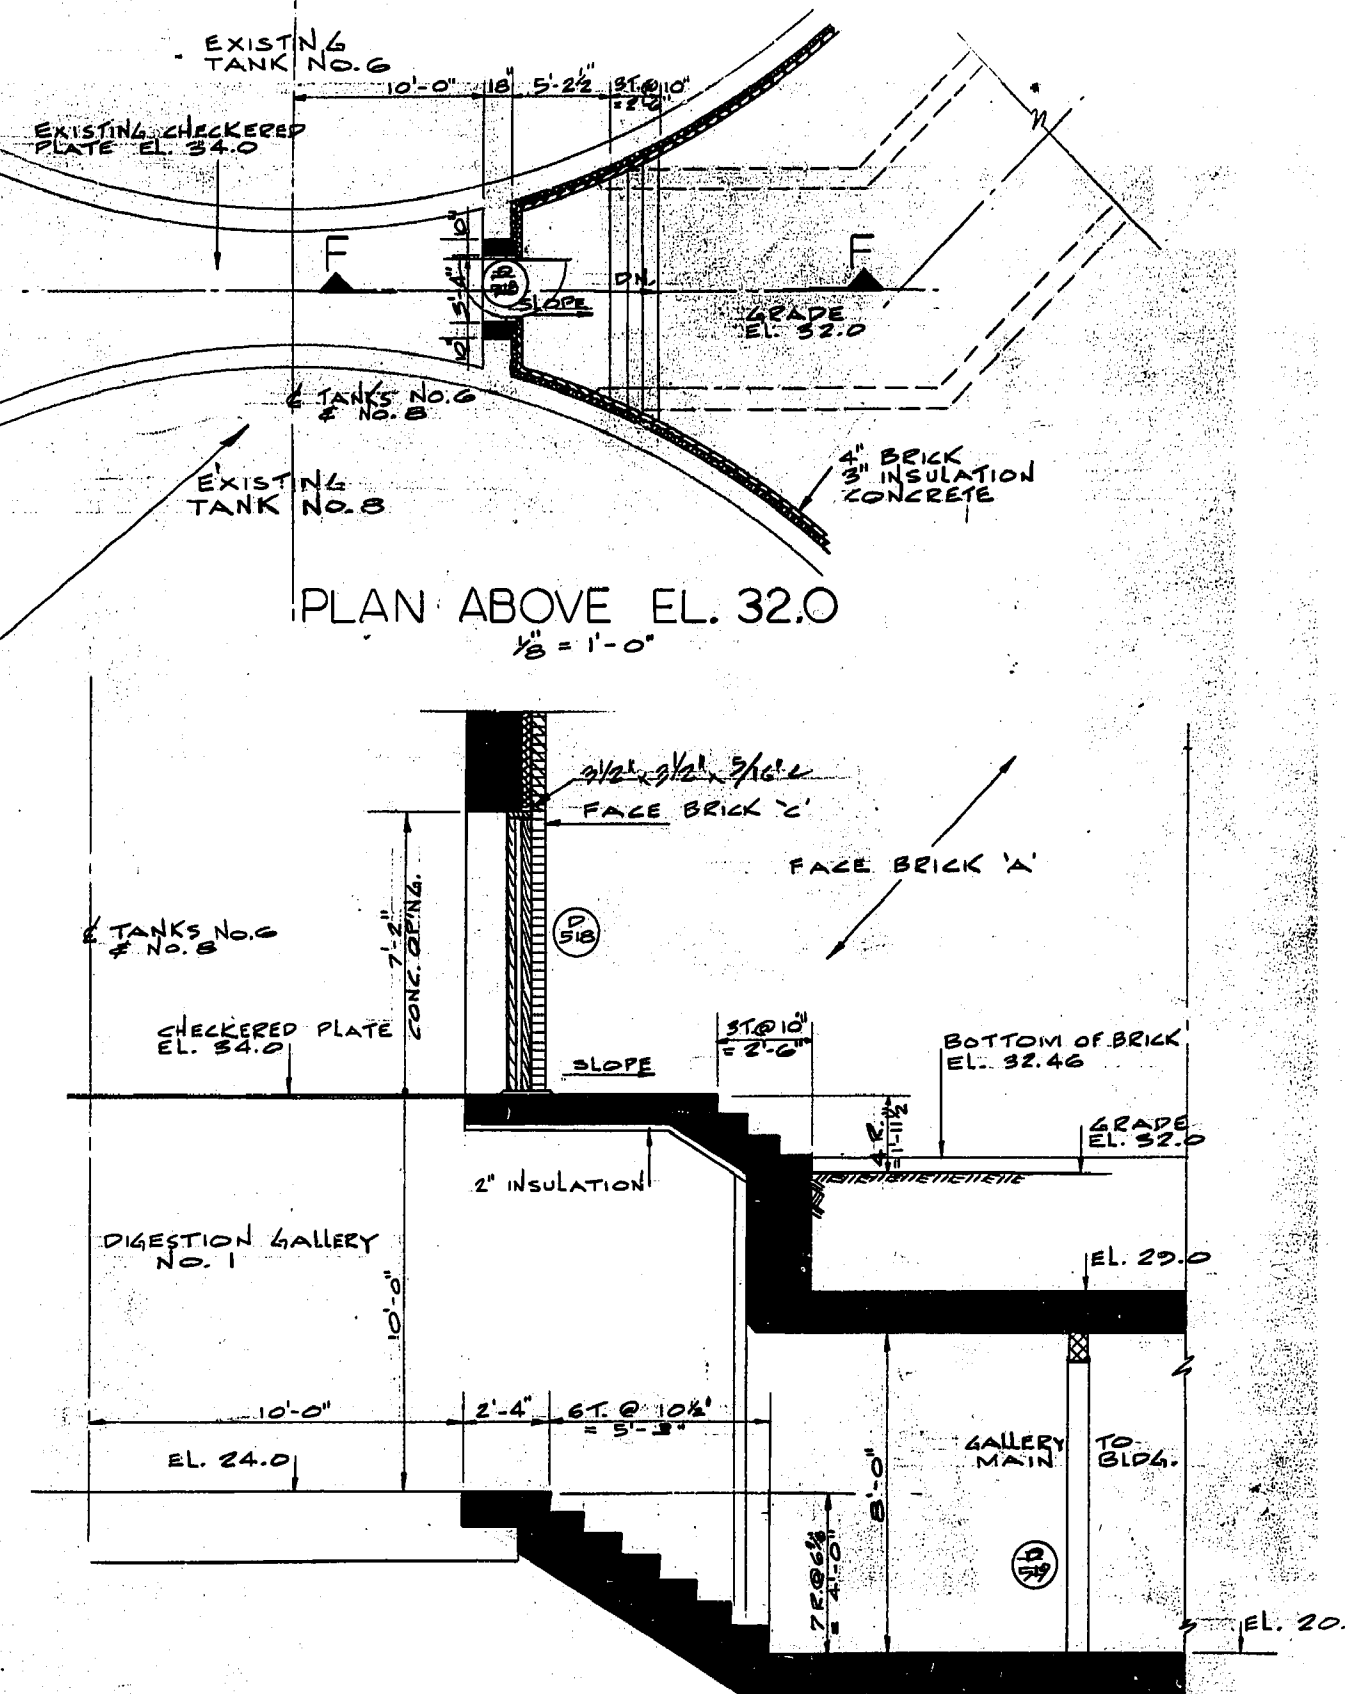


SECTION F-F
1/2" = 1'-0"

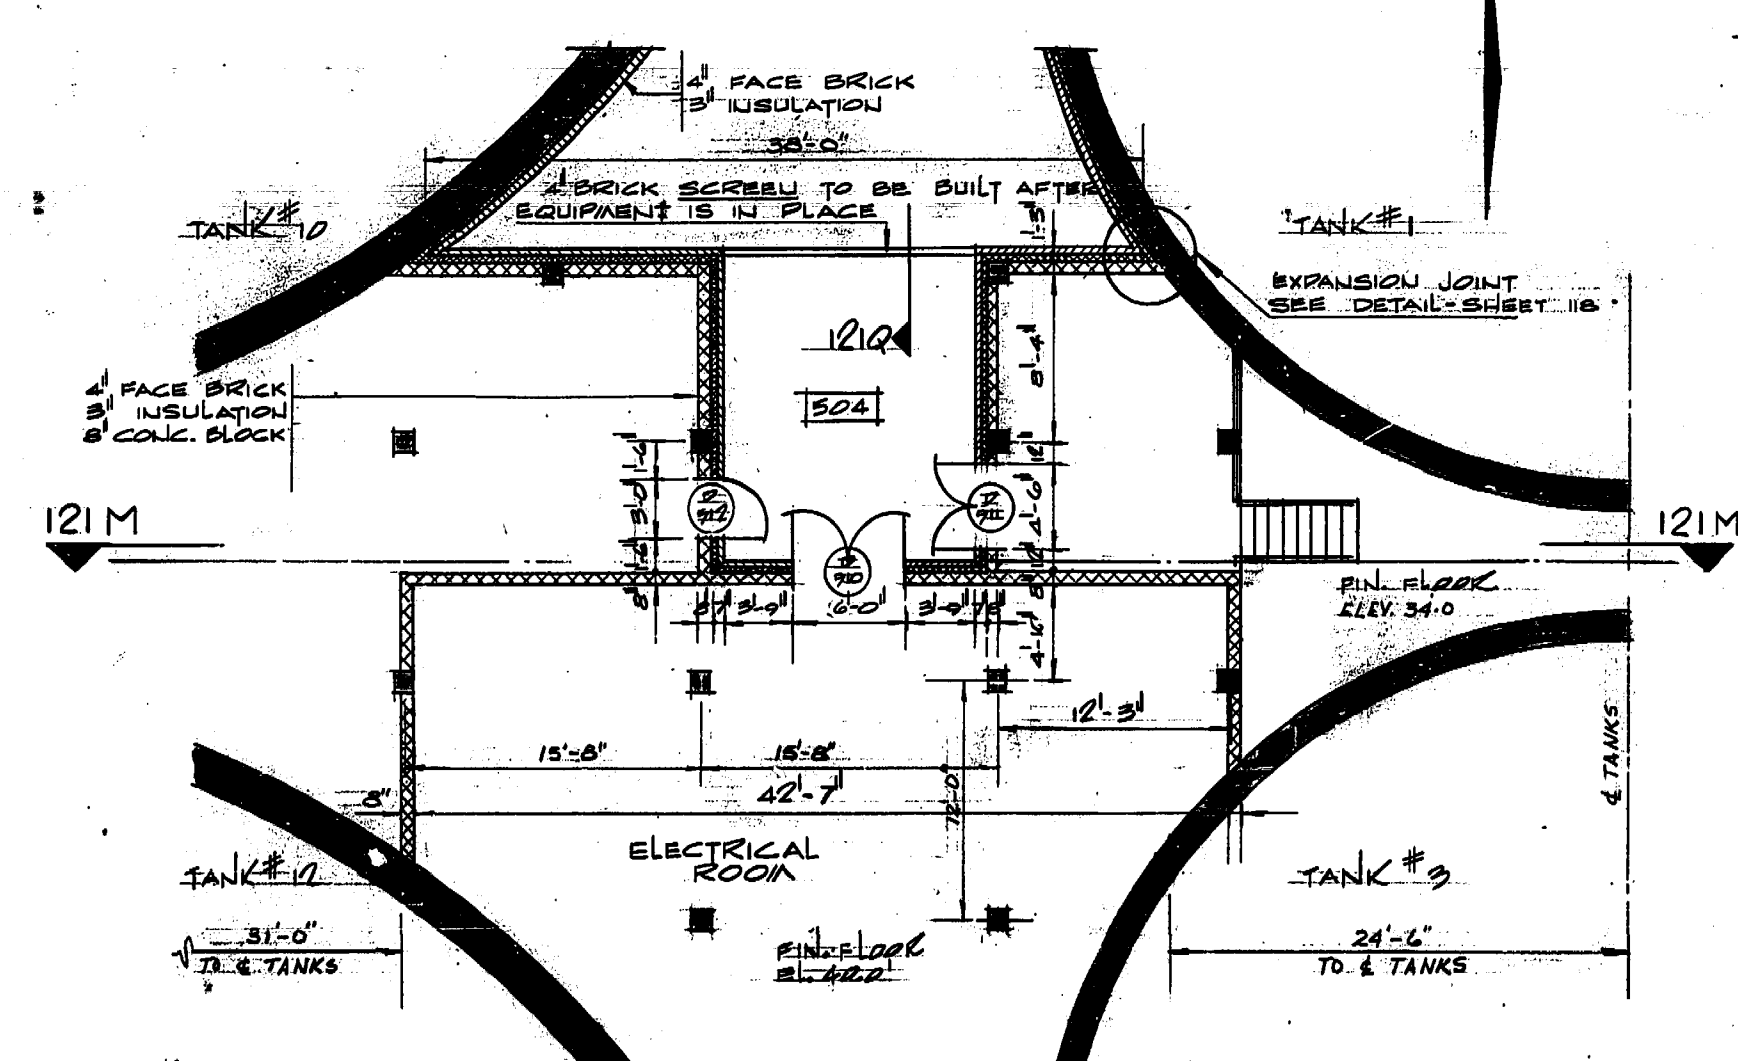

PLAN OF DIGESTION GALLERY NO. 4
SCALE: 1/4" = 1'-0"

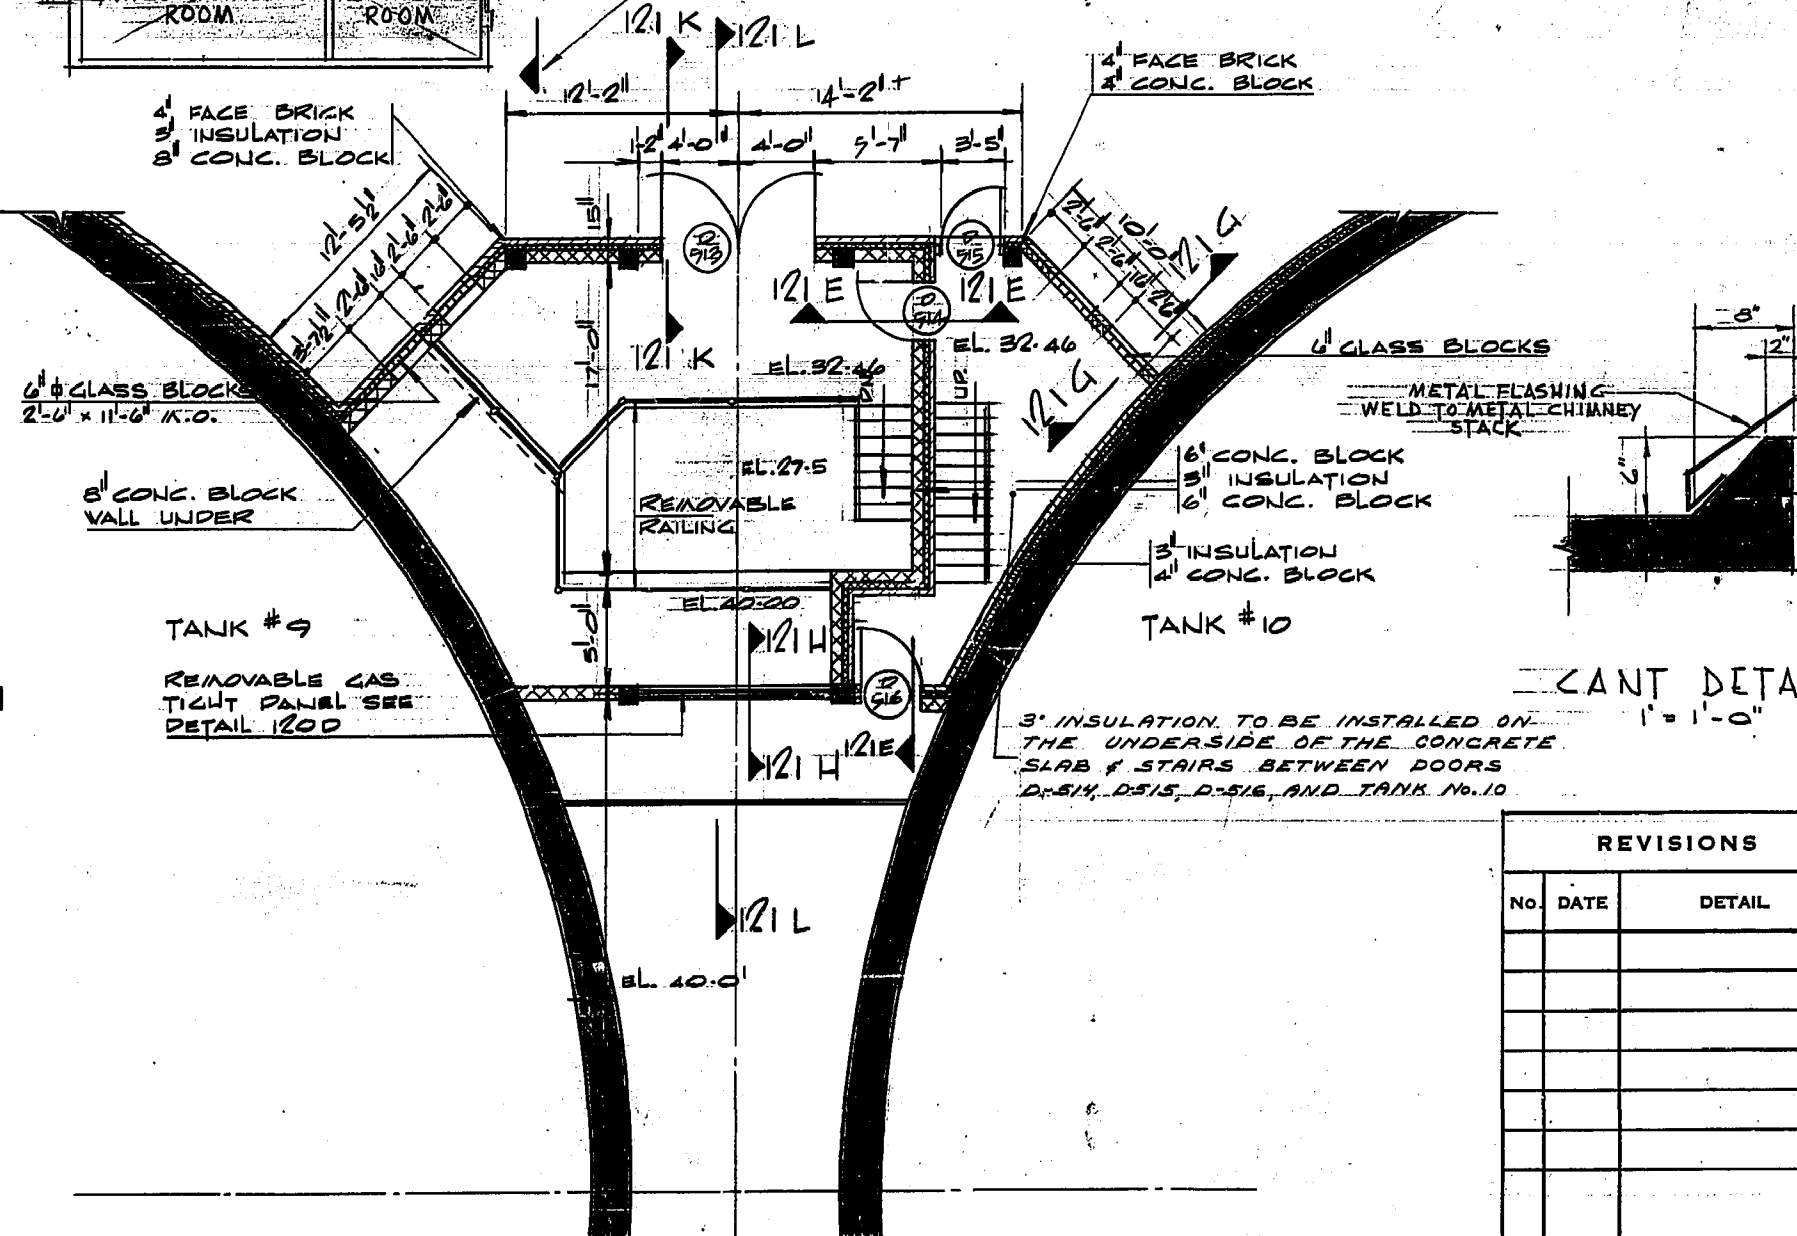

PLAN OF DIGESTION GALLERY NO. 5
SCALE: 1/4" = 1'-0"

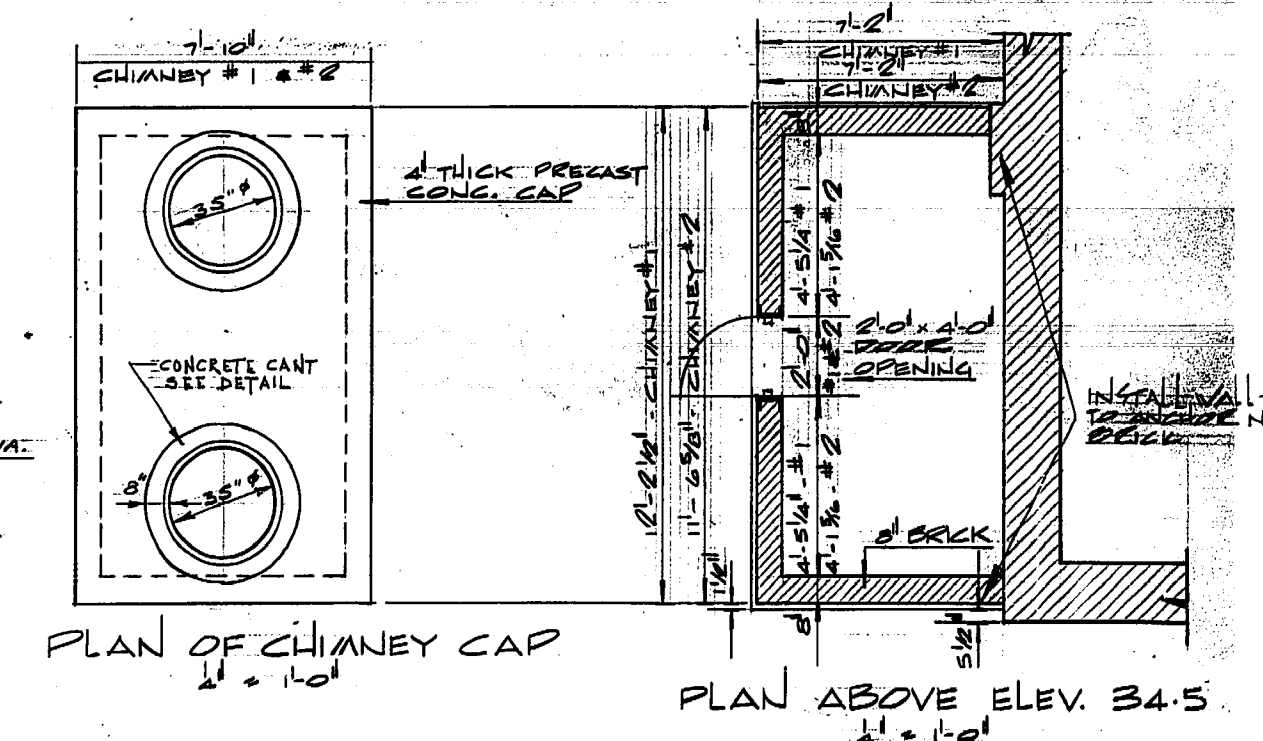

REVISIONS		
NO.	DATE	DETAIL



THE METROPOLITAN CORPORATION OF GREATER WINNIPEG
 WATERWORKS AND WASTE DISPOSAL DIVISION

NORTH END SEWAGE TREATMENT PLANT

CONTRACT A - DIGESTION BUILDING SUPERSTRUCTURE

PLANS & WALL SECTIONS

APPROVED: *J. MacLaren*
 JAMES F. MACLAREN LIMITED ENGINEERS TORONTO

APPROVED: *J. Penman*
 W.L. WARDROP ASSOCIATES (MANAGEMENT) LIMITED ENGINEERING CONSULTANTS WINNIPEG

DATE: MARCH 11, 1963
 SCALE: AS SHOWN
 DWG. No. 119 OF 217

NEP-119

FOR ACTUAL ELEV. SUBTRACT 0.37 FT. **AS BUILT**

AUG. 1965