

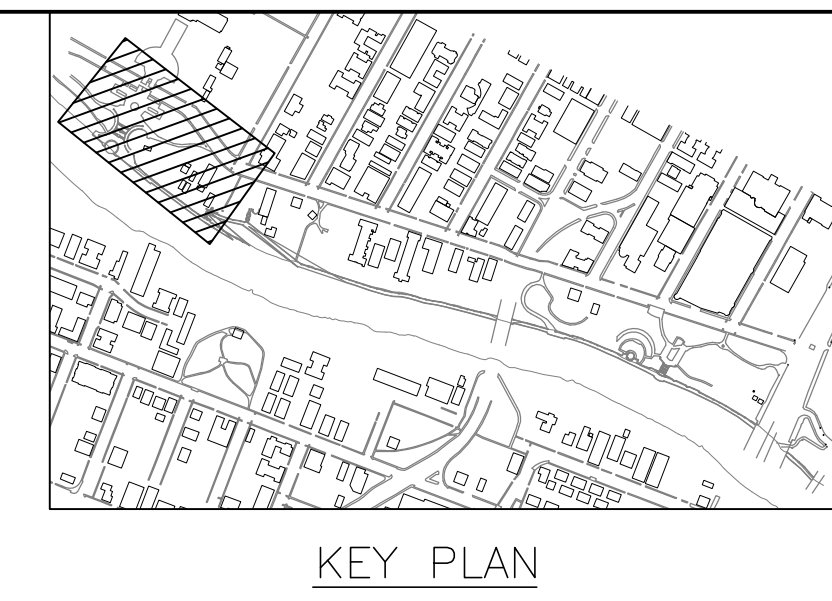


CAD File Name: 10-0109-10_e03-see 0109g
 Date: 10/09/22
 Scale: 1:600
 Project: Assiniboine Riverwalk Electrical Upgrades

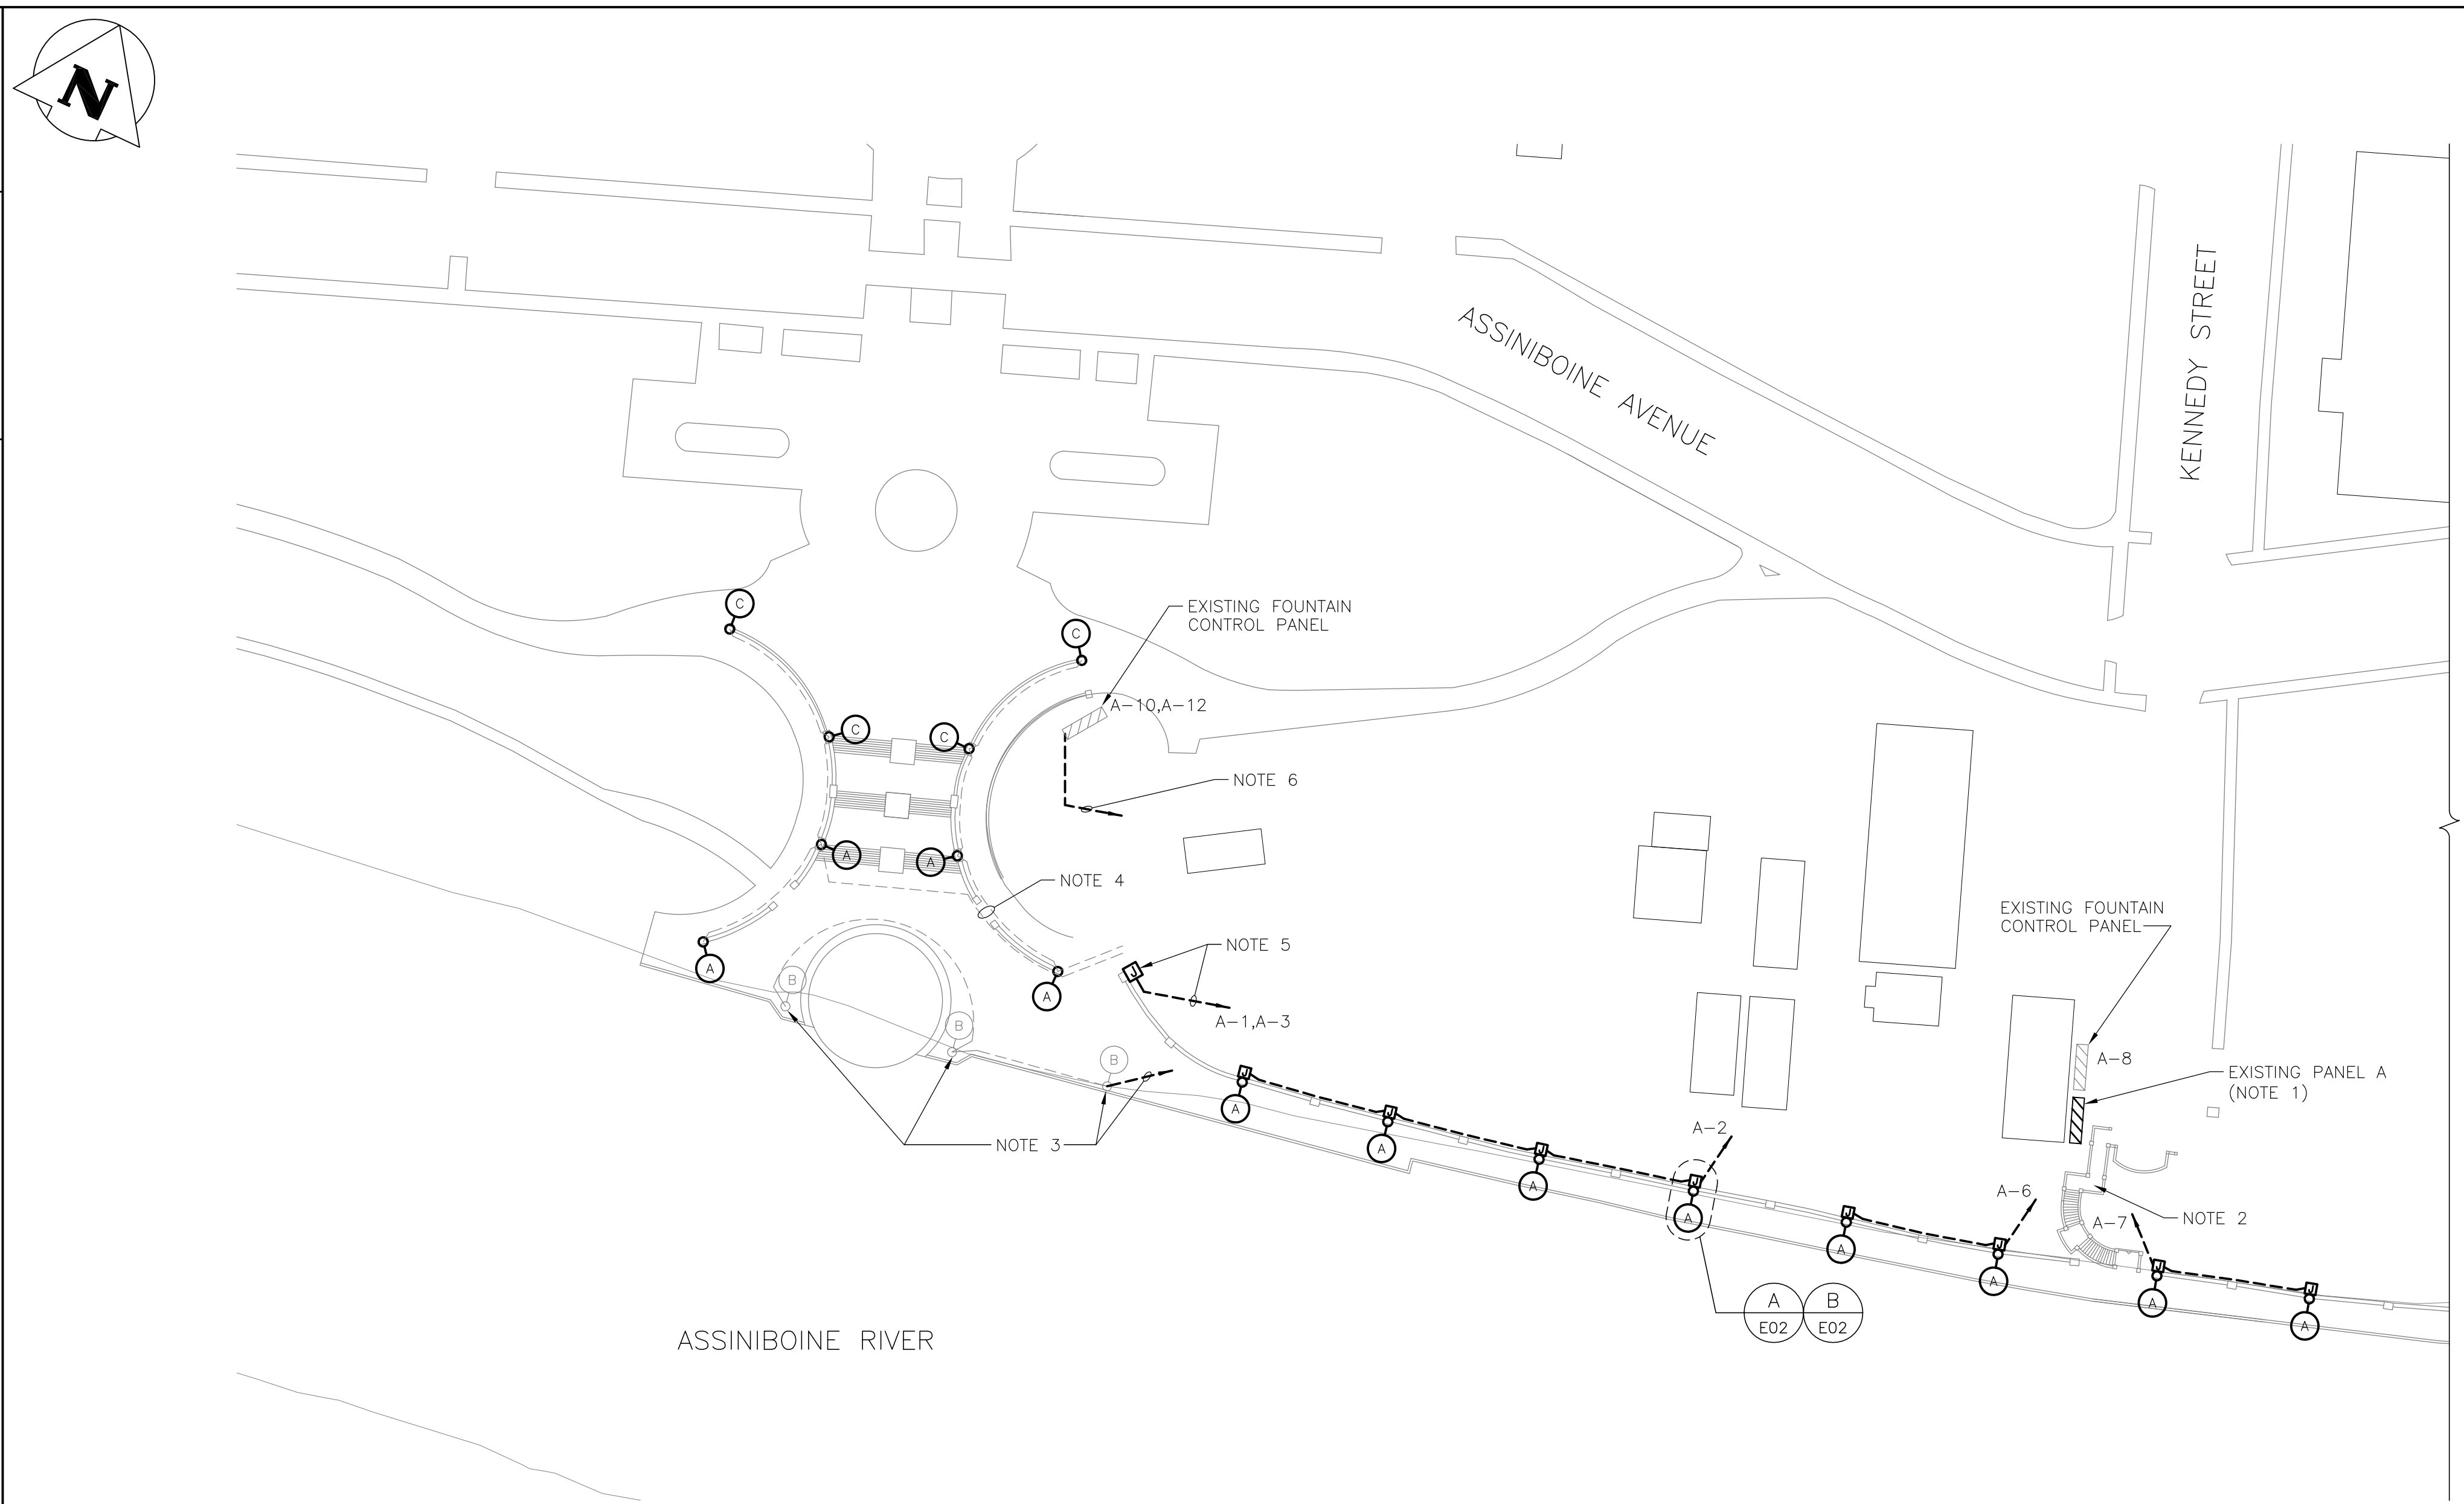

FOR CONTINUATION SEE DWG E04

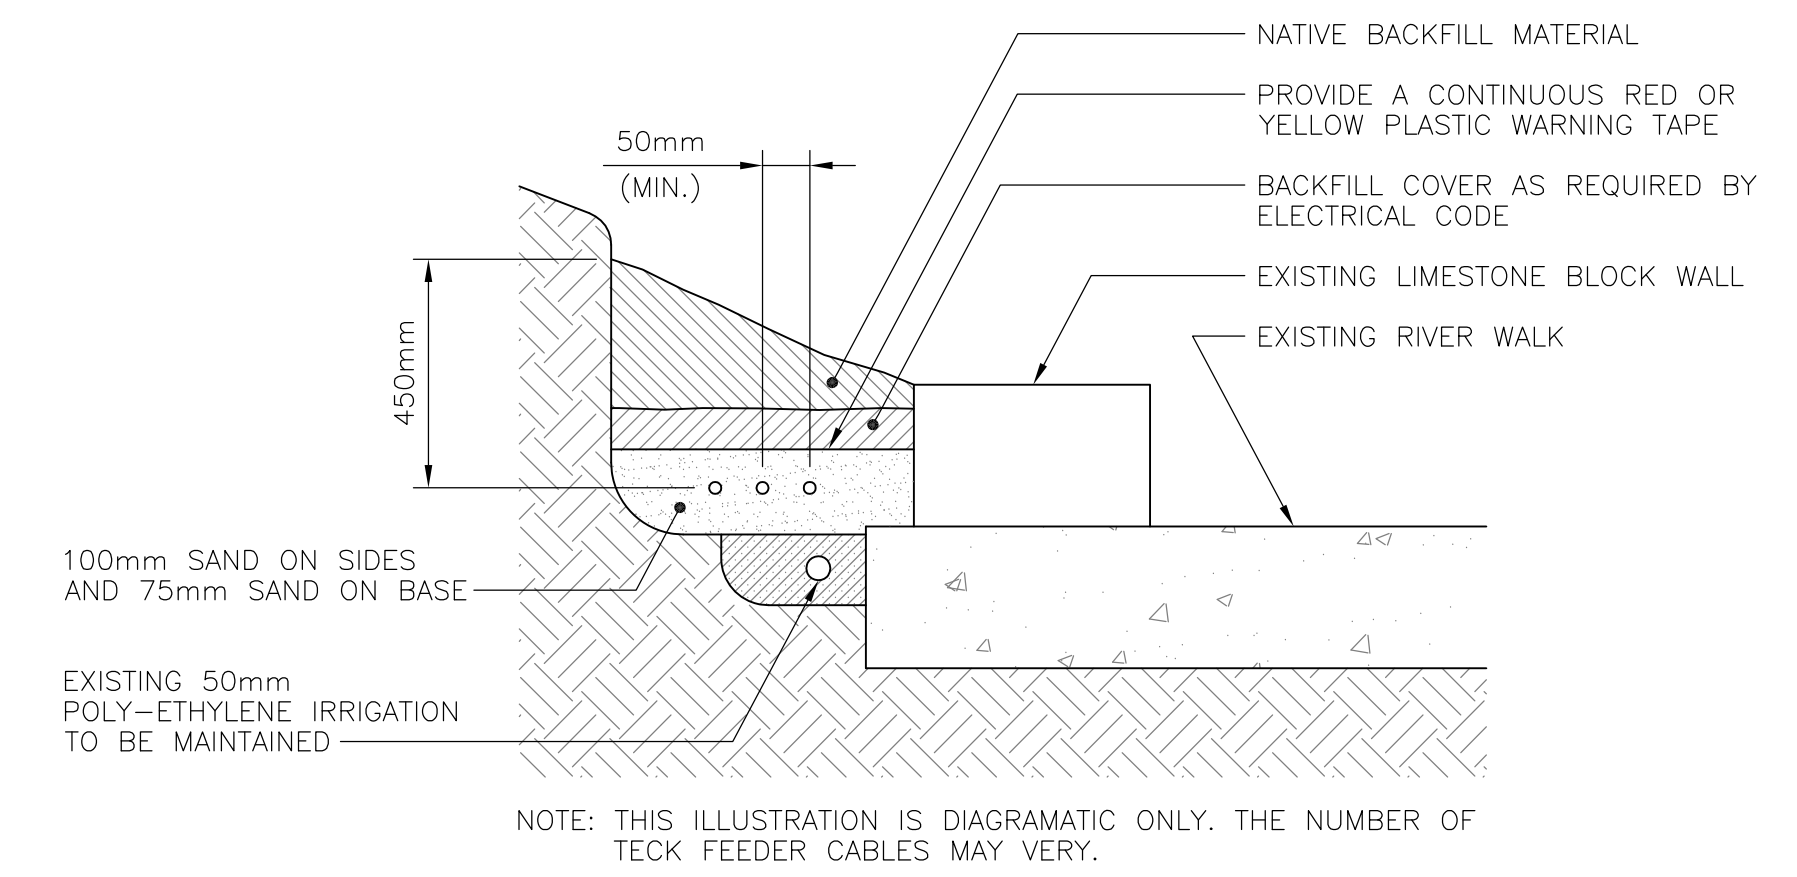

NOTE: THIS ILLUSTRATION IS DIAGRAMATIC ONLY. THE NUMBER OF TECK FEEDER CABLES MAY VARY.

TYPICAL TRENCH DETAIL

1 PARTIAL SITE PLAN - PHASE A
E03 SCALE = 1 : 600


NOTES

1. EXISTING PANEL TO REMAIN. CONTRACTOR TO RE-USE ALL BREAKERS AS REQUIRED TO RE-FEED THE EXISTING AND NEW LIGHT FIXTURES.
2. EXISTING STEP LIGHTS TO REMAIN. STEP LIGHTS FEED OUT OF PANEL A ON CIRCUIT BREAKER #4.
3. EXISTING DOCK LIGHT FIXTURE NO LONGER IN SERVICE. FIXTURES FEED OUT OF PANEL A ON CIRCUIT BREAKER #5. CONTRACTOR TO REMOVE CABLING AND MAKE SAFE. BREAKER TO BE MARKED SPARE.
4. EXISTING CABLING UNDER CONCRETE DOCK TO REMAIN.
5. PROVIDE A NEW WATERTIGHT JUNCTION BOX TO PICKUP EXISTING POWER CIRCUITS. EXTEND NEW FEEDERS TO PANEL A AS REQUIRED. JUNCTION BOX TO BE MOUNTED TO THE BACK OF LIMESTONE BLOCK WALL. EXACT LOCATION TO BE DETERMINED ON SITE WITH ENGINEER.
6. EXISTING CABLING FOR FOUNTAIN CONTROL PANEL TO REMAIN.
7. REFER TO CABLE SPECIFICATION FOR FEEDER DETAILS AND REQUIREMENTS.
8. REFER TO DRAWING E02 FOR JUNCTION BOX SPECIFICATION.
9. REFER TO THE TYPICAL TRENCH DETAIL FOR MINIMUM REQUIREMENTS.

FIXTURE SCHEDULE			
TYPE	DESCRIPTION	WATTAGE	APPROVED MANUFACTURERS
A	EXISTING LIGHT FIXTURES TO BE FIXED WITH A NEW TWIST LOCK CONNECTOR	1-70W MH	EXISTING
B	EXISTING FIXTURES NO LONGER IN SERVICE	1-70W MH	EXISTING
C	EXISTING LIGHT FIXTURES TO REMAIN WITH EXISTING WIRE CONNECTIONS.	1-70W	EXISTING

LEGEND

- U/G HYDRO CABLE
- NEW 120V FEEDER CABLES (NOTE 7)
- POLE MOUNTED LIGHTING FIXTURE
- ELECTRICAL PANEL
- JUNCTION BOX (NOTE 8)

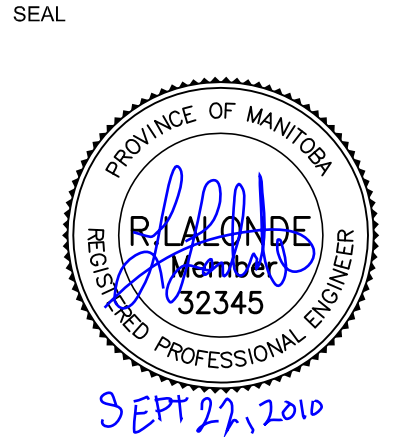

THE CITY OF WINNIPEG
 PLANNING PROPERTY AND DEVELOPMENT
SCATLIFF + MILLER + MURRAY Inc.
 TEL 204 927-3444
 FAX 204 927-3443
 8-136 MARKET AVENUE
 WINNIPEG, MB, CANADA

PROJECT		ASSINIBOINE RIVERWALK ELECTRICAL UPGRADES	
TITLE		PHASE A LIGHTING PLAN	
DESIGN	DRAWN	DATE - Y / M / D	SCALE
JLL	BGO	10/08/31	N.T.S.
CHECKED	APPROVED	PROJECT NO.	DRAWING NO.
BS	KA	0000	E03

REV	YY / MM / DD	DESCRIPTION	BY
0	10/09/22	ISSUED FOR BID OPPORTUNITY	