
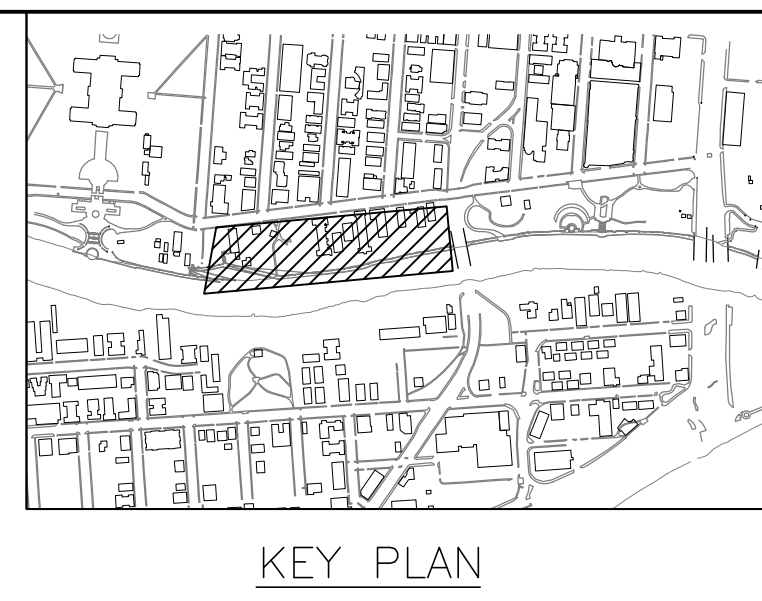


CAD File Name: 10-0109-10_e04-ep-01.dwg
 Date: 10/09/20
 Scale: 1:600
 Drawing No: E04

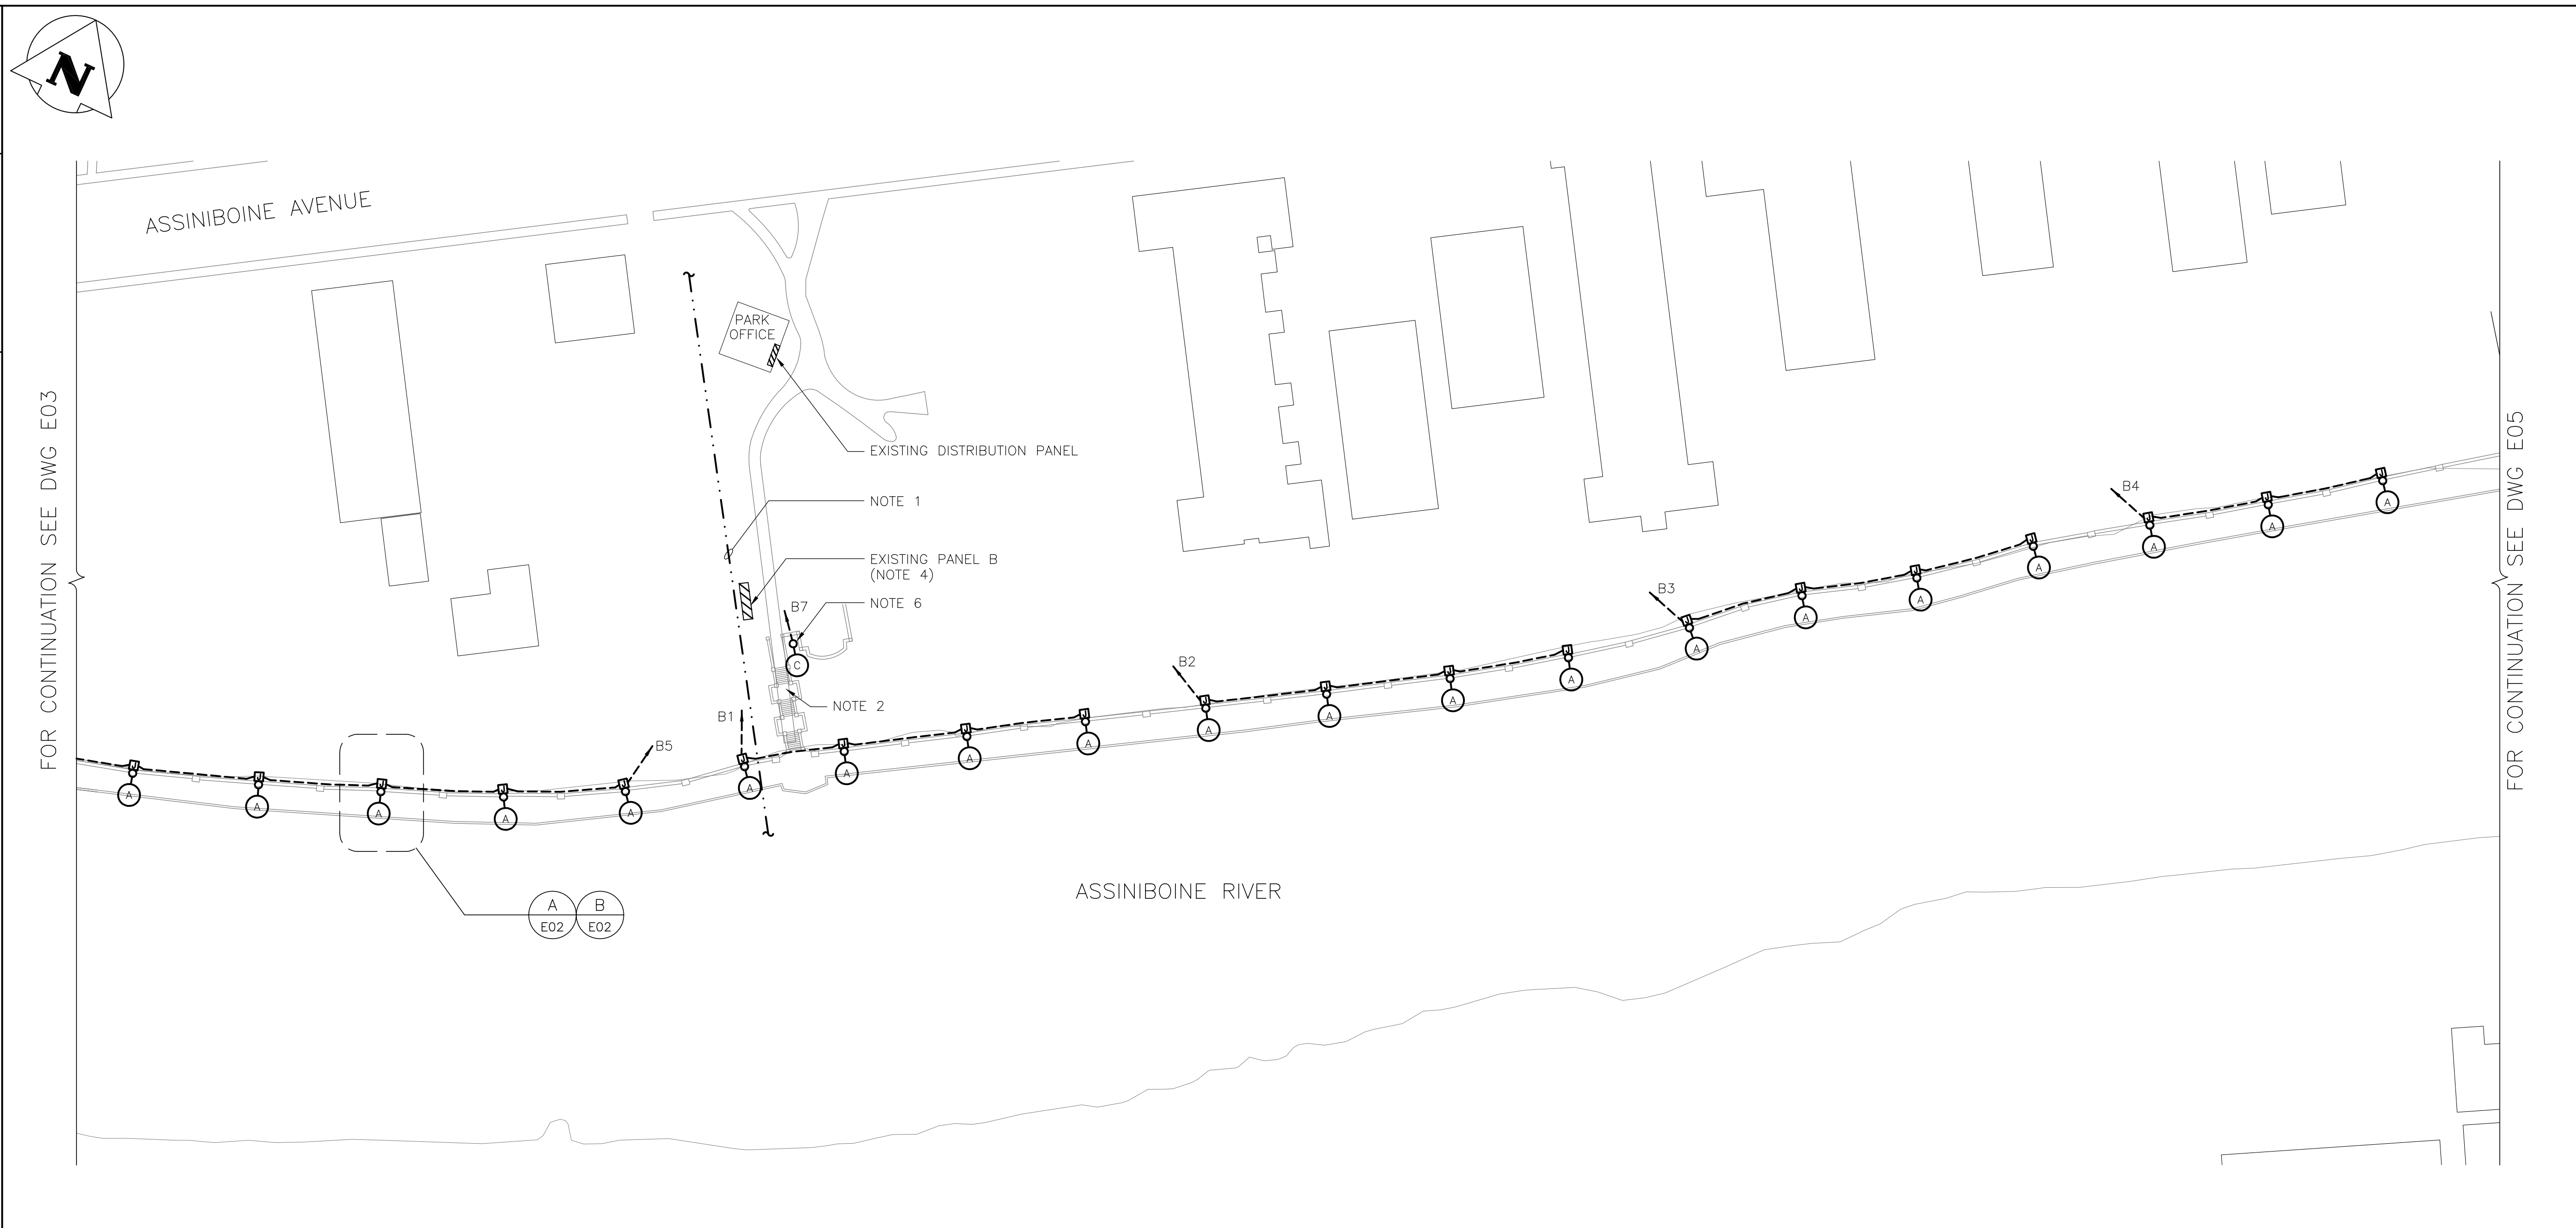

NOTES:

1. EXISTING HYDRO UNDERGROUND HIGH VOLTAGE CABLE SYSTEM. CONTRACTOR TO COORDINATE EXACT CABLE LOCATION ON SITE WITH MANITOBA HYDRO PRIOR TO ANY TRENCHING.
2. EXISTING STEP LIGHTS TO REMAIN. STEP LIGHTS FEED OUT OF PANEL 'B' ON CIRCUIT BREAKER #6.
3. REFER TO CABLE SPECIFICATION FOR FEEDER DETAILS AND REQUIREMENTS.
4. EXISTING PANEL TO REMAIN. CONTRACTOR TO RE-USE ALL BREAKERS AS REQUIRED TO RE-FEED THE EXISTING AND NEW LIGHT FIXTURES.
5. REFER TO DRAWING E02 FOR JUNCTION BOX SPECIFICATION.
6. EXISTING FEEDER CABLE TO REMAIN.
7. REFER TO THE TYPICAL TRENCH DETAIL FOR MINIMUM REQUIREMENTS.

1 PARTIAL SITE PLAN - PHASE B
E04 SCALE = 1 : 600

LEGEND

- U/G HYDRO CABLE
- NEW 120V FEEDER CABLES (NOTE 3)
- A POLE MOUNTED LIGHTING FIXTURE
- ▨ ELECTRICAL PANEL
- JUNCTION BOX (NOTE 5)



THE CITY OF WINNIPEG
 PLANNING PROPERTY AND DEVELOPMENT
SCATLIFF + MILLER + MURRAY Inc.
 TEL 204 927-3444 8-136 MARKET AVENUE
 FAX 204 927-3443 WINNIPEG, MB, CANADA

PROJECT		ASSINIBOINE RIVERWALK ELECTRICAL UPGRADES	
TITLE		PHASE B LIGHTING PLAN	
DESIGN	DRAWN	DATE - Y / M / D	SCALE
JLL	BGO	10/08/31	N.T.S.
CHECKED	APPROVED	PROJECT NO.	DRAWING NO.
JS	JA	0000	E04

REV	YY / MM / DD	DESCRIPTION	BY
0	10/09/22	ISSUED FOR BID OPPORTUNITY	JS

NOTES:

A. SECTION LETTER OR DETAIL NUMBER.
 B. DRAWING WHERE SECTION OR DETAIL IS DRAWN.
 OR
 DRAWING WHERE SECTION OR DETAIL IS INDICATED.
 --- SECTION OR DETAIL SHOWN ON SAME DRAWING.