


INSTALLATION NOTES:

- ① MOUNT XFMR-L10 ON THE WALL AT A HIGH LEVEL. INSTALL NON-COMBUSTIBLE INSULATING BOARD, EXTENDING 300mm AROUND TRANSFORMER ON ALL SIDES, BEHIND TRANSFORMER TO MEET CEC CODE REQUIREMENTS.
- ② PROVIDE HOUSEKEEPING PAD, 89mm HIGH, EXTEND 50mm ON EACH SIDE OF THE EQUIPMENT, WITH 19mm CHAMFERED EDGES. PROVIDE REINFORCEMENT AND ANCHOR PAD TO THE FLOOR SLAB.

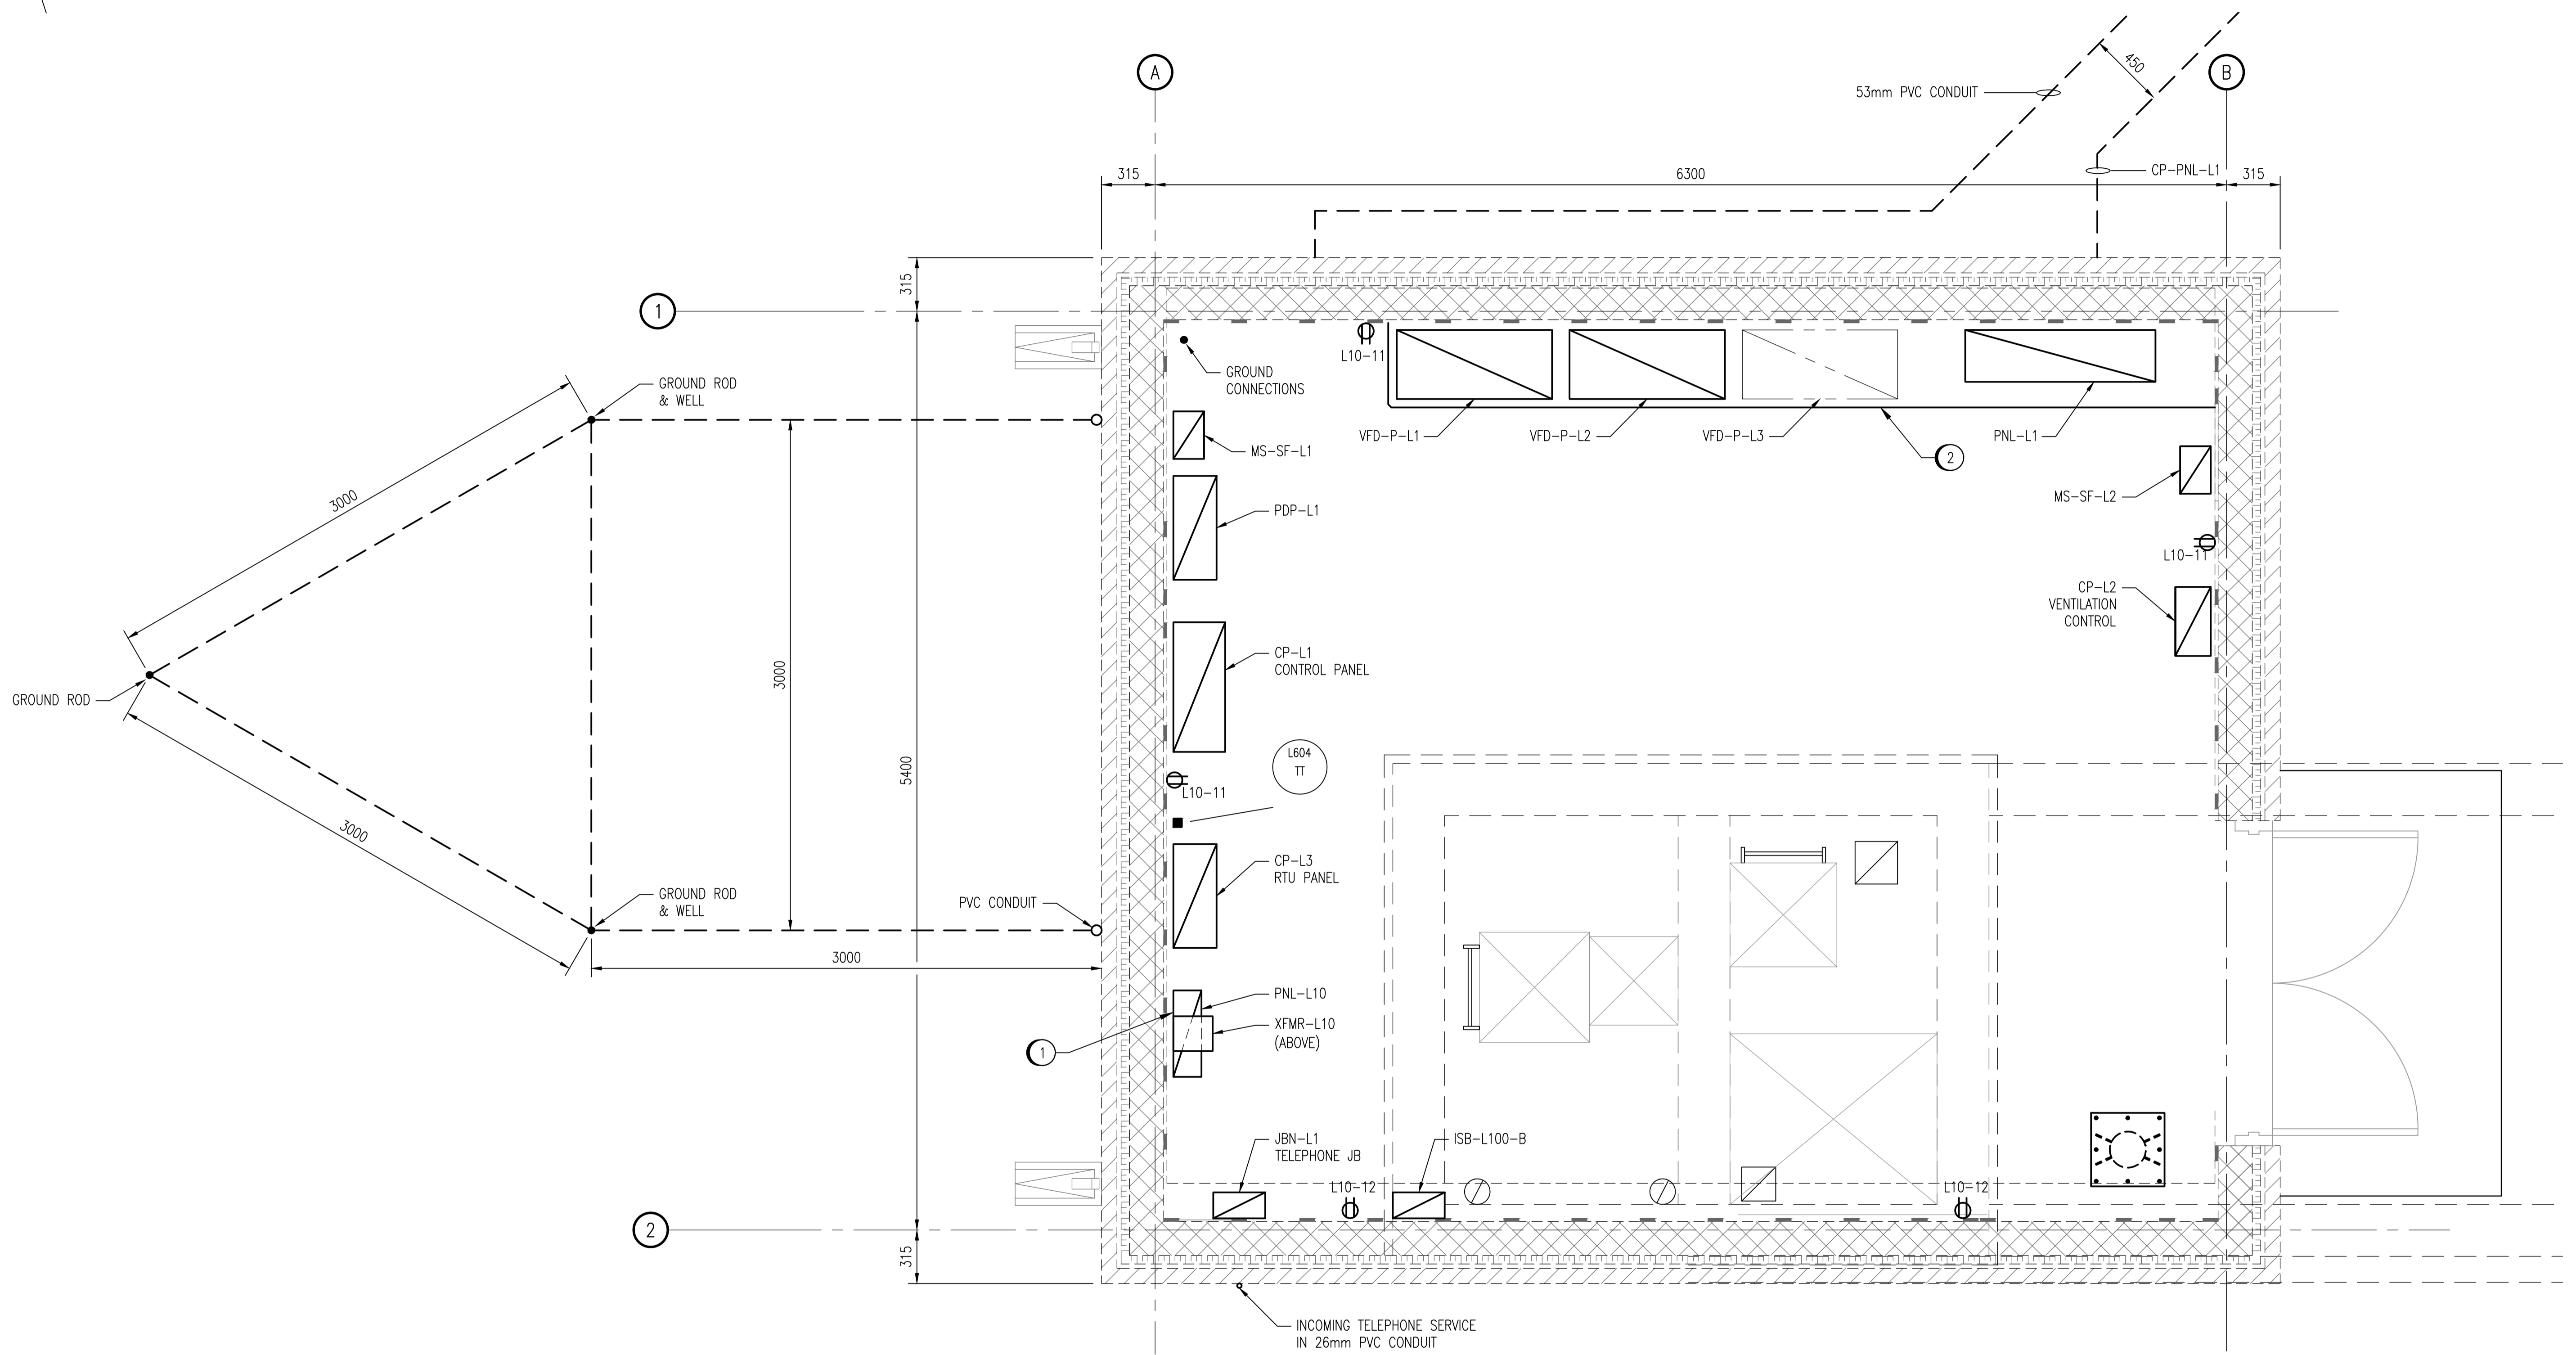

MAIN FLOOR PLAN
SCALE: 1 : 20

LAST SAVE: 2010/10/04 - 1:26pm
PATH: M:\113368\GEN\47ELE\DD - General DWG\1-0159L-E0004-001-00.dwg

| | |
|----------------|----------------------|
| 1-0159L-E0017 | GROUNDING DETAILS |
| 1-0159L-E0008 | ELECTRICAL SCHEDULES |
| DRAWING NUMBER | REFERENCE DRAWINGS |



| NO. | REVISIONS | DATE | DESIGN | CHECK |
|-----|-------------------|------------|--------|-------|
| 00 | ISSUED FOR TENDER | 2010/09/29 | BC | CJR |

| | |
|---|--|
| <p>SNC-LAVALIN INC. 148 Nature Park Way Winnipeg, MB, Canada R3P 0X7 204-786-8080</p> | |
| DESIGNED BY: B. CLEVEN | CHECKED BY: C. REIMER |
| DRAWN BY: S. COATES | APPROVED BY: C. REIMER |
| SCALE: 1:20 | RELEASED FOR CONSTRUCTION BY: K. ZUREK |
| DATE: 2010/06/30 | DATE: 2010/10/04 |
| CONSULTANT NO.: 113368-0000-47DD-0004 | |

| |
|--|
| ENGINEER'S SEAL |
| ORIGINAL DRAWING SEALED BY: C. REIMER SNC-LAVALIN INC. 2010/10/02 REV. 00 |
| BID OPP.: 760-2010 |

| | |
|--|-----------------|
| <p>THE CITY OF WINNIPEG WATER AND WASTE DEPARTMENT</p> | |
| <p>MARION WASTEWATER PUMPING STATION INSTALLATION OF PUMPING UNITS & BUILDING UPGRADES ELECTRICAL PLAN LAYOUT MAIN FLOOR</p> | |
| CITY DRAWING NUMBER | SHEET REV. SIZE |
| 1-0159L-E0004 | 001 00 A1 |