




PUMP ROOM UNDER MEZZANINE – LIGHTING PLAN
SCALE: 1:100

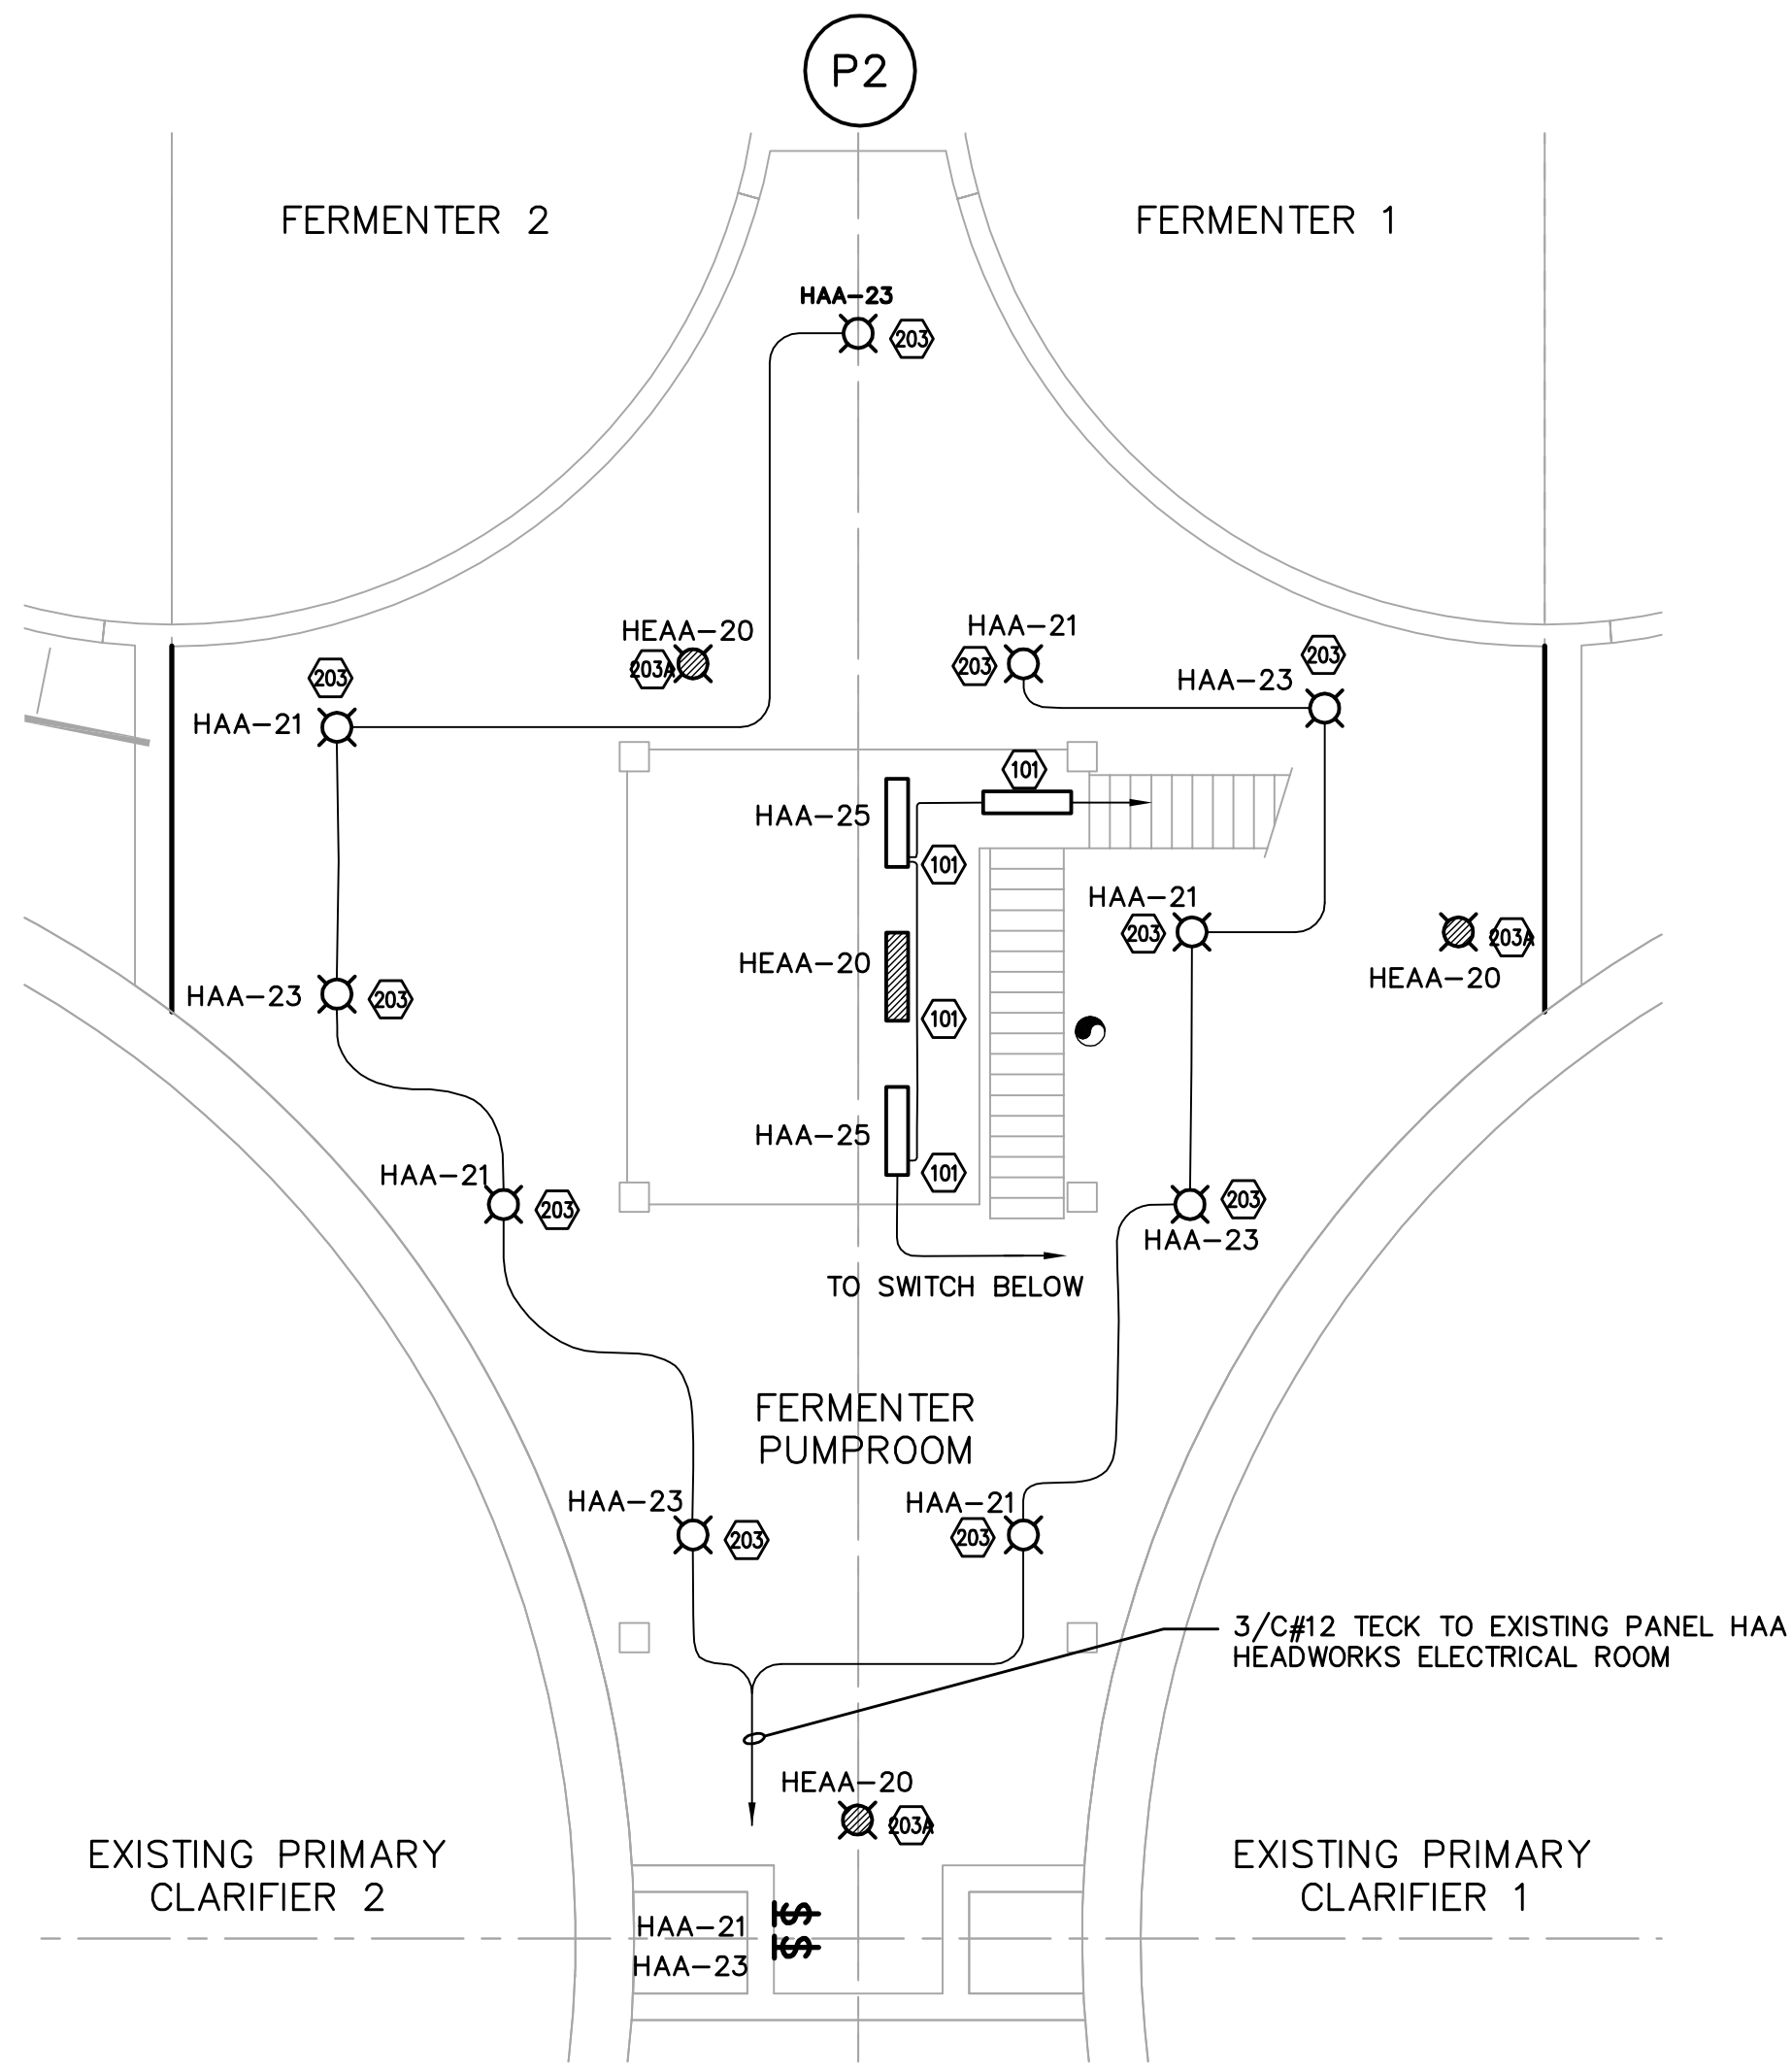

FERMENTER PUMP ROOM – LIGHTING PLAN
SCALE: 1:100

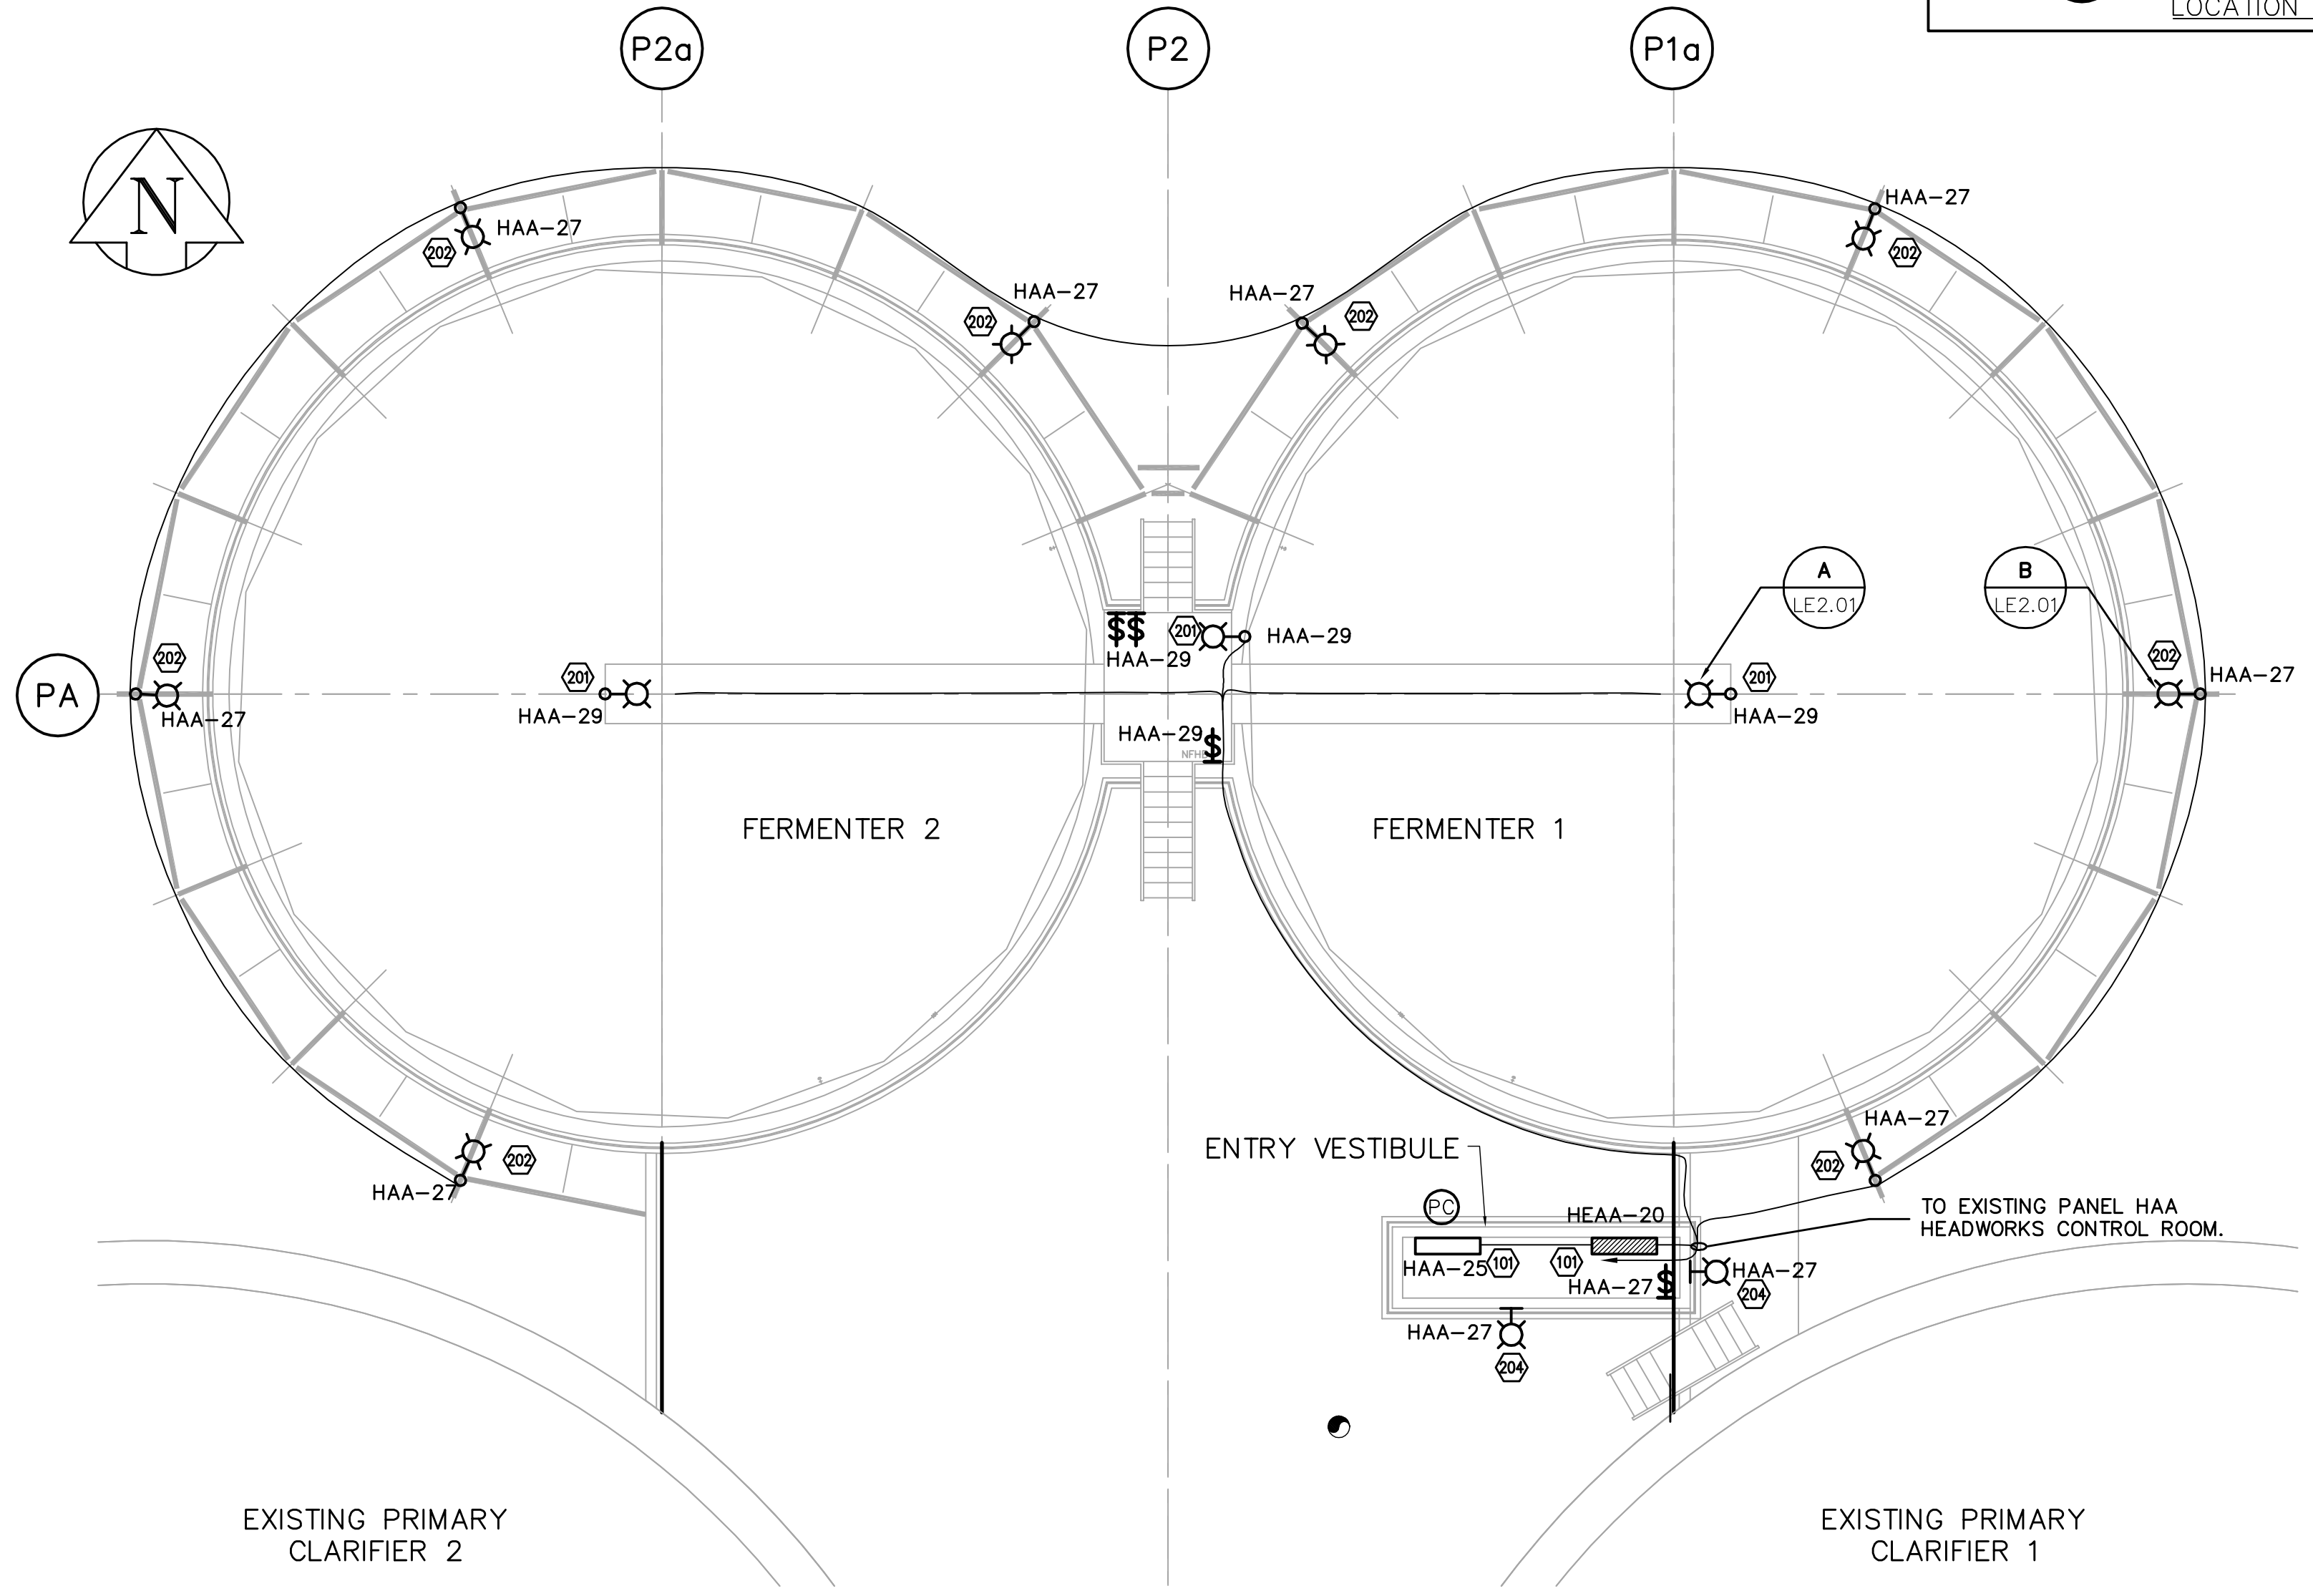

FERMENTER ROOF – LIGHTING PLAN
SCALE: 1:100

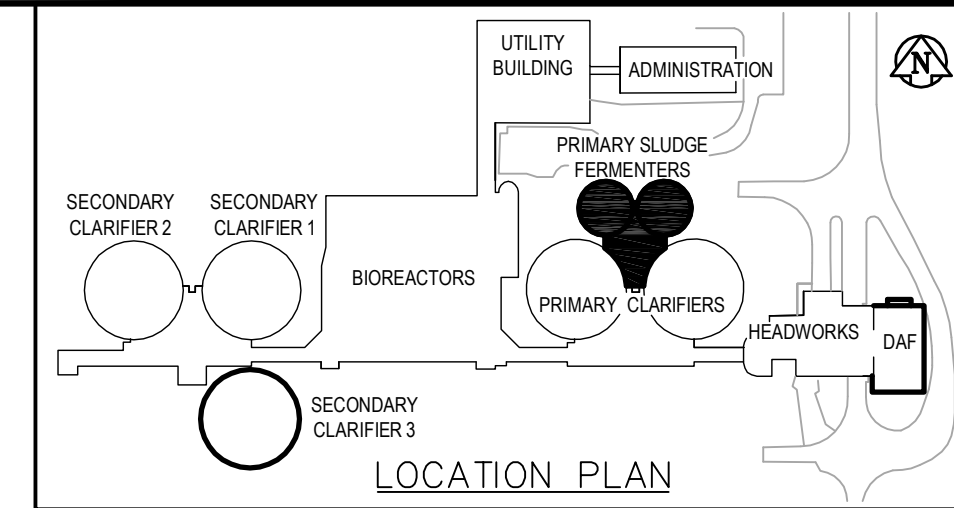

DRAWING NOTES

- ① COORDINATE LUMINAIRE CONNECTIONS WITH MECHANICAL PIPING AND DUCTWORK. WHERE REQUIRED SUSPEND LUMINAIRES BELOW SUCH EQUIPMENT.

GENERAL NOTES

- 1. COORDINATE WITH OTHER TRADES TO PREVENT CONFLICTS.
- 2. USE PVC JACKETED HITECK CABLE FOR ALL POWER WIRING.
- 3. WIRING FOR LIGHTING, RECEPTACLES AND COMMUNICATIONS TO IN RIGID ALUMINUM CONDUIT.
- 4. ALL CONDUIT TO BE 21mmØ MINIMUM UNLESS OTHERWISE NOTED.



B.M. ELEV.	EarthTech A Tyco International Ltd. Company		ENGINEER'S SEAL
	DESIGNED BY: GSN	CHECKED BY: PS	ORIGINAL SIGNED BY: P. STRYK
	DRAWN BY: ERC	APPROVED BY: JEH	2006/04/26
02 ISSUED FOR CONSTRUCTION 06/09/22 SRP	HOR. SCALE: AS NOTED		CONSULTANT DRAWING NO. FE1.01
01 21-2006 ADDENDUM 3 06/05/19 ERC	RELEASED FOR CONSTRUCTION BY: J. VEILLEUX		
00 ISSUED FOR TENDER 06/04/26 ERC	DATE: 2005/11/22	DATE: 2006/04/26	
NO. REVISIONS	DATE	BY	

THE CITY OF WINNIPEG
WATER AND WASTE DEPARTMENT
ENGINEERING DIVISION

WEWPC
BIOLOGICAL NUTRIENT REMOVAL UPGRADE
CONTRACT 3

ELECTRICAL
AREA F- PRIMARY SLUDGE FERMENTERS
LIGHTING AND SYSTEMS PLANS

CITY FILE NUMBER
SHEET OF
CITY DRAWING NUMBER