



2 MEZZANINE FLOOR PLAN
SCALE 1:100

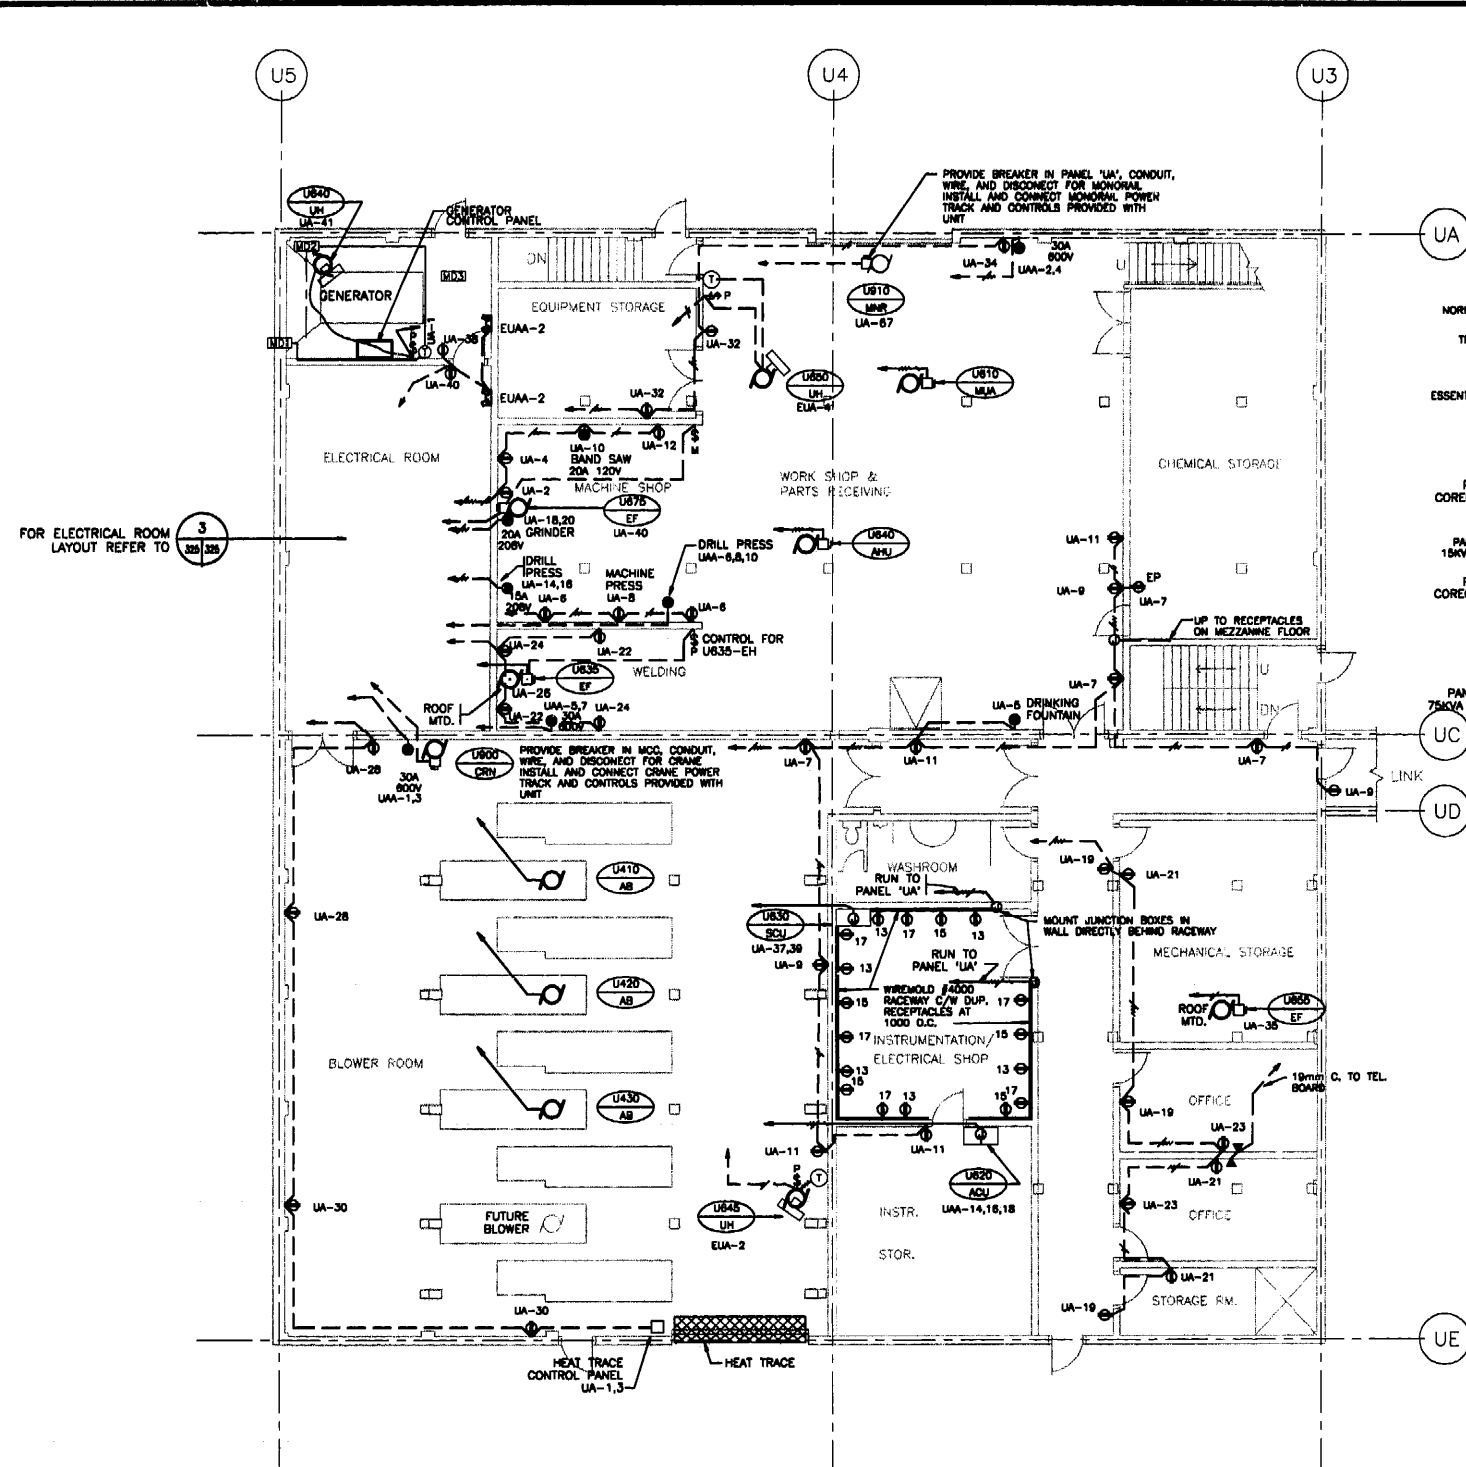

1 MAIN FLOOR PLAN
SCALE 1:100

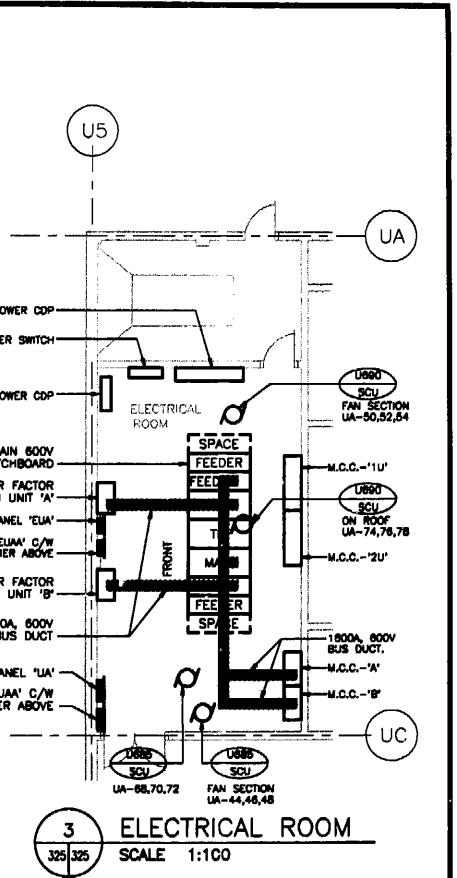

3 ELECTRICAL ROOM
SCALE 1:100

THE ENGINEER THAT SEALED THIS DRAWING IS RESPONSIBLE FOR ONLY THE AS-CONSTRUCTED CHANGES ON THIS DRAWING. THE ORIGINAL DESIGN WAS THE RESPONSIBILITY OF THE DESIGN ENGINEER WHO SEALED THE ISSUED FOR TENDER DRAWINGS IN 1991.

REID, CROWTHER & PARTNERS LIMITED
WINNIPEG
AS CONSTRUCTED
BIG... DATE... 21/11

detail symbol
A detail number
B drawing where detail shown
C cross reference to drawing where detail taken



B.M. 89-006	ELEV. 237.626 m
DESIGNED BY	LT
CHECKED BY	DJS
DRAWN BY	EJS
APPROVED BY	
HOR. SCALE:	100
VERTICAL:	
1 AS BUILT	93/11 DE
0 ISSUED FOR TENDER	
NO. REVISIONS	DATE BY
	DATE 91-06-06

Reid Crowther



THE CITY OF WINNIPEG
WORKS AND OPERATIONS DIVISION
WATERWORKS WASTE AND DISPOSAL DEPT.

WEST END WATER POLLUTION CONTROL CENTRE
AREA U - UTILITY/BLOWER BUILDING

CITY DRAWING NUMBER
SHEET OF
WEP-325

UTILITY MAIN AND MEZZ. FLOOR PLANS
ELECTRICAL POWER LAYOUT

CONSULTANT DRAWING NO.
60910 - UE5

File # WS10379