


DRAWING NUMBER DESIGNATION

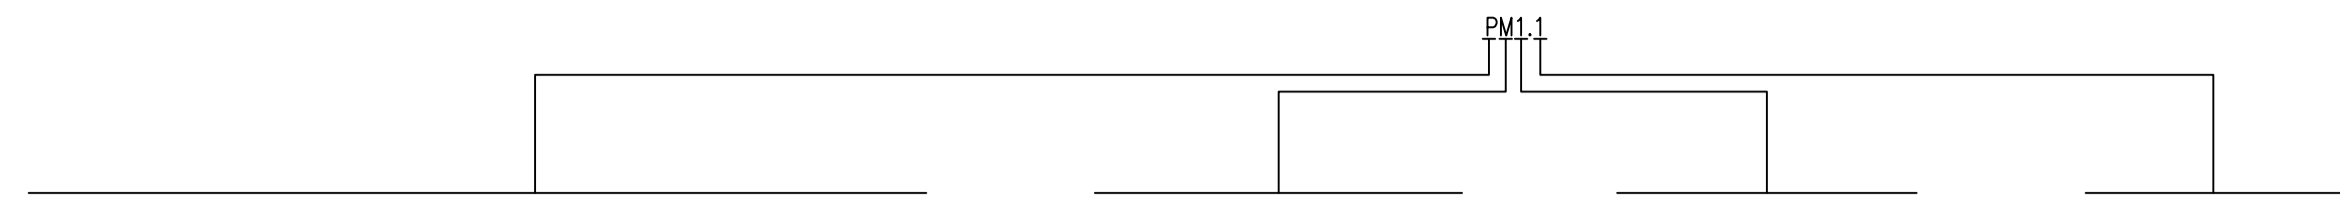

AREA:

L: GENERAL
P: PRIMARY CLARIFIERS
S: SECONDARY CLARIFIERS; S1 EXISTING CONDITIONS, S2 NEW CONDITIONS
S: ODOUR DISPERSION FAN ROOM, S3 EXISTING CONDITIONS, S4 NEW CONDITIONS
H: HEADWORKS
U: UTILITIES - TUNNELS, U1 EXISTING CONDITIONS, U2 NEW CONDITIONS
U: UTILITIES - ADMINISTRATION BUILDING, U3 EXISTING CONDITIONS, U4 NEW CONDITIONS
U: UTILITIES - MECHANICAL BAY, U5 EXISTING CONDITIONS, U6 NEW CONDITIONS

DIVISION:

G: GENERAL LEGENDS
L: DETAILS
P: PROCESS
M: MECHANICAL
S: STRUCTURAL
I: INSTRUMENTATION
E: ELECTRICAL

CONDITION:

ODD: EXISTING
EVEN: NEW

SEQUENCE OF DRAWINGS

AREA L - GENERAL

Table with columns: CITY FILE No., DRAWING No., DRAWING TITLE. Lists drawing details for Area L including drawing lists and structural details.

AREA S - SECONDARY CLARIFIERS 1 & 2

Table with columns: CITY FILE No., DRAWING No., DRAWING TITLE. Lists drawing details for Area S including secondary clarifiers and pump rooms.

AREA H - HEADWORKS

Table with columns: CITY FILE No., DRAWING No., DRAWING TITLE. Lists drawing details for Area H including mechanical room roof plans and ventilation systems.

AREA P - PRIMARY CLARIFIERS 1 & 2

Table with columns: CITY FILE No., DRAWING No., DRAWING TITLE. Lists drawing details for Area P including primary clarifiers and pump rooms.

AREA S - ODOUR DISPERSION FAN ROOM

Table with columns: CITY FILE No., DRAWING No., DRAWING TITLE. Lists drawing details for the Odour Dispersion Fan Room including maintenance platforms and electrical plans.

Contractor information block including Alliance Engineering Services Inc. logo, project name '2010 HVAC REPLACEMENT AND ASSOCIATED WORKS', and drawing number '1-0103A-P0007-001'.