


EXISTING MECHANICAL ROOF PLAN (EL. 252.100)

SCALE: 1:100


- \* - DESIGNATES EXISTING PART OF STRUCTURE TO BE REMOVED OR MODIFIED. FOR DETAILS SEE DRAWING 'HS2.2'.
- FOR MODIFIED ROOF PLAN SEE THIS DWG.

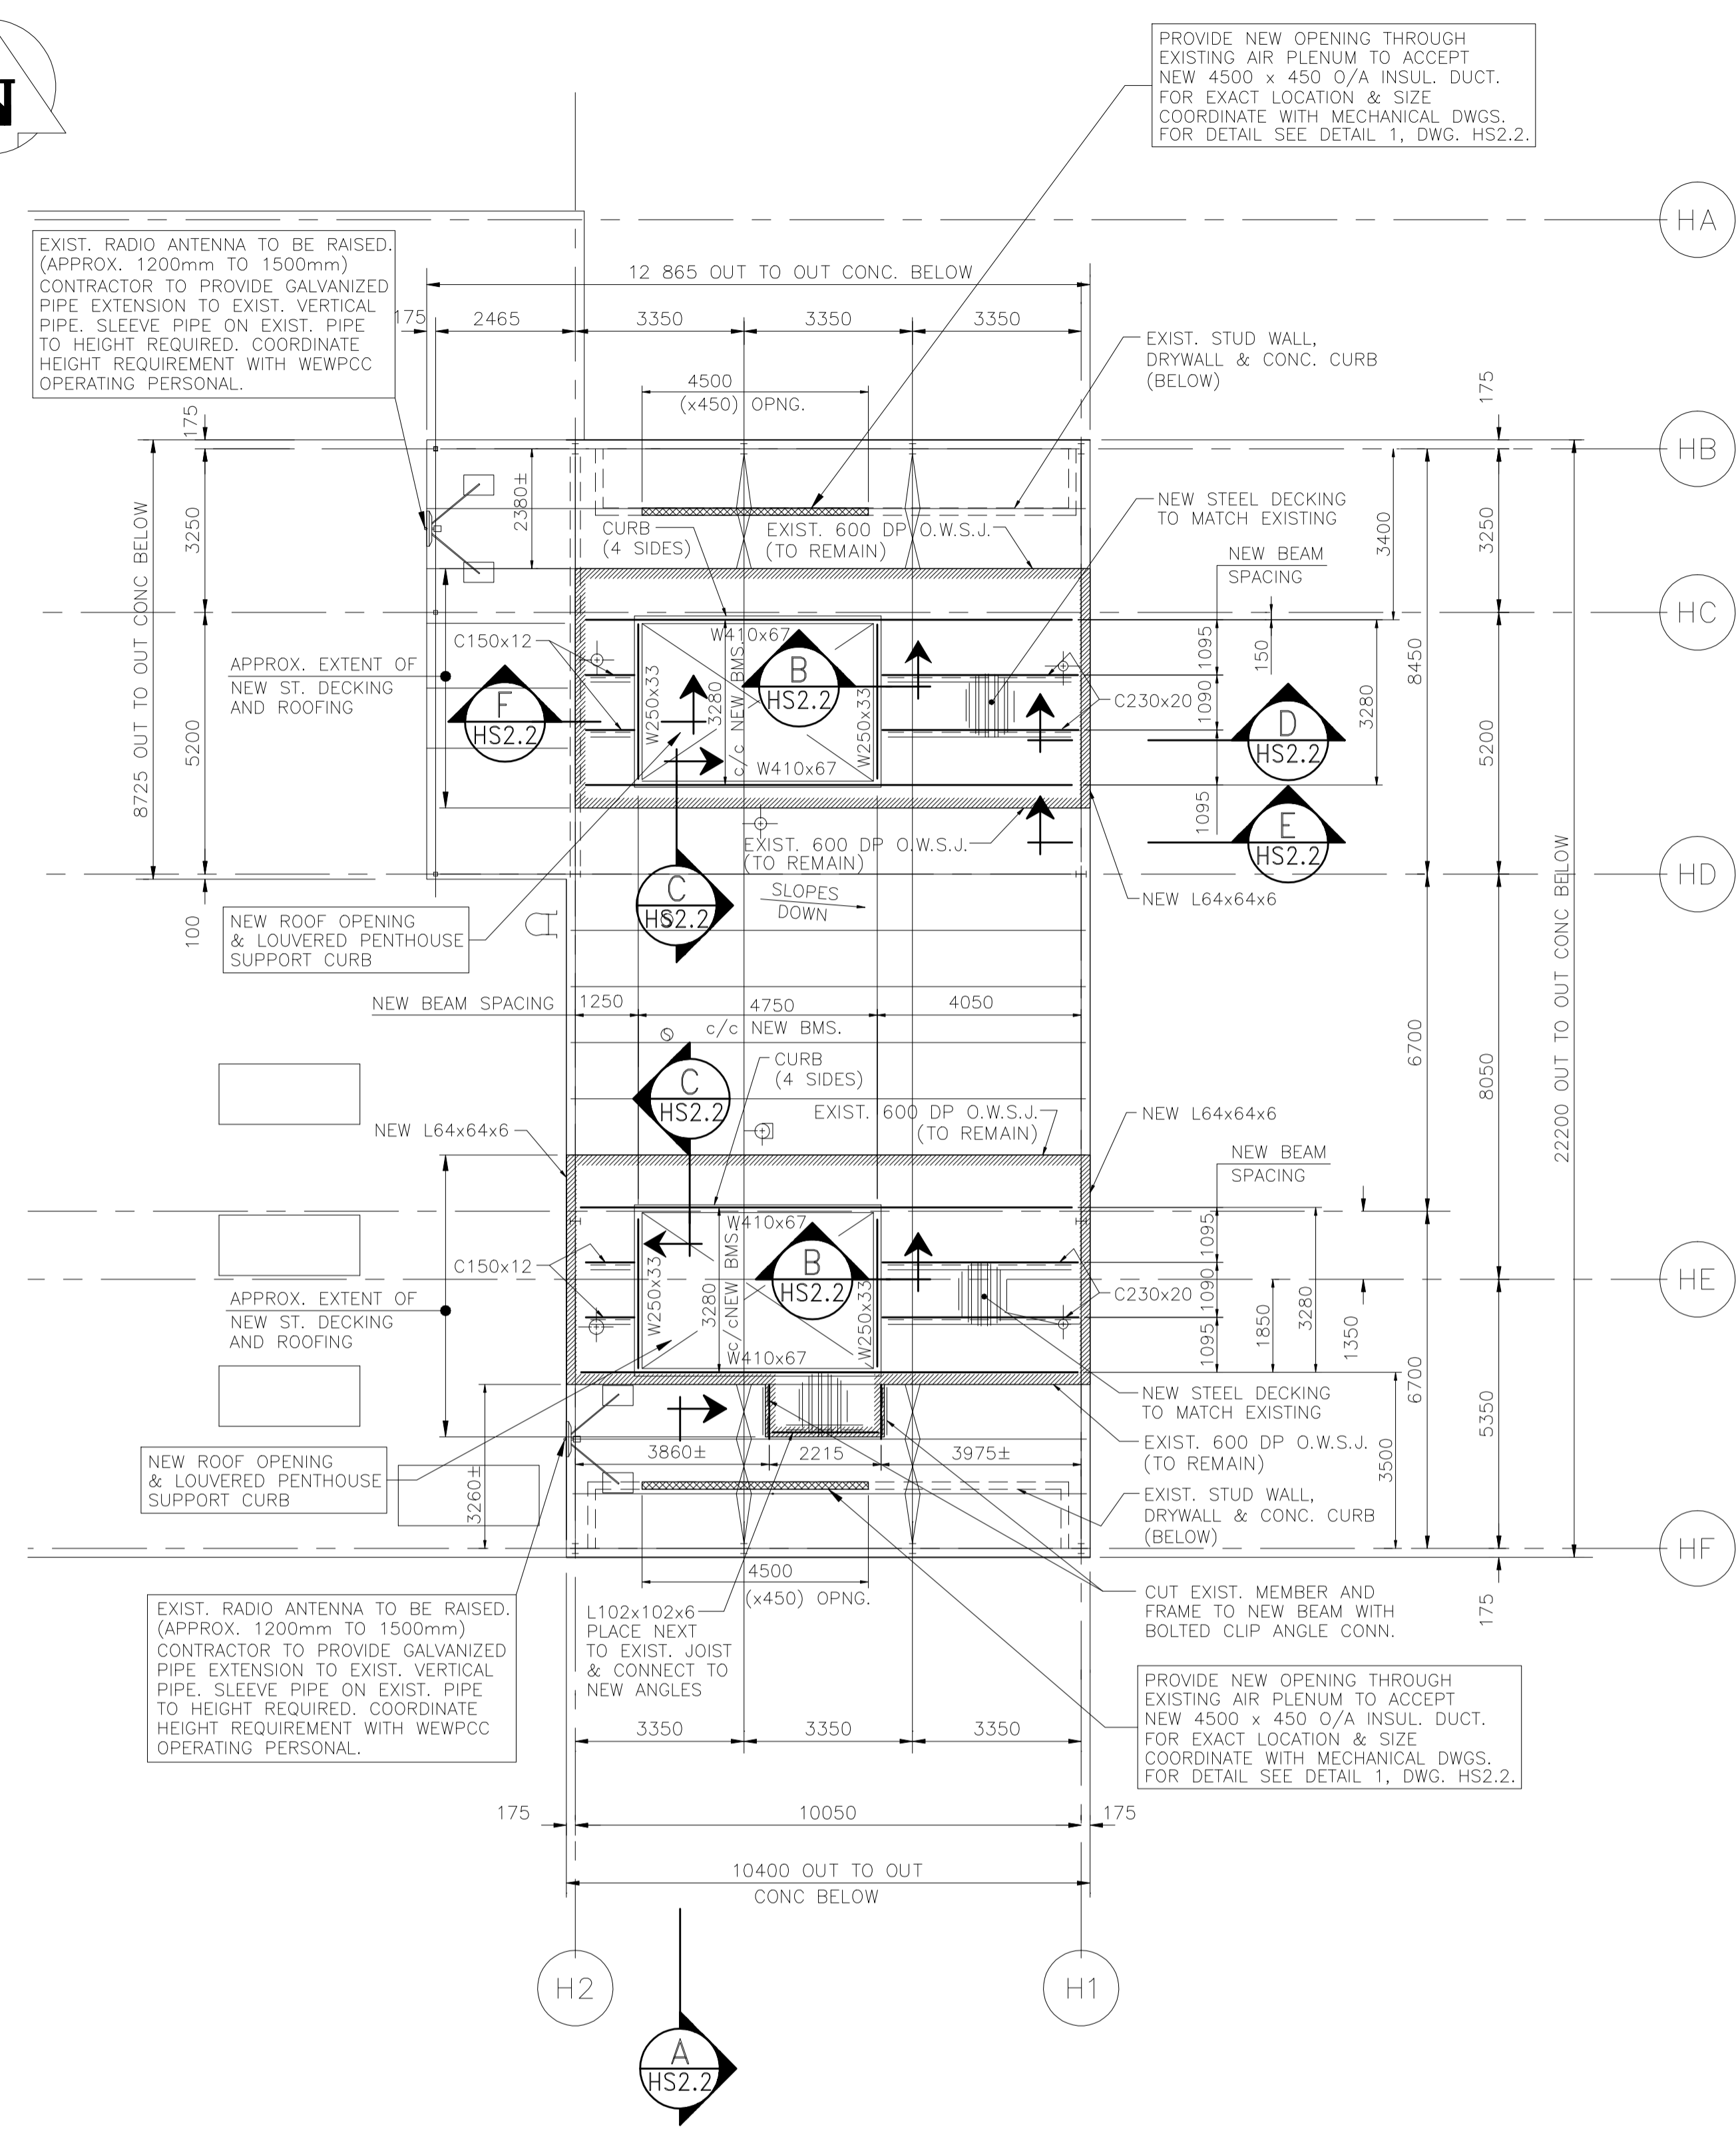


MODIFIED MECHANICAL ROOF PLAN (EL. 252.100)

SCALE: 1:100

(SHOWING NEW BEAM SIZES AND DIMENSIONS)

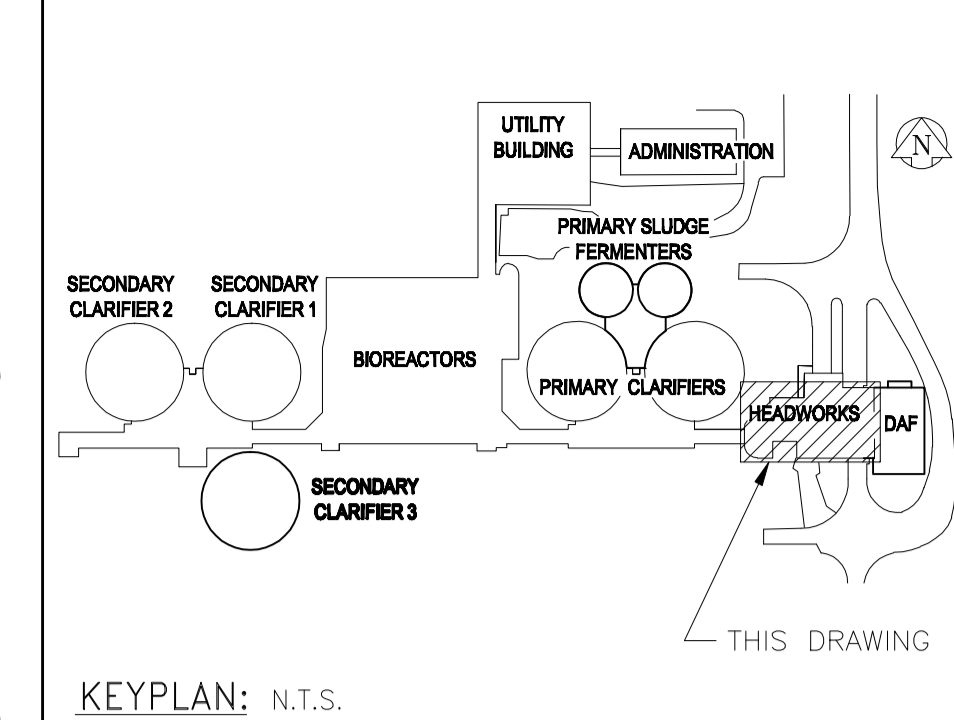

SEE DWG. LS2.1 FOR GENERAL NOTES

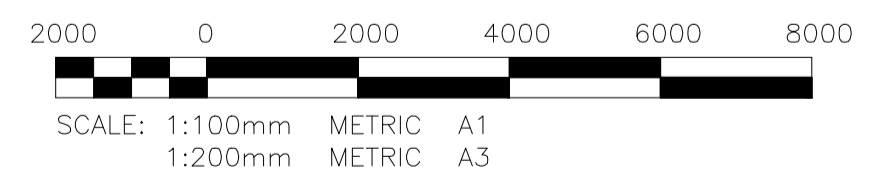

**APEGN**  
Certificate of Authorization  
KGS Group  
No. 245 Date: 10/12/21

**KGS GROUP**  
CONSULTING ENGINEERS

B.M. ELEV.	FIELD BOOK #:
POSTED TO LIS	
ISSUED FOR TENDER	2010-12-21 R.J.L.
NO. REVISIONS	DATE BY

**ALLIANCE**  
Engineering Services Inc.

DESIGNED BY: R.J.L.	CHECKED BY: R.J.L.
DRAWN BY: MBB	APPROVED BY:
HOR. SCALE AS NOTED	RELEASED FOR CONSTRUCTION
VERTICAL AS NOTED	DATE: 2010-07-22

ENGINEER'S SEAL  
PROVINCE OF MANITOBA  
REGISTERED PROFESSIONAL ENGINEER  
**R.J. LONG**  
CONSULTANT DRAWING NO.  
HS2.1

**THE CITY OF WINNIPEG**  
WATER AND WASTE DEPARTMENT

2010 HVAC REPLACEMENT AND ASSOCIATED WORKS  
**WEWPC**  
AREA H - HEADWORKS  
MECHANICAL ROOM ROOF PLAN

SHEET 1 OF 1  
CITY DRAWING NUMBER  
1-01036-S0001-001