


File Name: P:\Projects\2009\09-0754-08\DocControl\ToBeIssued\DWG\ELECTRICAL\1-0103A-E0008-001-Rev 00.dwg - Tab: 1-0103A-E0008-001-Rev 00.dwg - Tab: 1-0103A-E0008-001-Rev 00.dwg [Thu 5:25pm]


CW-9-M564-1

NOTES:

1. -

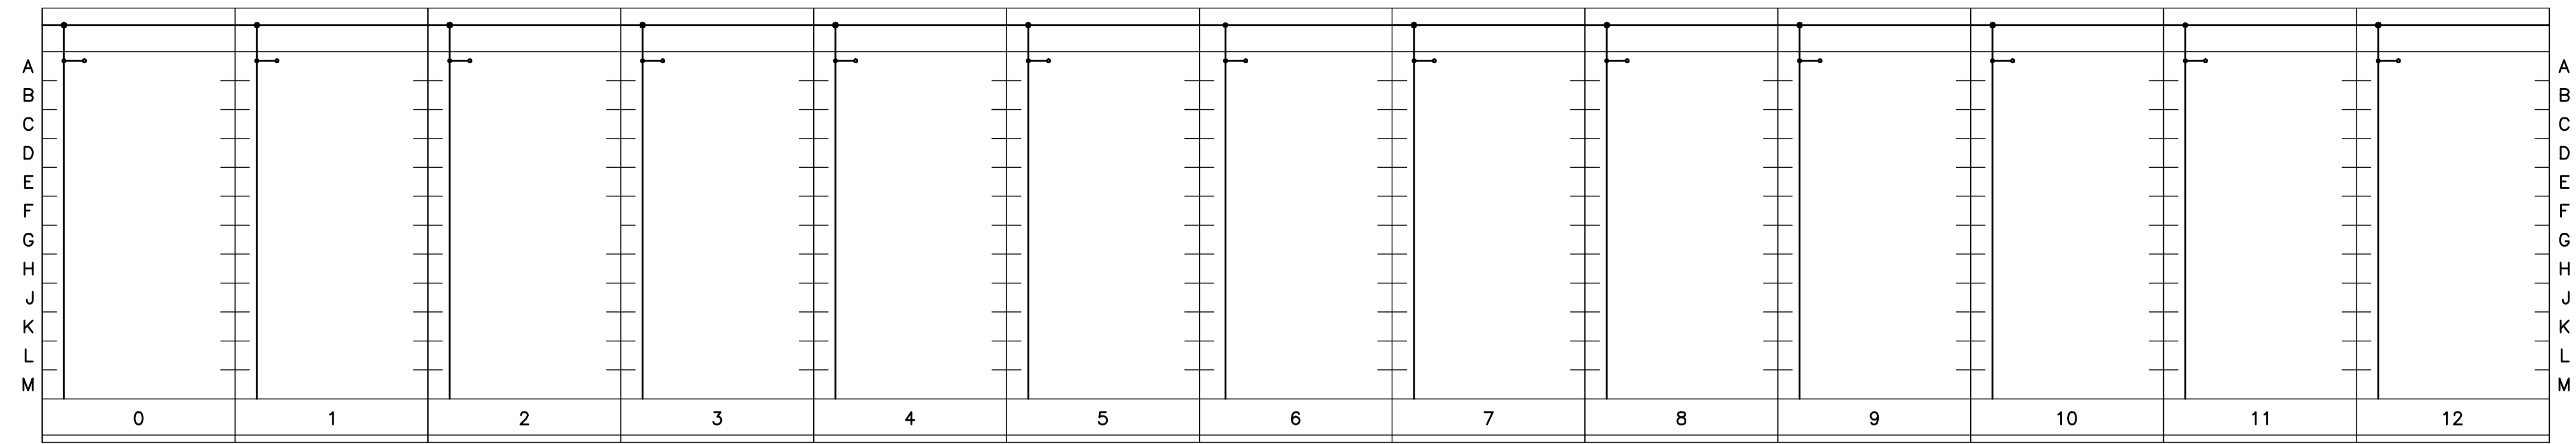

1 MCC-A ELEVATION
SCALE: N.T.S.

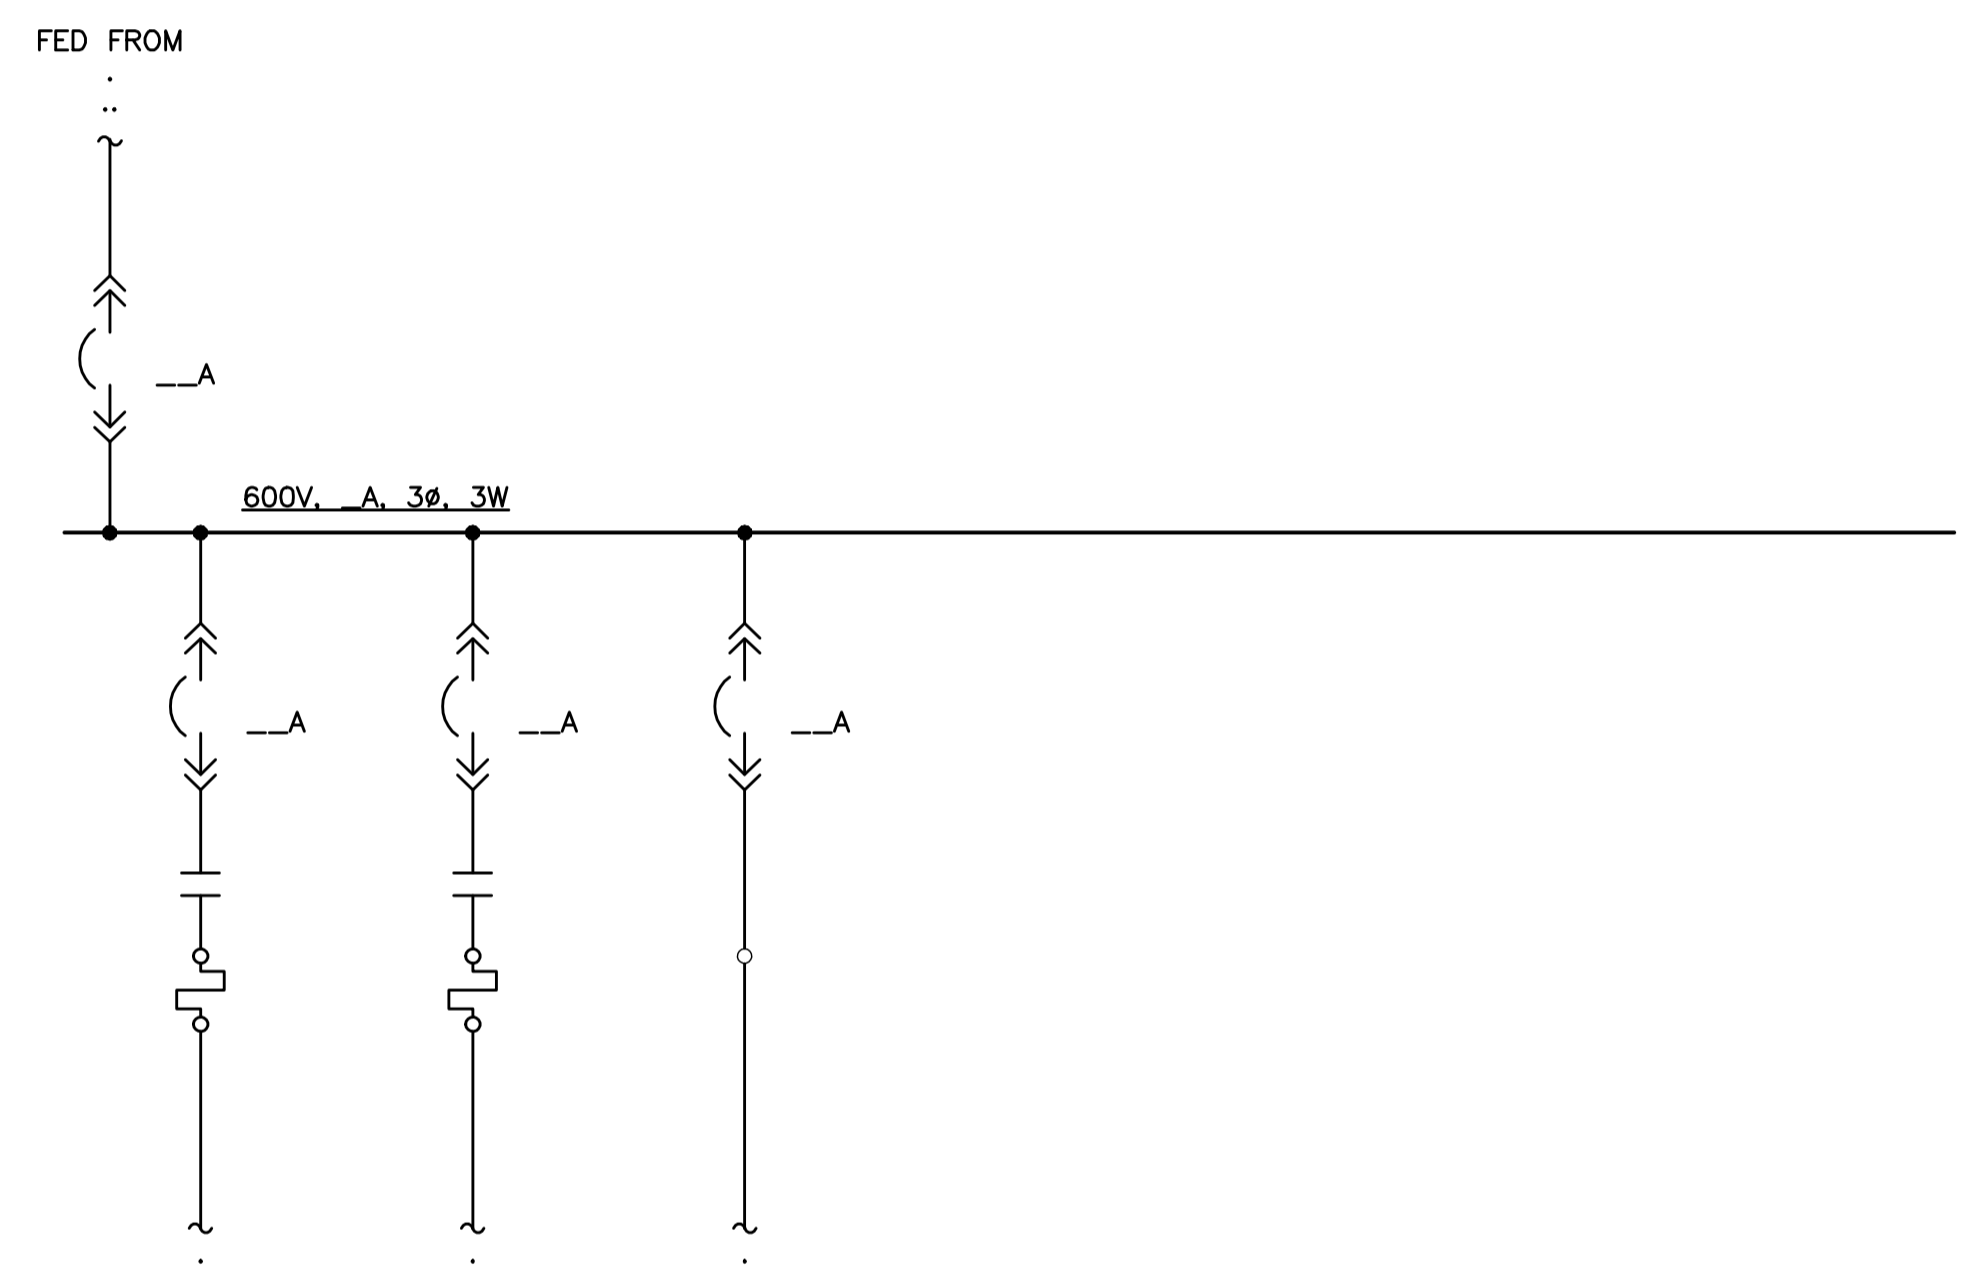

2 SINGLE LINE DIAGRAM
SCALE: N.T.S.

DRAWING RESERVED FOR
FUTURE USE
NOT RELEVANT FOR PROJECT

 Certificate of Authorization KGS Group No. 245 Date: 2010/12/21		B.M. ELEV. : POSTED TO LBIS	FIELD BOOK #: NO. REVISIONS DATE BY	 DESIGNED BY: REW/AP CHECKED BY: REW DRAWN BY: GCN APPROVED BY: REW HDR. SCALE: N.T.S. VERTICAL: N.T.S. 00 ISSUED FOR TENDER 2010-12-21 REW 2009 09 29	ENGINEER'S SEAL TENDER No. LE22 FILENAME: 1-0103A-E0008-001-Rev 00.dwg PLOT DATE: 2010/12/16	 2010 HVAC REPLACEMENT AND ASSOCIATED WORKS WEWPCC MCC-A SINGLE LINE DIAGRAM AND PHYSICAL LINE UP	SHEET 1 OF 1 CITY DRAWING NUMBER 1-0103A-E0008-001
---	--	--------------------------------	---	--	---	---	--