


File Name: P:\Projects\2009\09-0754-08\DocControl\ToBeIssued\DWG\ELECTRICAL\1-0103A-E0009-001-Rev 00.dwg - Tab: 1-0103A-E0009-001-Rev 00.dwg - Tab: 1-0103A-E0009-001-Rev 00.dwg [Thu 5:24pm]


CW-9-M564-1

NOTES:

1. -

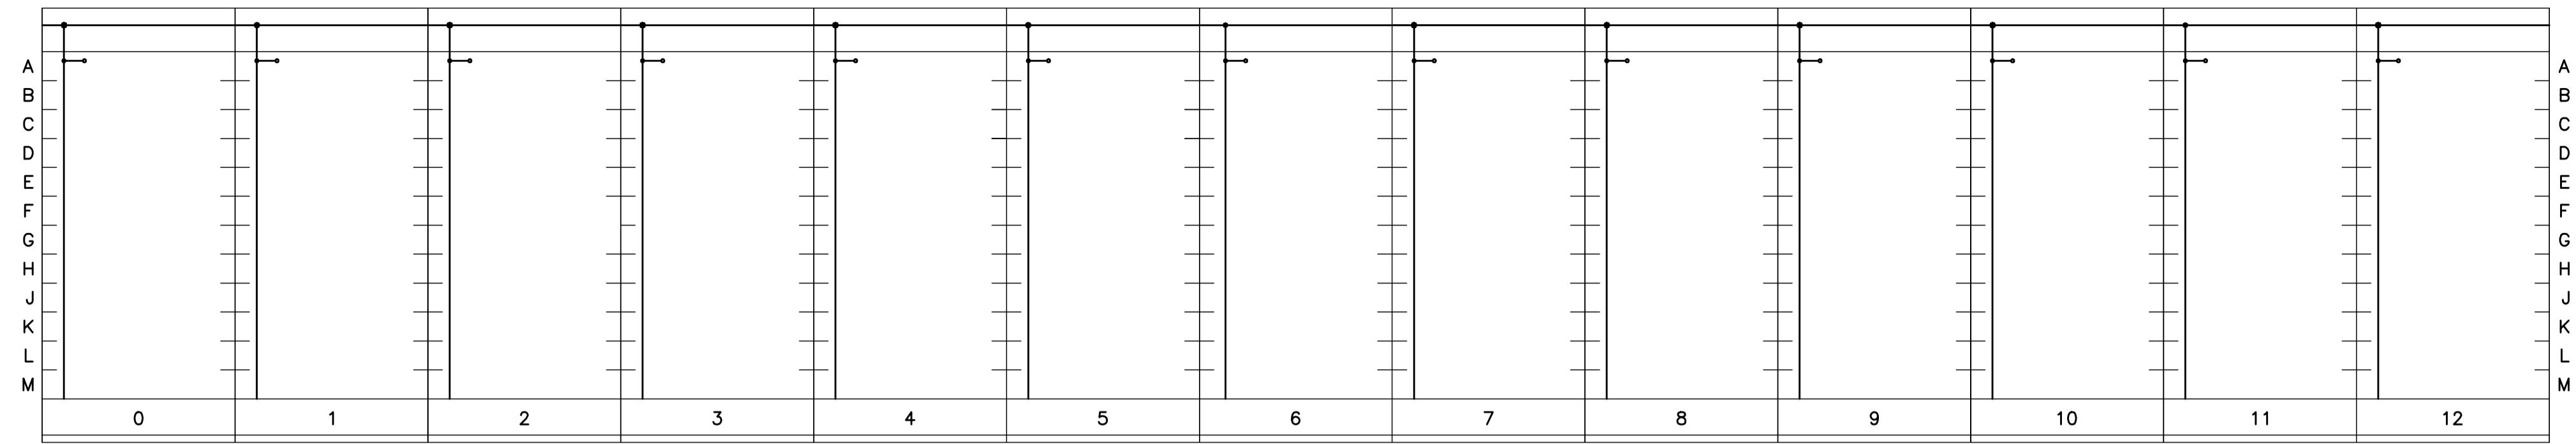

1 MCC-B ELEVATION
SCALE: N.T.S.

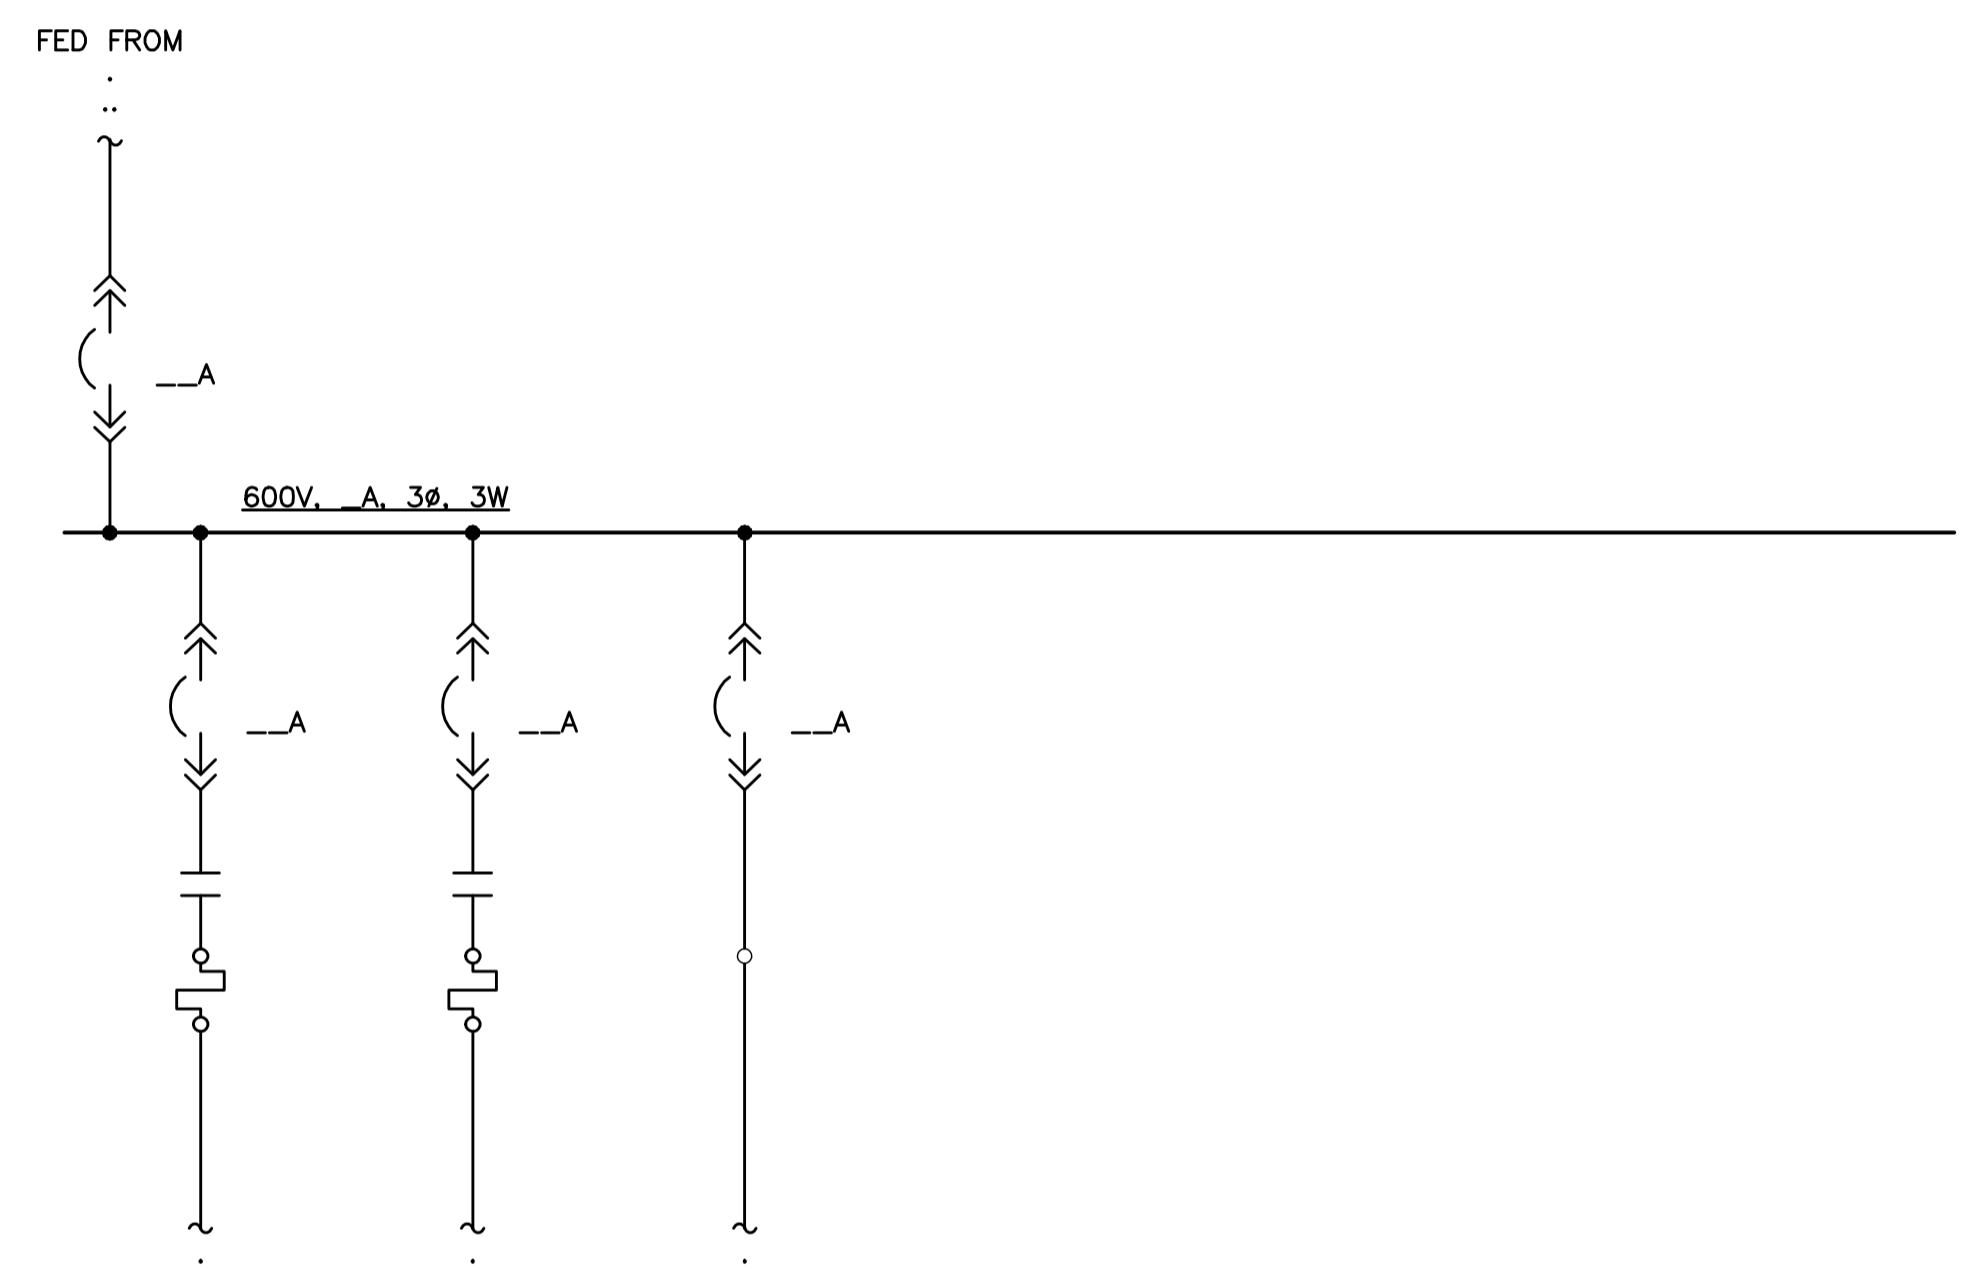

2 SINGLE LINE DIAGRAM
SCALE: N.T.S.

DRAWING RESERVED FOR
FUTURE USE
NOT RELEVANT FOR PROJECT

 Certificate of Authorization KGS Group No. 245 Date: 2010/12/21		B.M. ELEV. :	FIELD BOOK #:	ALLIANCE <i>Engineering Services Inc.</i>	ENGINEER'S SEAL	 R.E. WILLMS Member 3833	 THE CITY OF WINNIPEG WATER AND WASTE DEPARTMENT	SHEET 1 OF 1 CITY DRAWING NUMBER 1-0103A-E0009-001
		DESIGNED BY: REW/AP	CHECKED BY: REW		TENDER No. LE23 FILENAME: 1-0103A-E0009-001-Rev 00.dwg PLOT DATE: 2010/12/16			
		POSTED TO LBIS		DRAWN BY: GCN HDR. SCALE: N.T.S. VERTICAL: N.T.S.	APPROVED BY: REW RELEASED FOR CONSTRUCTION	2010 HVAC REPLACEMENT AND ASSOCIATED WORKS WEWPCC MCC-B SINGLE LINE DIAGRAM AND PHYSICAL LINE UP		
		00 ISSUED FOR TENDER	2010-12-21	2009 09 29				
		NO. REVISIONS	DATE	BY	DATE			