


File Name: P:\Projects\2009\09-0754-08\DocControl\ToBeIssued\DWG\ELECTRICAL\1-0103A-E0016-001-Rev 00.dwg - Tab: 1-0103A-E0016-001-Rev 00.dwg - Tab: 1-0103A-E0016-001-Rev 00.dwg [Thu 5:20pm]


CW-9-M564-1

NOTES:
1. -

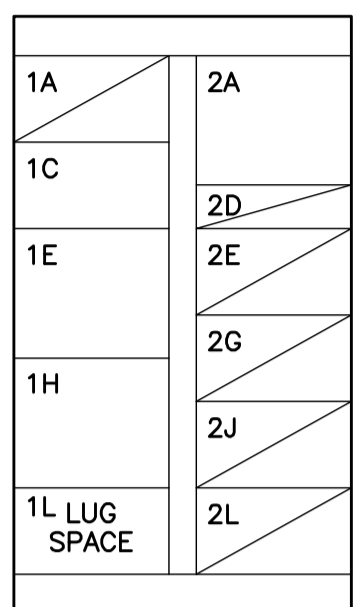

ALLEN BRADLEY DWG. DD2039-003-92

1 MCC-HE ELEVATION
SCALE: N.T.S.

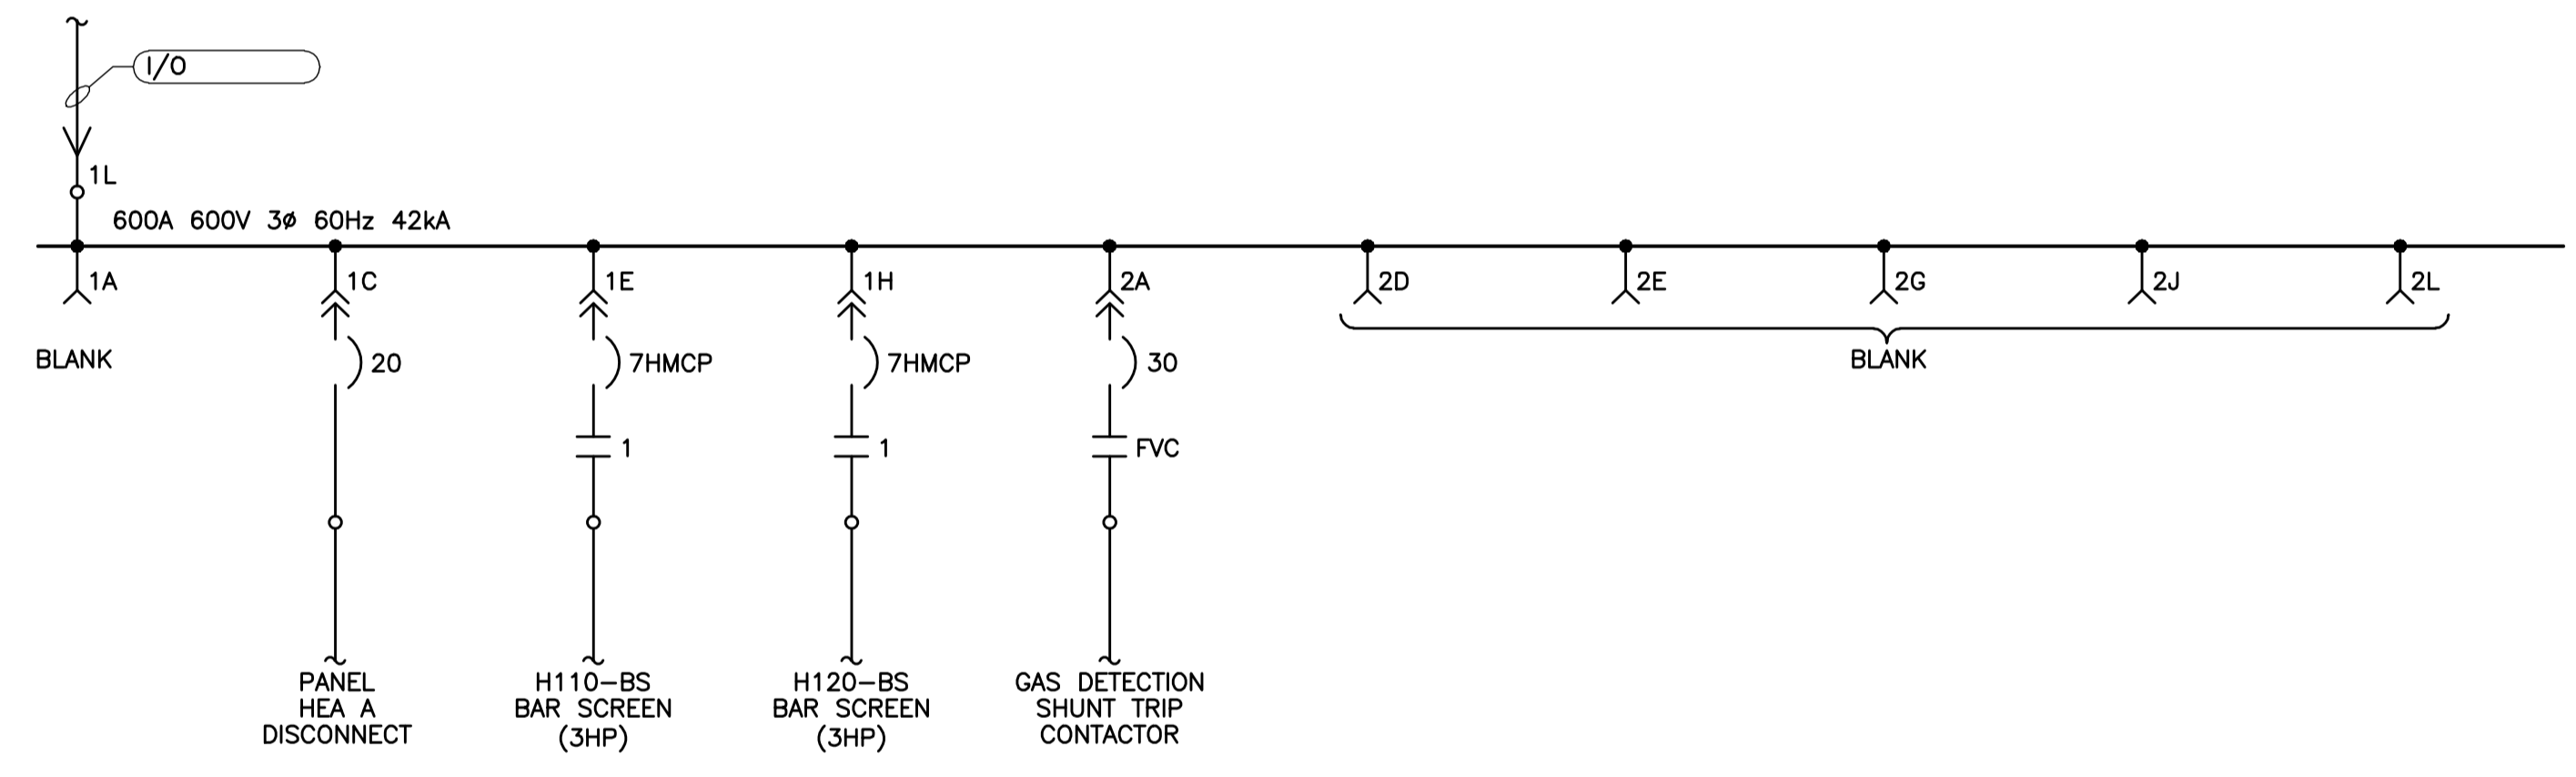

2 MCC-HE SINGLE LINE DIAGRAM
SCALE: N.T.S.

DRAWING RESERVED FOR
FUTURE USE
NOT RELEVANT FOR PROJECT

 Certificate of Authorization KGS Group No. 245 Date: 2010/12/21		B.M. ELEV. . POSTED TO LBIS	FIELD BOOK #: 		ENGINEER'S SEAL 		2010 HVAC REPLACEMENT AND ASSOCIATED WORKS WEWPCC MCC-HE SINGLE LINE DIAGRAM AND PHYSICAL LINE UP	SHEET 1 OF 1 CITY DRAWING NUMBER 1-0103A-E0016-001	
		DESIGNED BY: REW/DDW CHECKED BY: REW		DRAWN BY: GCN APPROVED BY: REW		HDR. SCALE: N.T.S. VERTICAL: N.T.S.		RELEASED FOR CONSTRUCTION TENDER No. LE2.10 FILENAME: 1-0103A-E0016-001-Rev 00.dwg PLOT DATE: 2010/12/16	
		NO. REVISIONS DATE BY		00 ISSUED FOR TENDER 2010-12-21 REW 2009 09 29					