
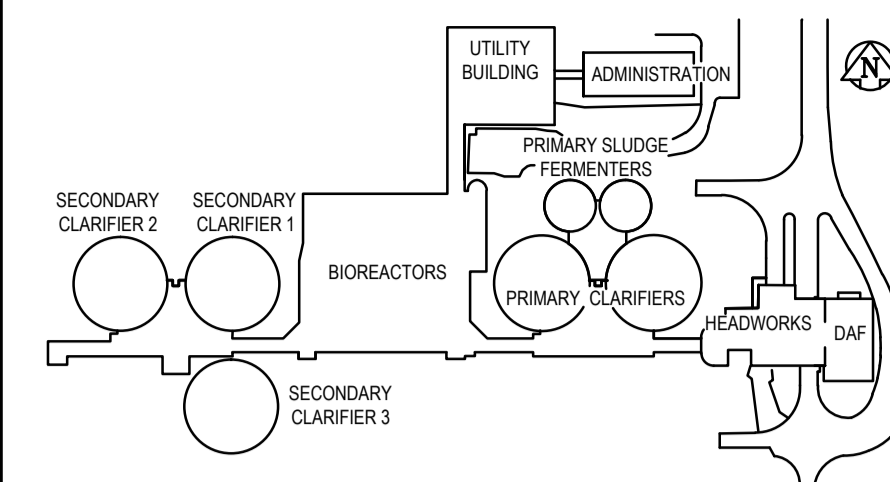
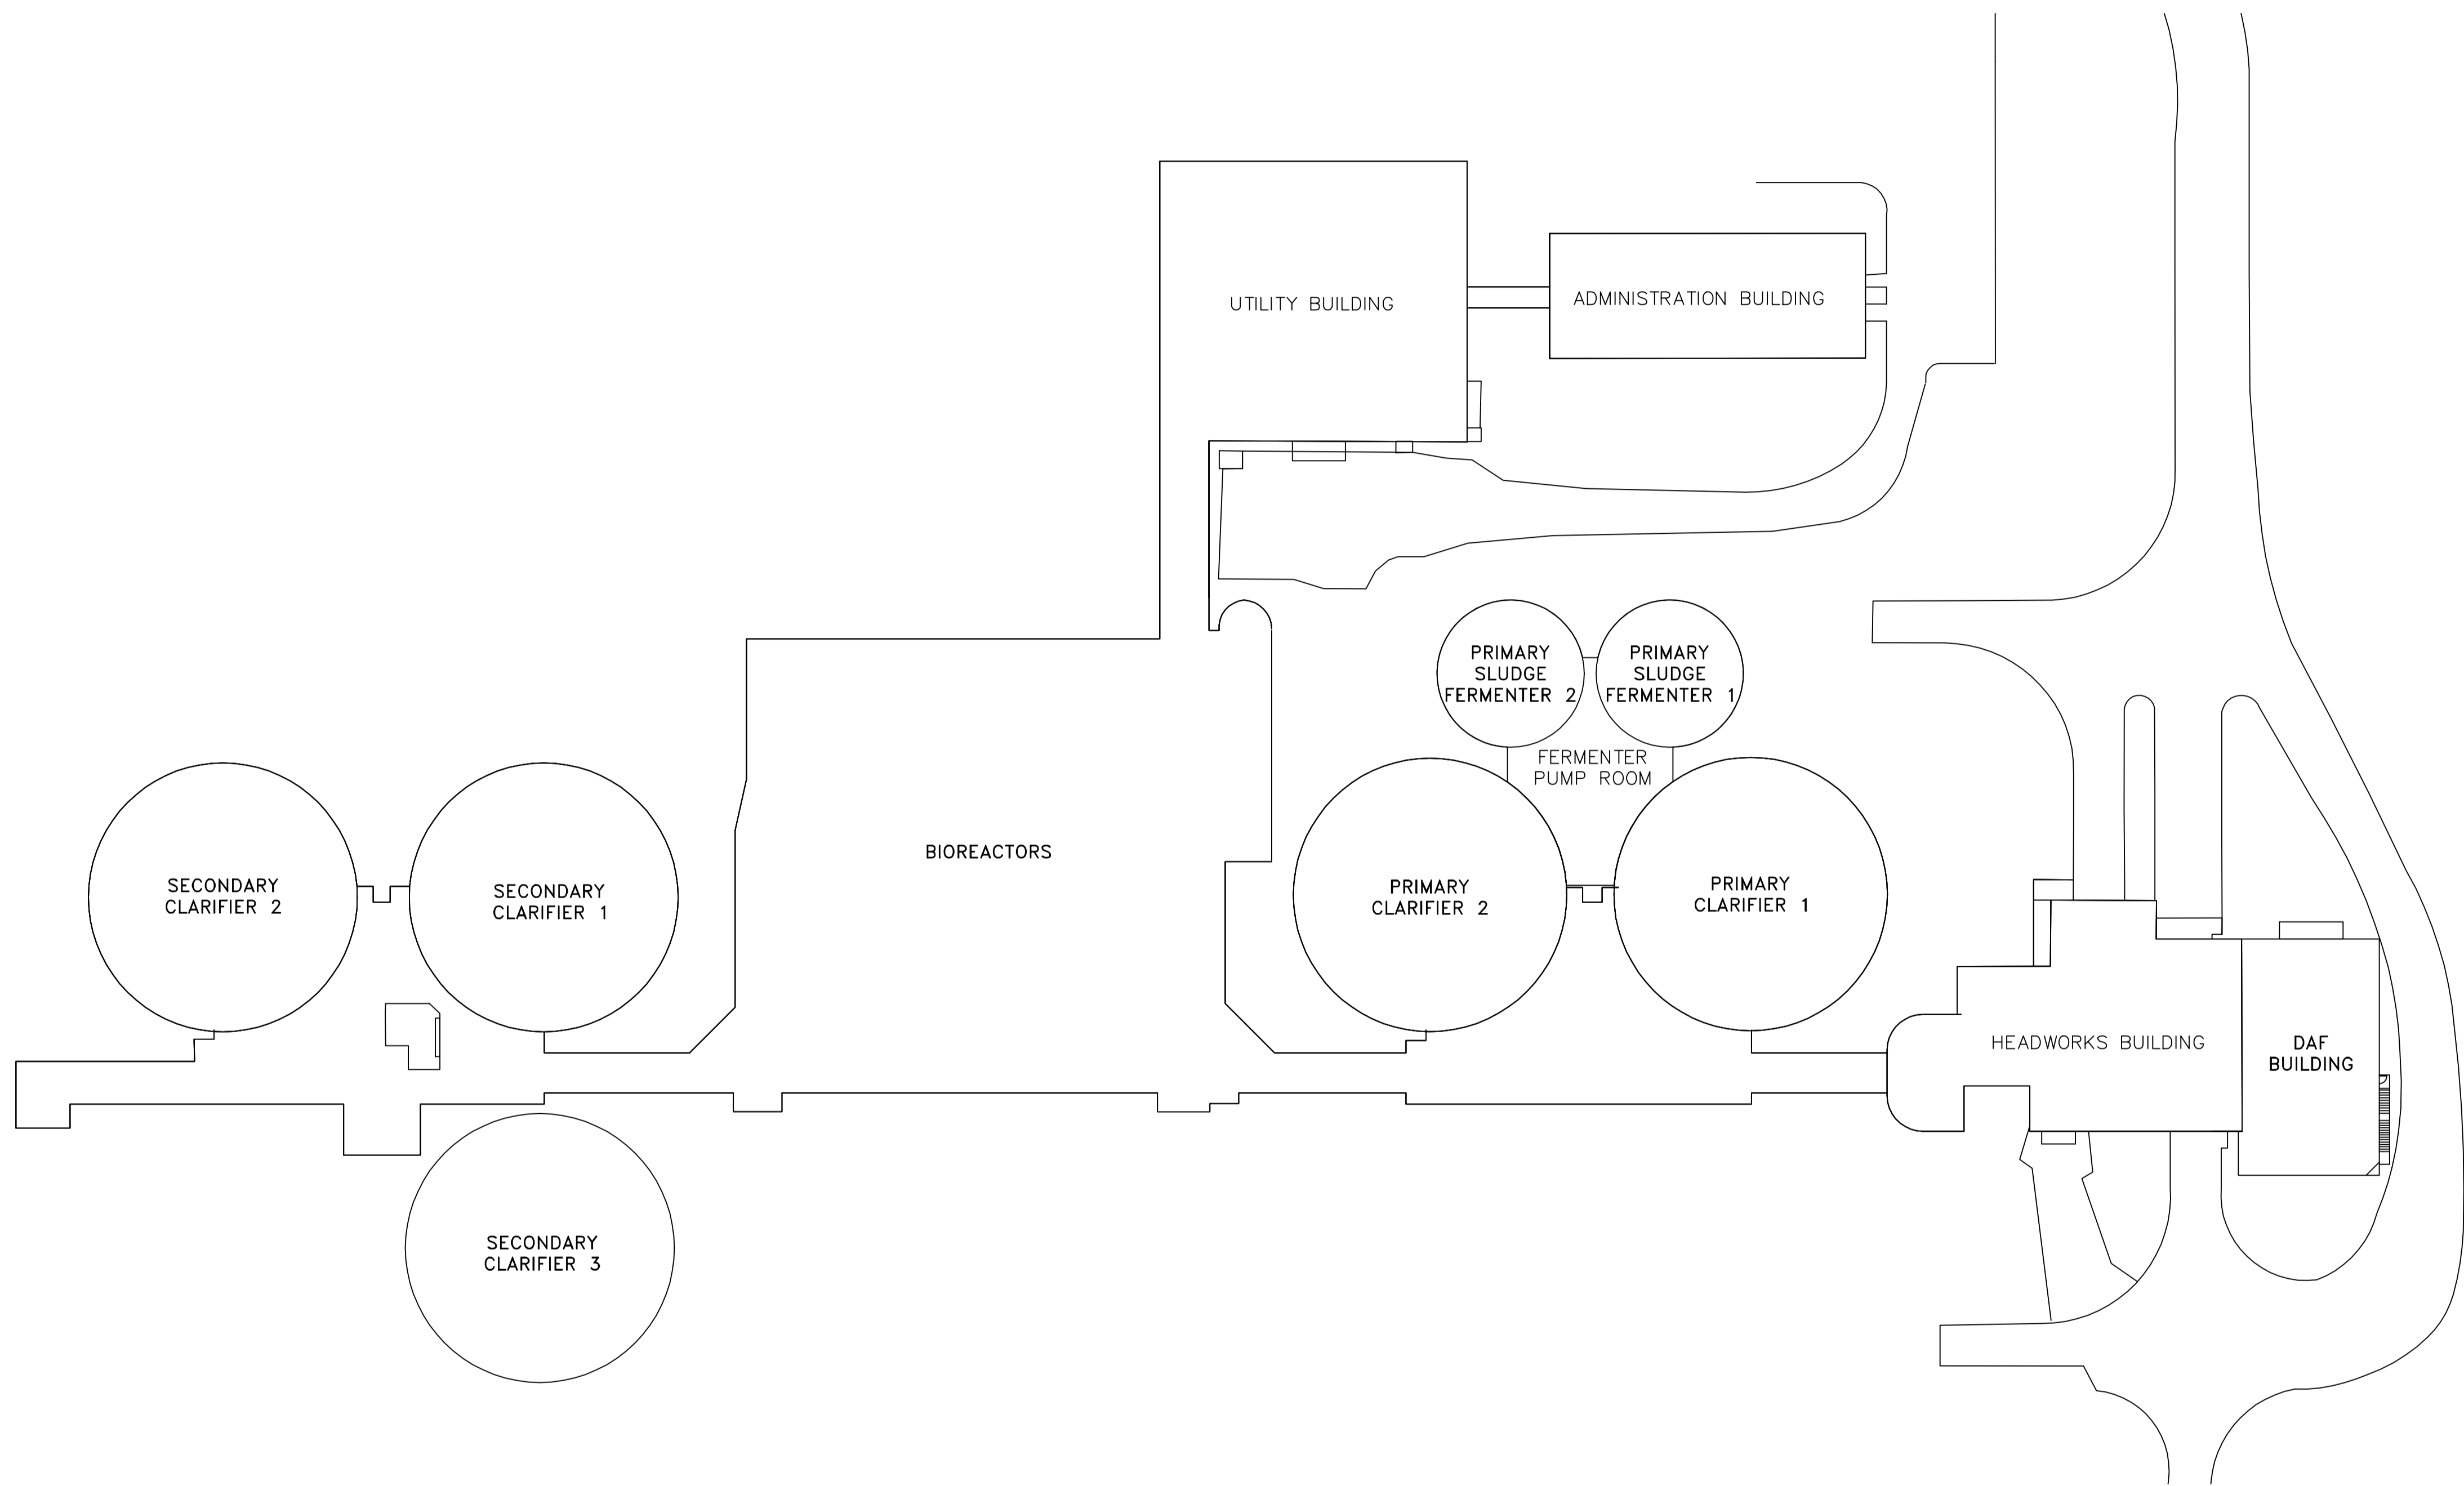



File Name: P:\Projects\2009_09-0754-08\DWG\Elec\20101026 DWG from Alliance\1-0103A-E0017-001.dwg - Tab: 1-0103A-E0017-001.dwg - Plotted By: GNelson 12/17/2010 [Fri 11:38am]

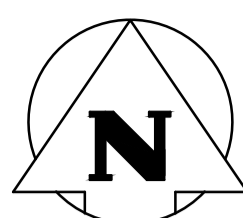

KEY PLAN

NOTES:

1. -

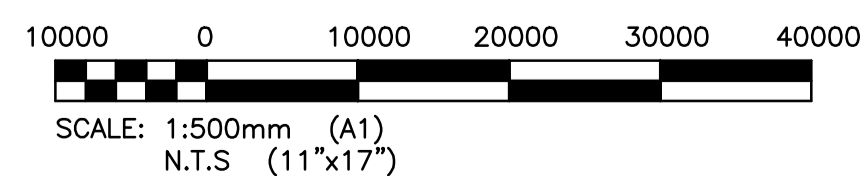

APEGN
Certificate of Authorization
KGS Group
No. 245 Date: 2010/12/21

KGS GROUP
CONSULTING ENGINEERS

B.M. ELEV.	FIELD BOOK #:
POSTED TO LBIS	
DESIGNED BY	DDW
CHECKED BY	REW
DRAWN BY	GCN
APPROVED BY	REW
HOR. SCALE	-
VERTICAL	-
RELEASED FOR CONSTRUCTION	
TENDER No. LE2.11	
FILENAME: 1-0103A-E0017-001.dwg	
PLOT DATE: 2010/12/17	

ALLIANCE
Engineering Services Inc.

ENGINEER'S SEAL
R.E. WILLMS
Member 3833
REGISTERED PROFESSIONAL ENGINEER

THE CITY OF WINNIPEG
WATER AND WASTE DEPARTMENT

2010 HVAC REPLACEMENT AND ASSOCIATED WORKS
WEWPCC
AREA L - GENERAL AND SITEWORKS ELECTRICAL SITE PLAN

SHEET 1 OF 1
CITY DRAWING NUMBER
1-0103A-E0017-001