


NO.	DATE	DESCRIPTION
1	MAY 14, 2010	ISSUED FOR CLIENT REVIEW
2	MAY 18, 2010	ISSUED FOR CLIENT REVIEW
3	SEPT. 24, 2010	ISSUED FOR BUILDING PERMIT
4	DEC. 10, 2010	ISSUED FOR TENDER

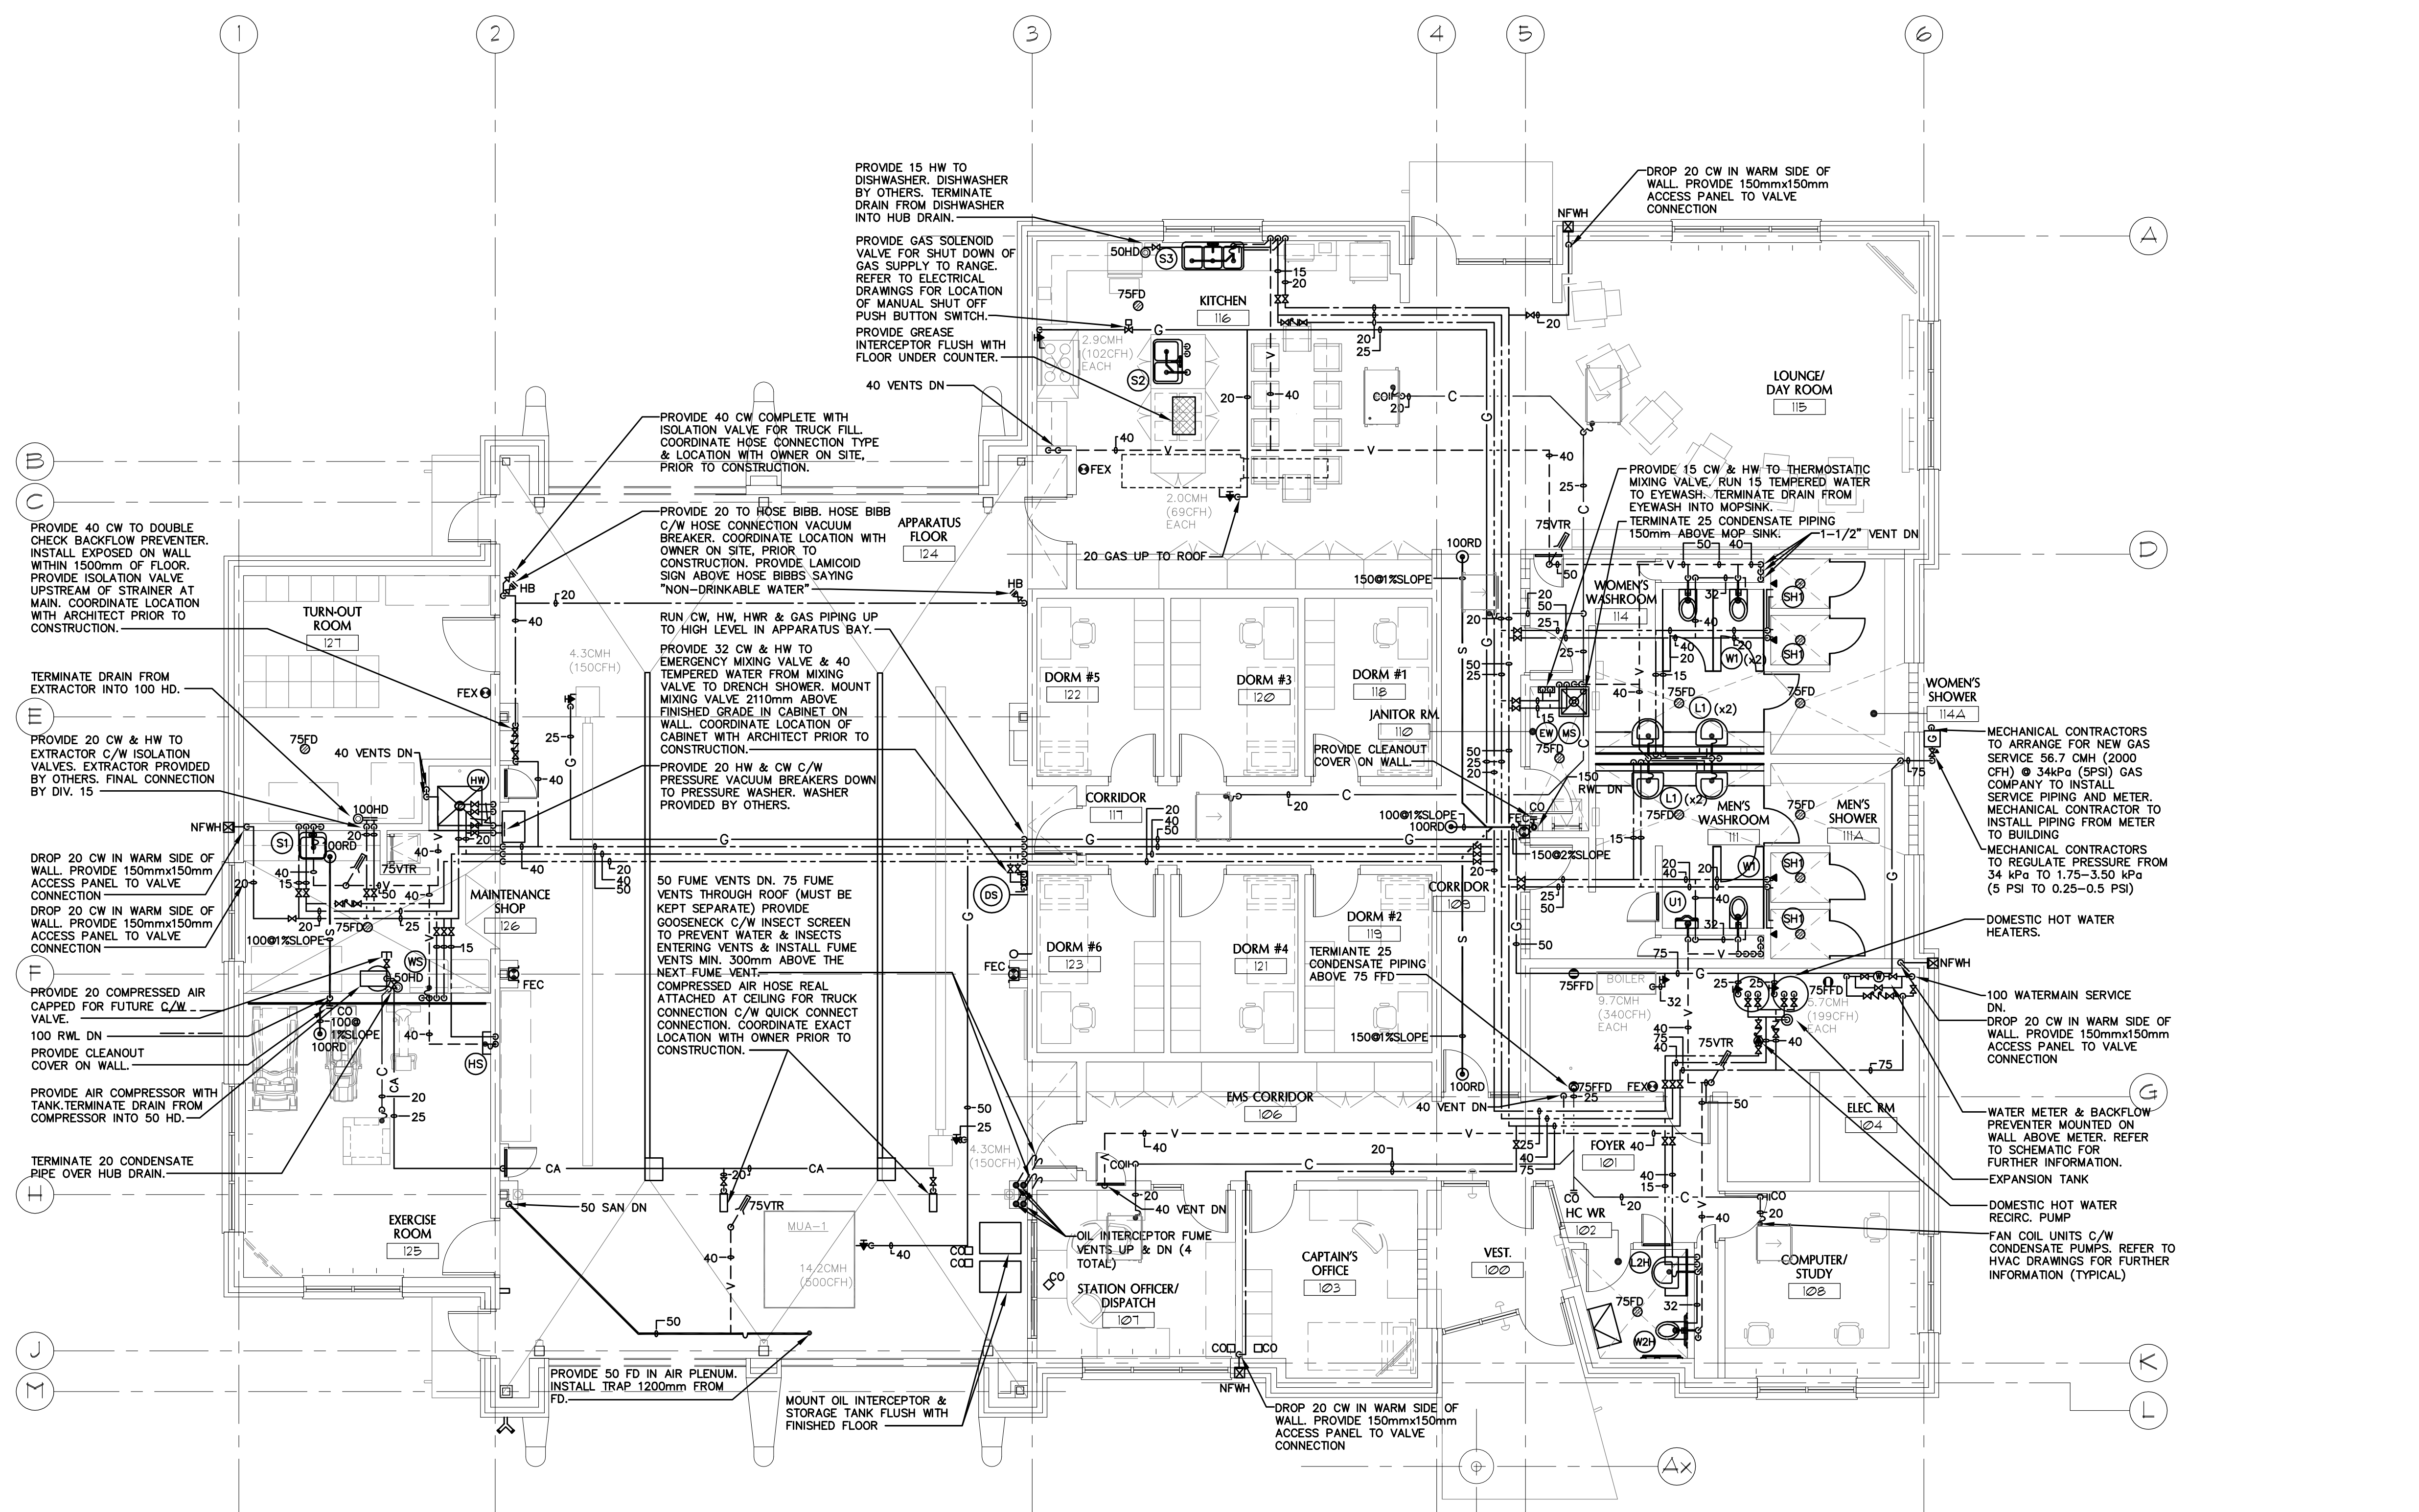

VANDERWESTEN RUTHERFORD MANTECON INC.
 CONSULTING STRUCTURAL-MECHANICAL-ELECTRICAL ENGINEERS
 LONDON • HAMILTON • WINNIPEG • OTTAWA
 7242 COLONEL TALBOT ROAD, LONDON, ONTARIO, N6L 1H8
 PHONE: (519) 882-5047 FAX: (519) 882-5058 www.vrmeng.com

REVIEW ALL DRAWINGS AND VERIFY ALL DIMENSIONS AT THE SITE. DO NOT SCALE THE DRAWINGS. REPORT ALL DISCREPANCIES TO THE ENGINEER BEFORE PROCEEDING WITH ANY CONSTRUCTION OR SHOP FABRICATION. ALL DRAWINGS, SPECIFICATIONS AND RELATED DOCUMENTS ARE THE COPYRIGHT PROPERTY OF VANDERWESTEN RUTHERFORD MANTECON AND MUST BE RETURNED UPON REQUEST. REPRODUCTION OF DRAWINGS, SPECIFICATIONS AND RELATED DOCUMENTS IN PART OR WHOLE IS FORBIDDEN WITHOUT THE CONSULTANT'S WRITTEN PERMISSION.

PROJECT NAME:
NEW WINNIPEG STATION No. 27 PROJECT
 SAGE CREEK, WINNIPEG, MANITOBA

DRAWING TITLE:
FLOOR PLAN - PLUMBING

PROJECT NORTH:

SCALE: 1/16

DATE: DECEMBER 10, 2010

ISSUED: DECEMBER 10, 2010

DRAWN BY: CS

CHECKED BY: HA

STAMP:

PROJECT NO.: **2261**

FILE NAME:

DRAWING NO.: **M2.2**

NOT VALID FOR CONSTRUCTION UNLESS SIGNED

