




1 PULL STATION DETAIL - CLASS 1, ZONE 2
SCALE 1:4

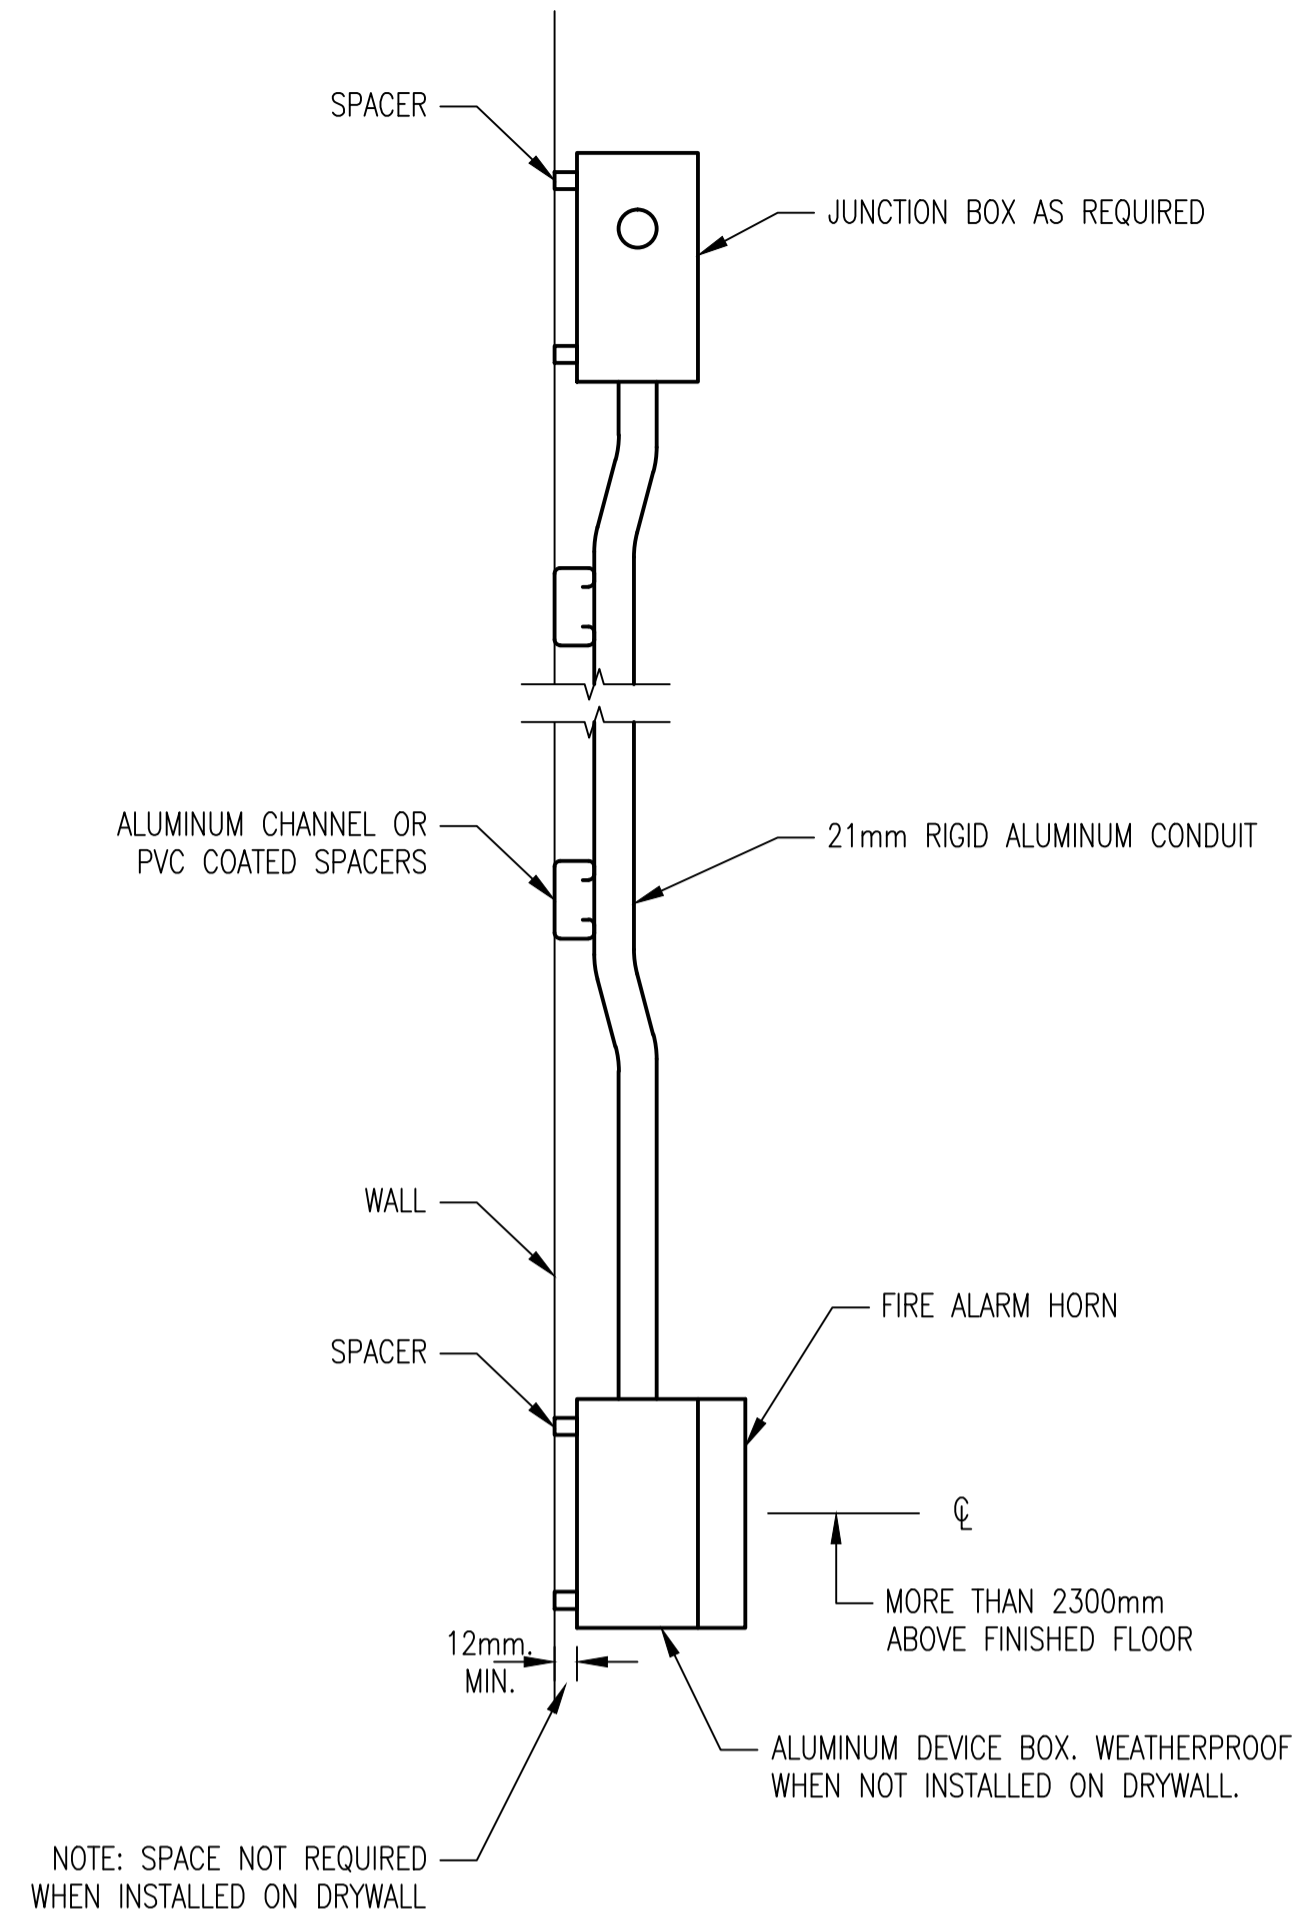


2 AUDIBLE SIGNAL DEVICE - UNCLASSIFIED LOCATION
SCALE 1:4

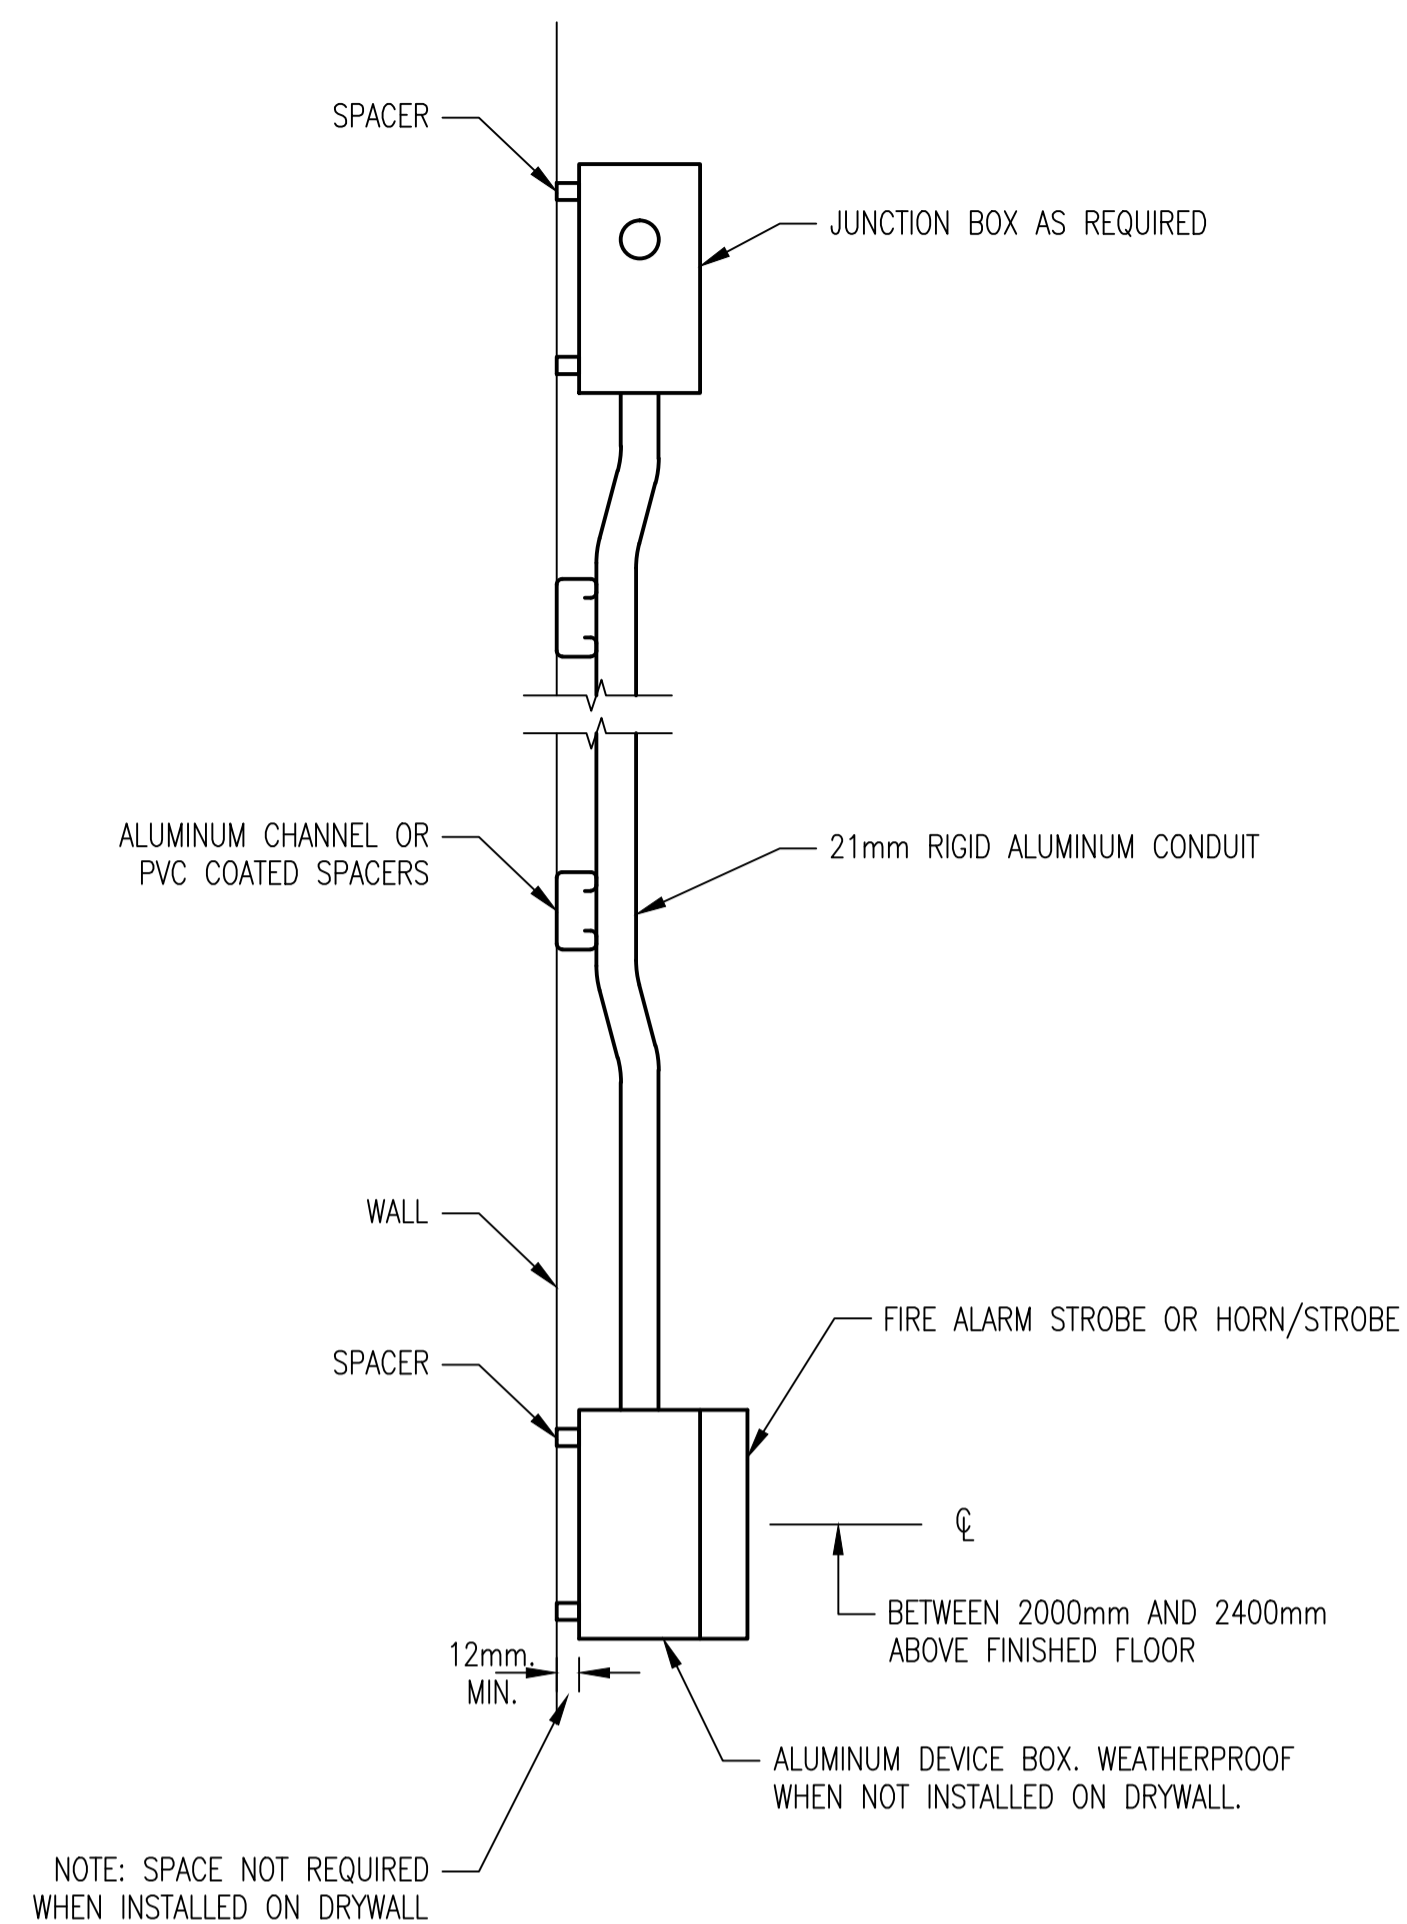

3 VISIBLE SIGNAL DEVICE - UNCLASSIFIED LOCATION
SCALE 1:4

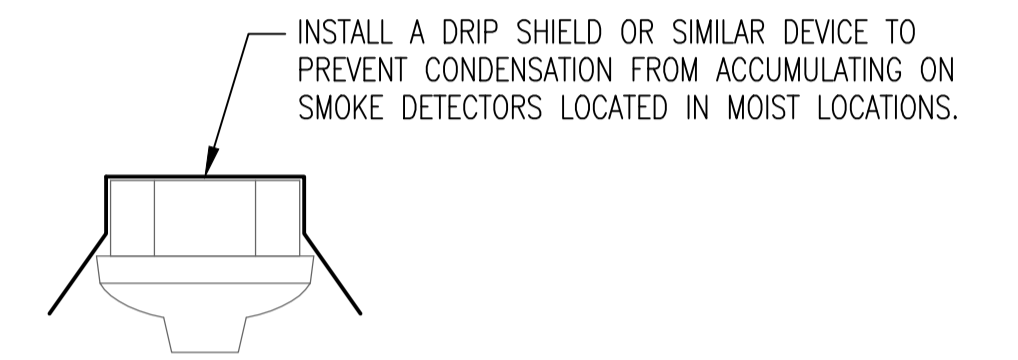

4 SMOKE DETECTOR DRIP SHIELD DETAIL
SCALE 1:4

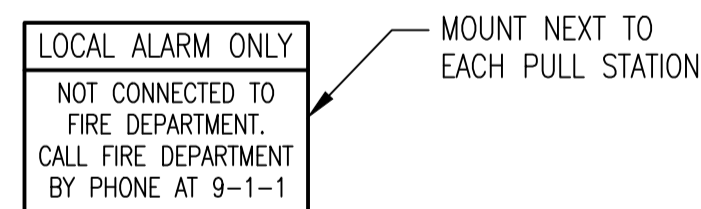

5 PULL STATION SIGN
SCALE NTS

NOTES:
1. THE DETAILS SHOWN ARE SUITABLE FOR CATEGORY 2 WET LOCATIONS.



| NO. | REVISIONS | DATE | DESIGN | CHECK |
|-----|--------------------------------------|------------|--------|-------|
| 00 | ISSUED FOR TENDER, BID OPP. 209-2011 | 2011/03/11 | EFB | CJR |

| | | | |
|-----------------|------------|---|---------------|
| | | SNC-LAVALIN INC. 148 Nature Park Way Winnipeg, MB, Canada R3P 0X7 204-786-8080 | |
| DESIGNED BY: | E. BOHNCKE | CHECKED BY: | C. REIMER |
| DRAWN BY: | S. COATES | APPROVED BY: | C. REIMER |
| SCALE: | AS SHOWN | RELEASED FOR CONSTRUCTION BY: | N. HARRINGTON |
| DATE: | 2011/03/22 | DATE: | 2011/03/11 |
| CONSULTANT NO.: | | 112577-0101-40DD-0004 | |

ENGINEER'S SEAL
ORIGINAL DRAWING
SEALED BY:
C. J. REIMER
SNC-LAVALIN
MEMBER #21968
2011/03/25
REV. 00

THE CITY OF WINNIPEG
 WATER AND WASTE DEPARTMENT
 SOUTH END WATER POLLUTION CONTROL CENTER
 FIRE ALARM UPGRADE
 INSTALLATION DETAILS
 CITY DRAWING NUMBER: 1-0102A-E0004
 SHEET: 001
 REV.: 00
 SIZE: A1

| | |
|----------------|-------------------------------|
| 1-0102A-E0001 | FIRE ALARM LEGEND AND DETAILS |
| DRAWING NUMBER | REFERENCE DRAWINGS |