



D SIZE 22" x 34" (559mm x 864mm)

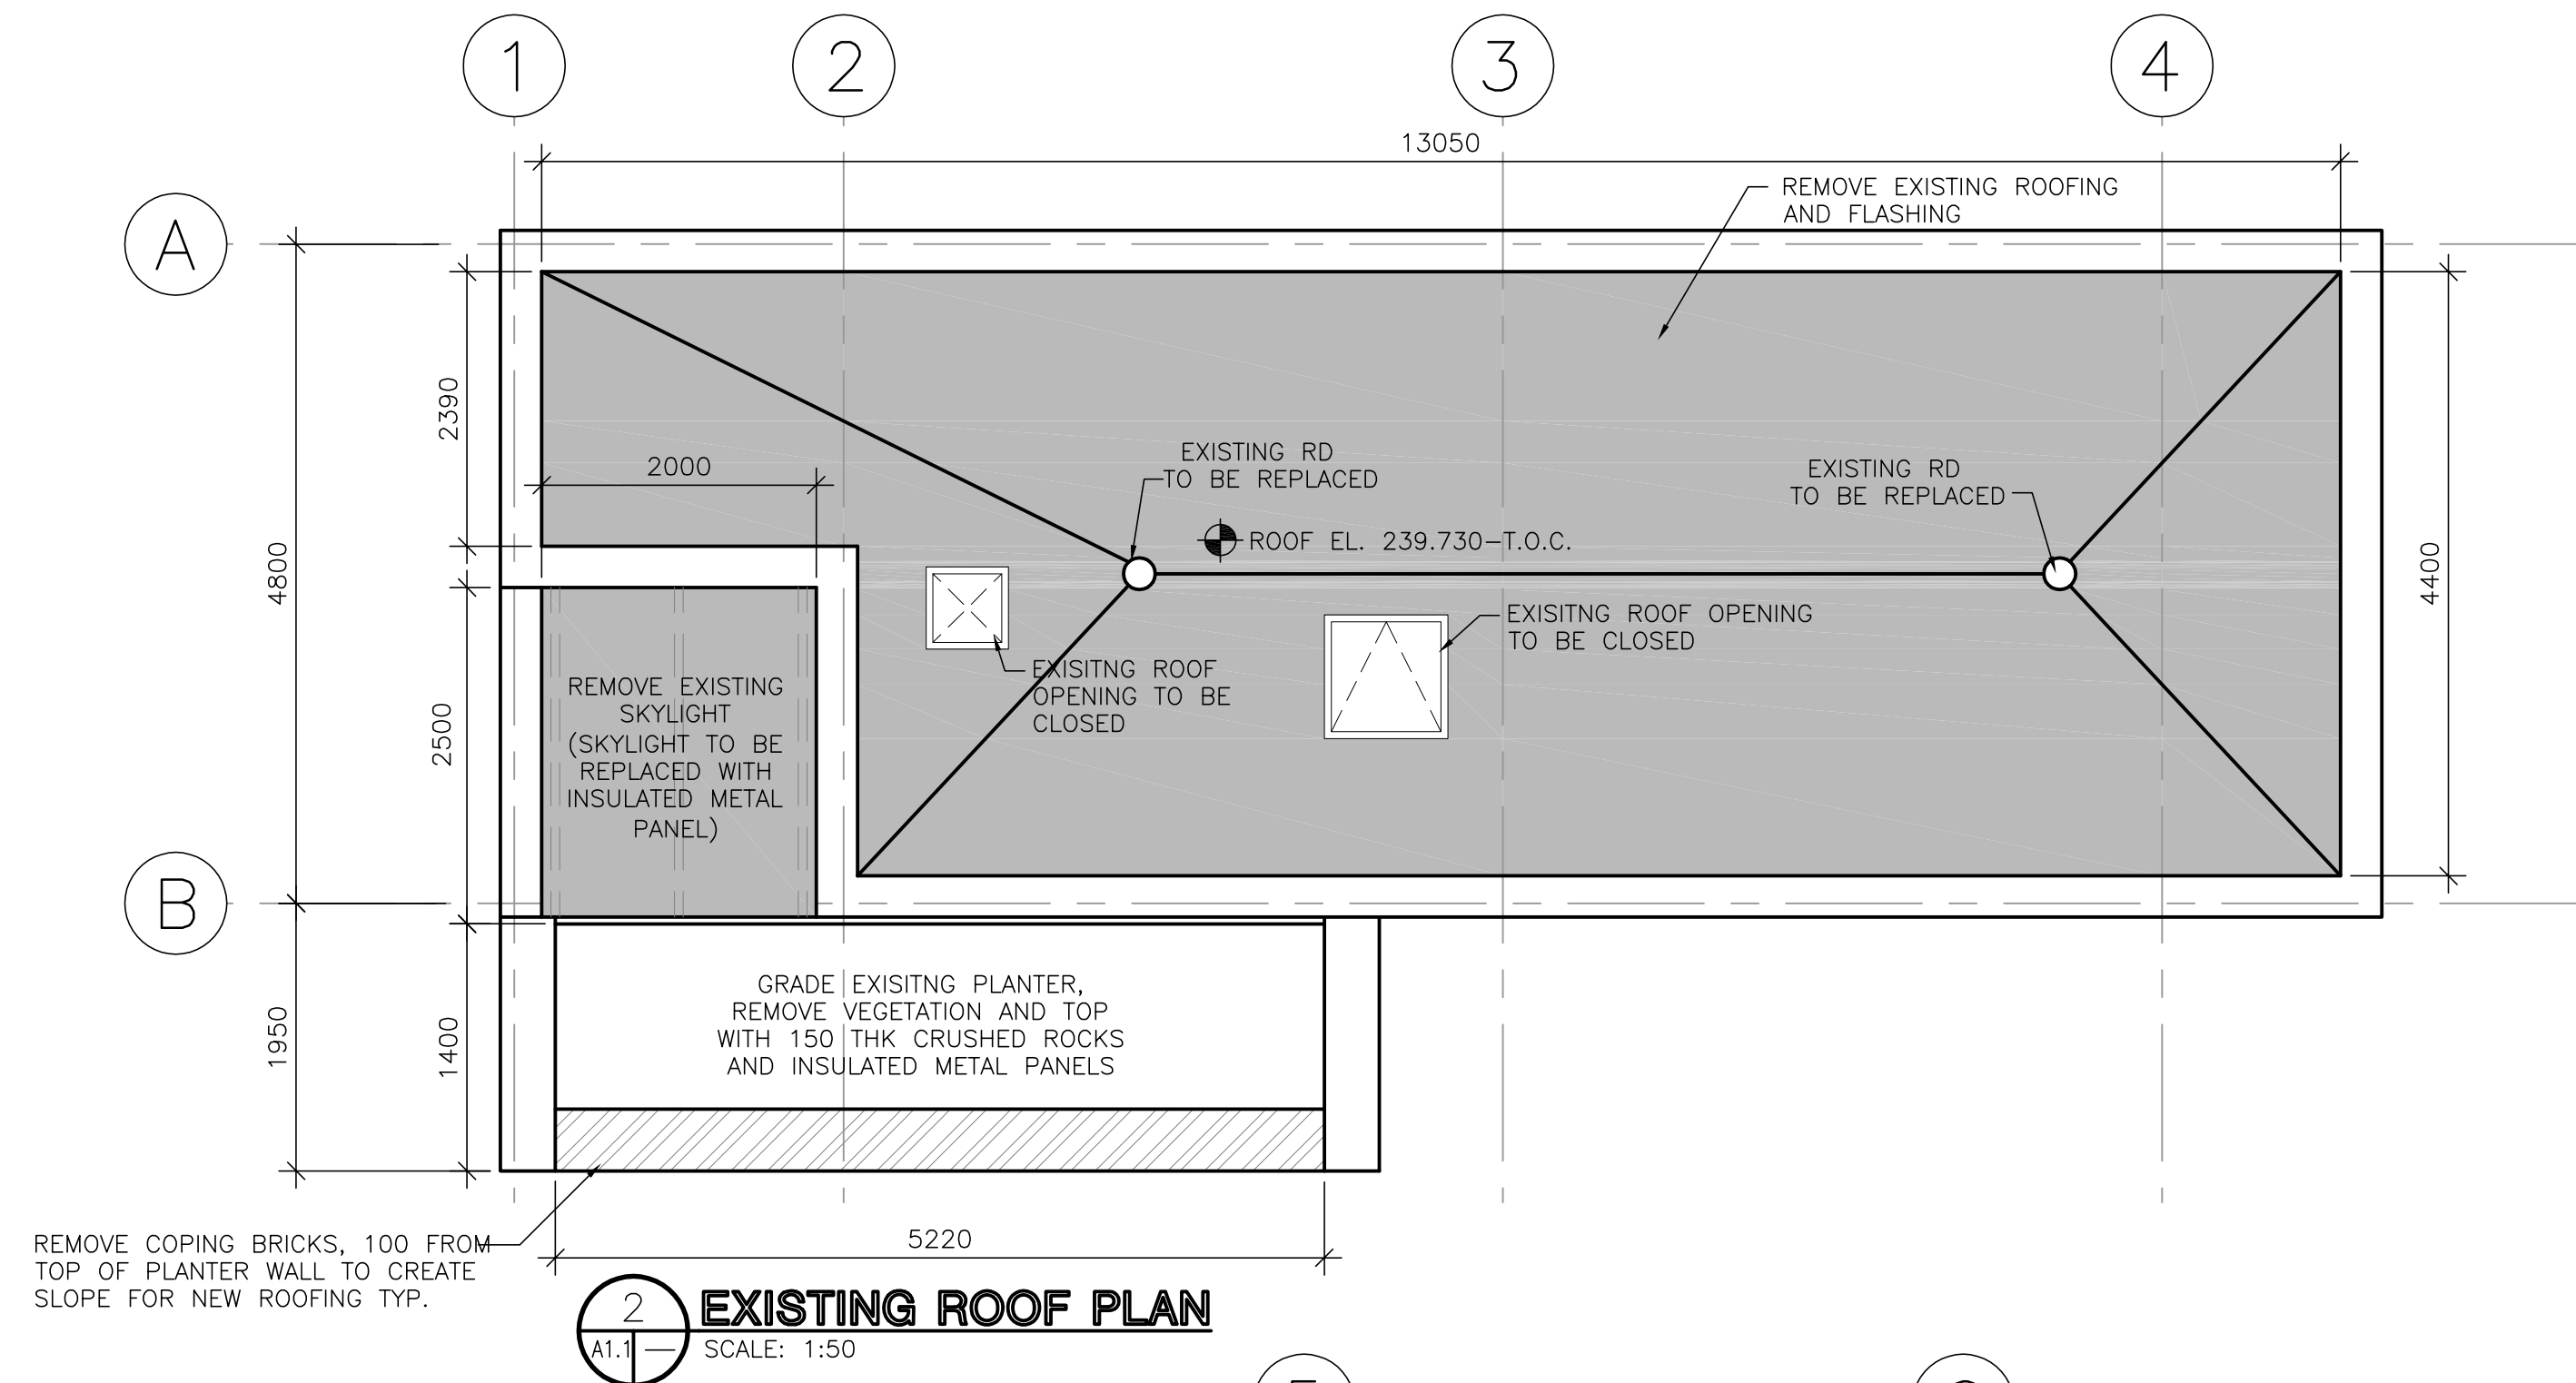


REMOVE COPING BRICKS, 100 FROM TOP OF PLANTER WALL TO CREATE SLOPE FOR NEW ROOFING TYP.

2 EXISTING ROOF PLAN
A1.1 SCALE: 1:50

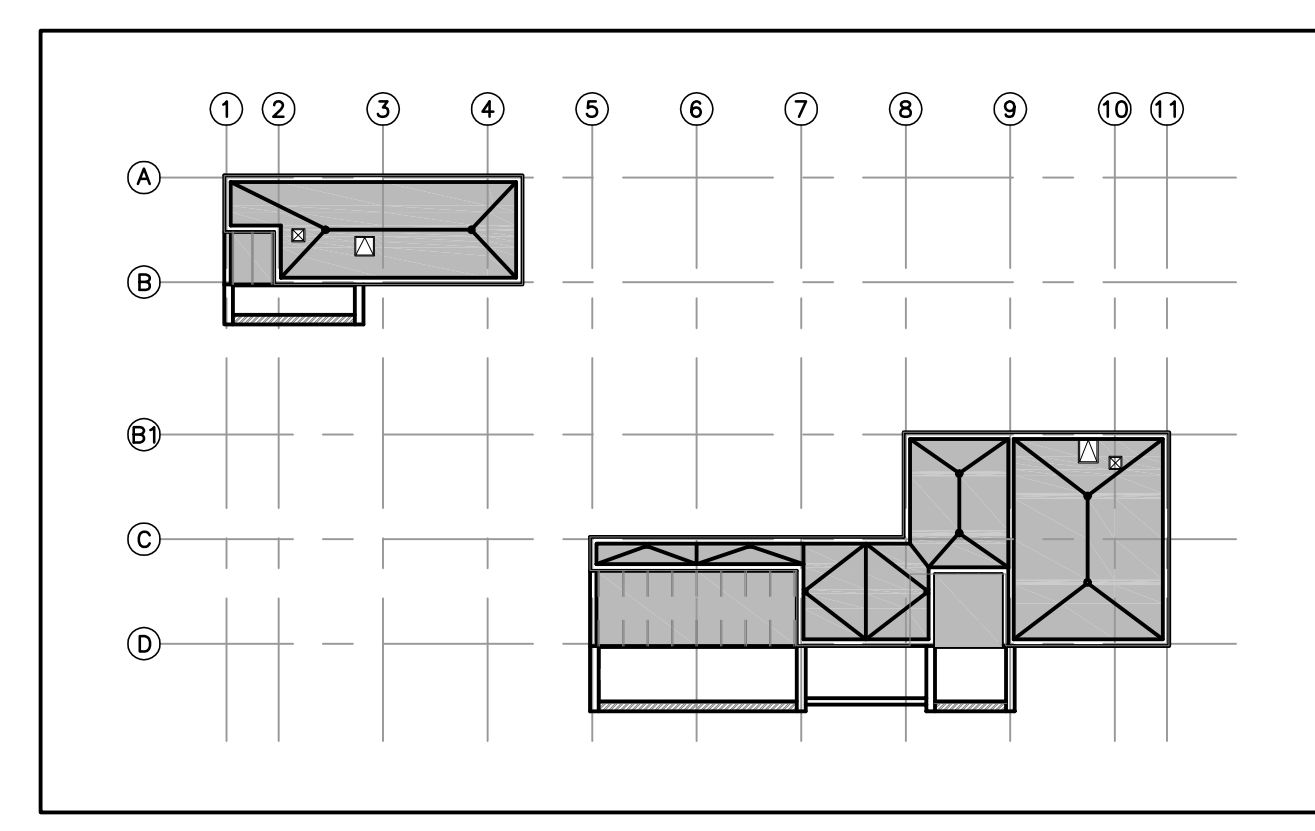

KEY PLAN NTS

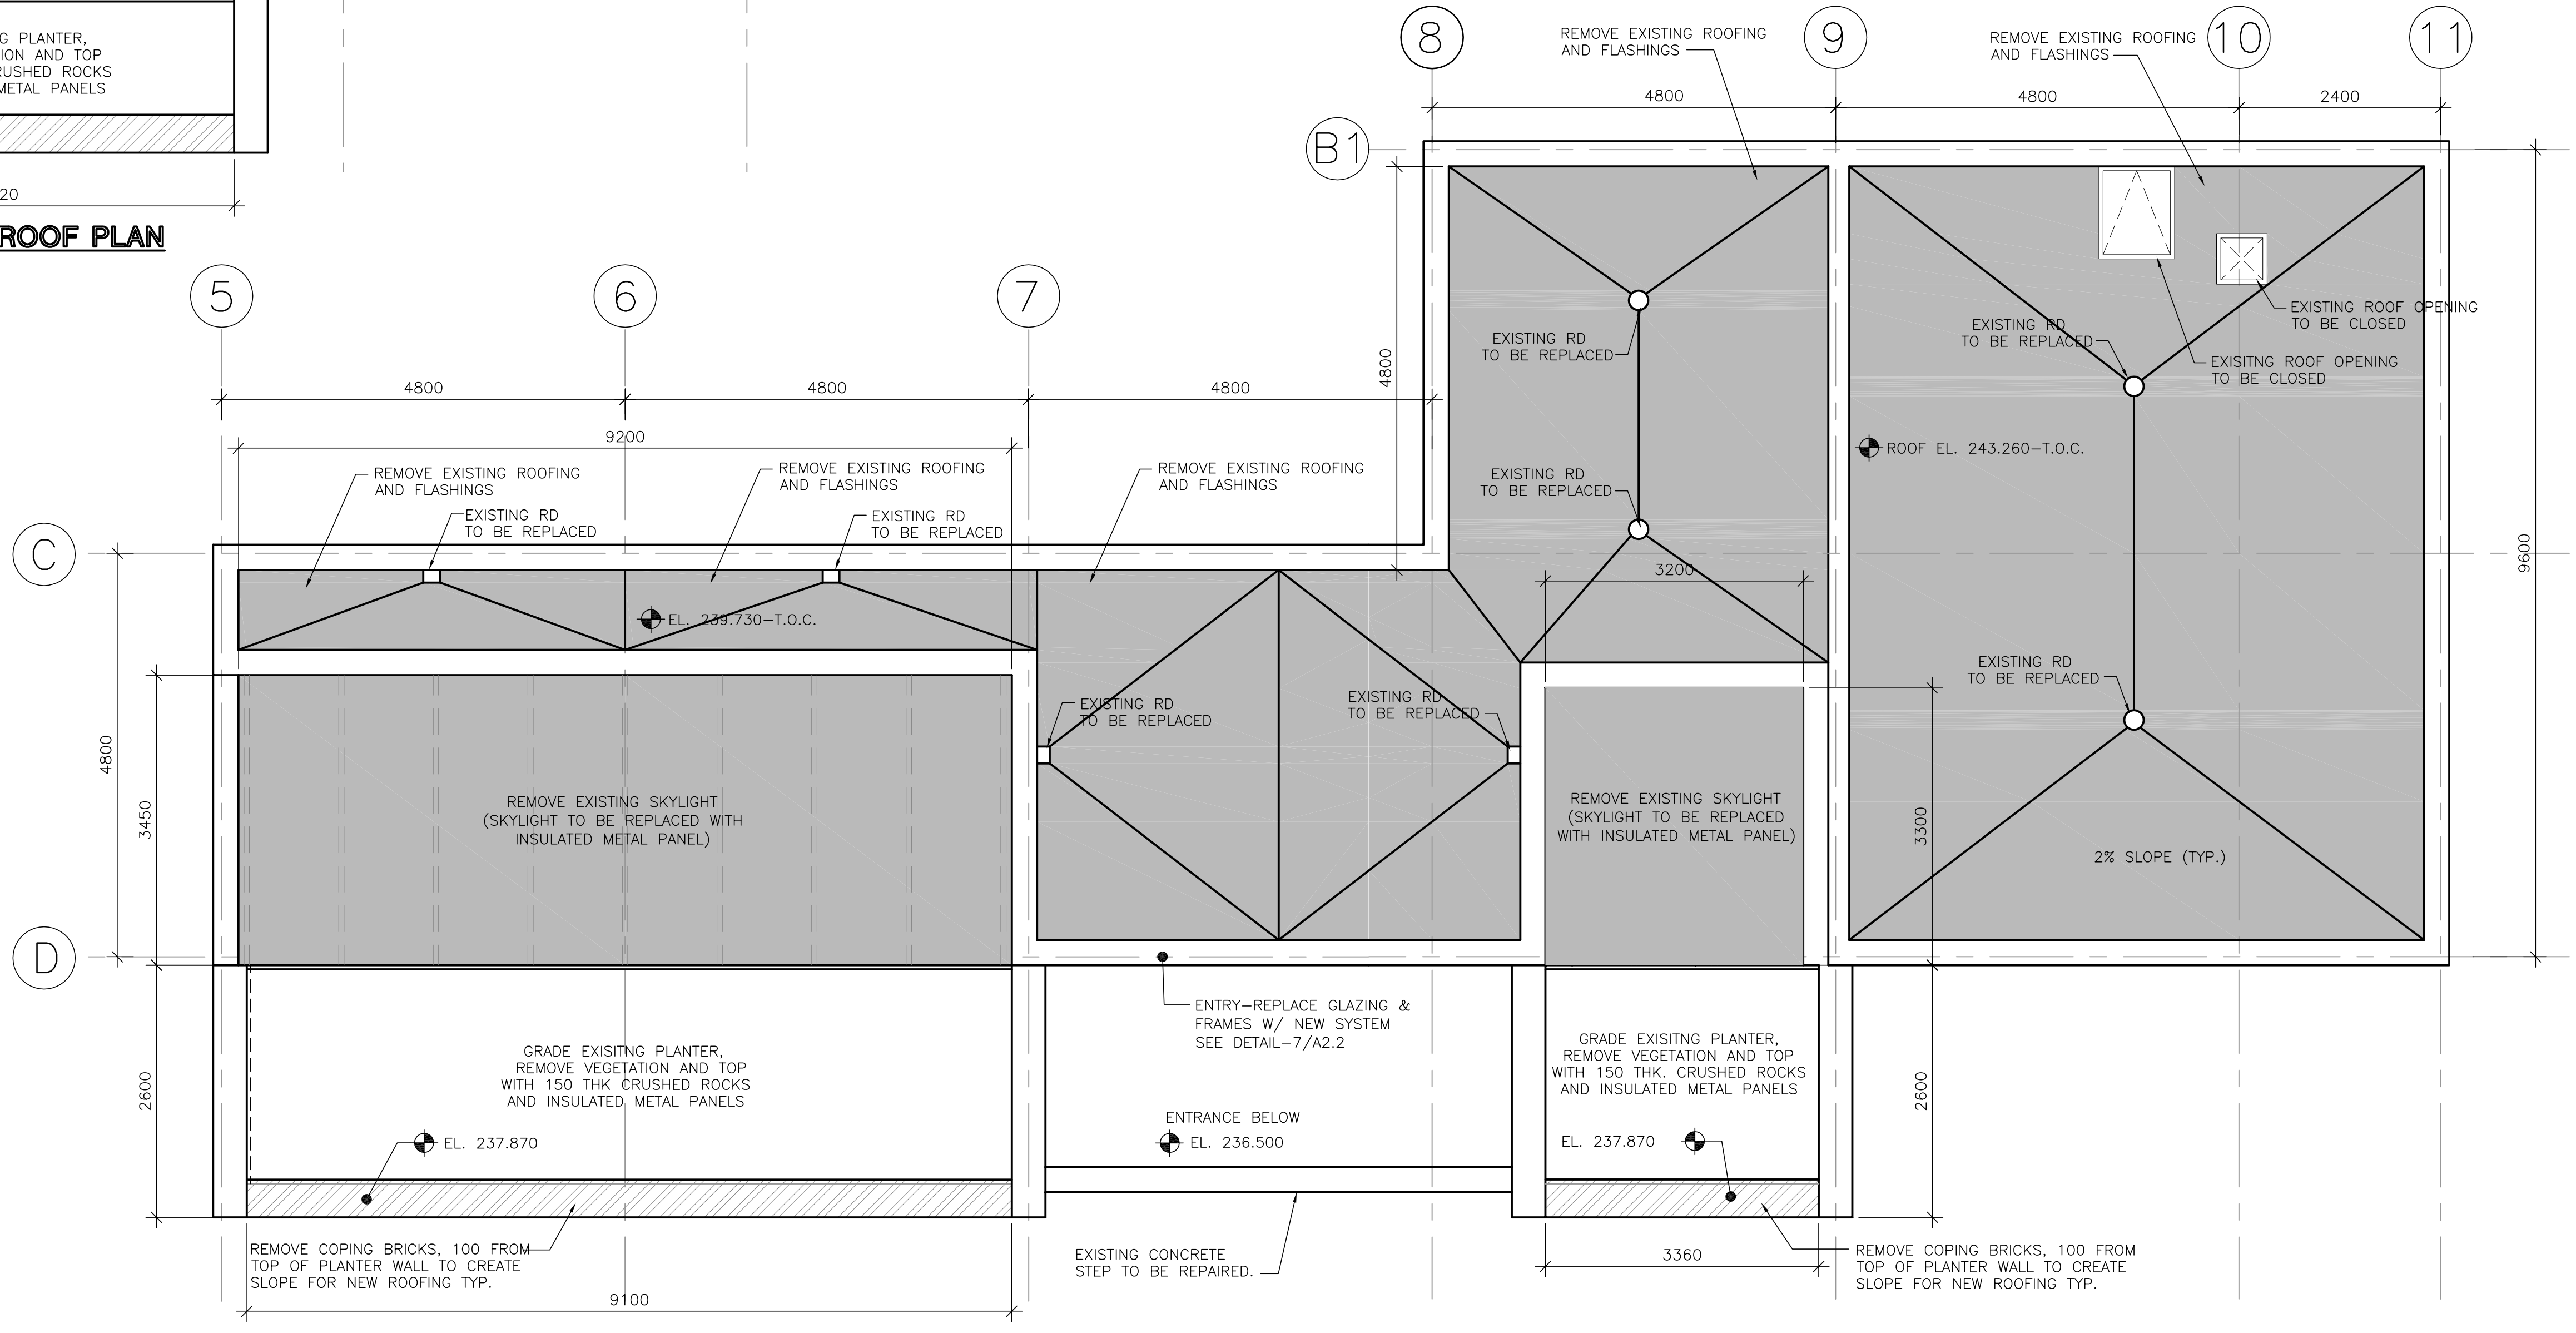

LEGEND:
 EXISTING ROOFING, FLASHING AND ROOF DRAIN TO BE REMOVED
 EXISTING PLANTER COPING BRICK TO BE REMOVED

1 EXISTING ROOF PLAN
A1.1 SCALE: 1:50



LOCATION APPROVED
UNDERGROUND STRUCTURES

SUPR. UG STRUCTURES DATE COMMITTEE

NOTE:
LOCATION OF UNDERGROUND STRUCTURES AS SHOWN ARE BASED ON THE BEST INFORMATION AVAILABLE. BUT NO GUARANTEE IS GIVEN THAT ALL EXISTING UTILITIES ARE SHOWN OR THAT THE GIVEN LOCATIONS ARE EXACT. CONFIRMATION OF EXISTENCE AND EXACT LOCATION OF ALL SERVICES MUST BE OBTAINED FROM THE INDIVIDUAL UTILITIES BEFORE PROCEEDING WITH CONSTRUCTION.

00	ISSUED FOR TENDER	11/05/03	AL
NO.	REVISIONS	YYMMDD	BY

Neil Cooper Architect Inc.
10-395 Berry Street, Winnipeg, Manitoba R3J 1N6
Phone (204) 885-3855 Fax (204) 831-7148

DESIGNED BY	NC	CHECKED BY	NC
DRAWN BY	AG/AL	APPROVED BY	NC
HOR. SCALE	1:50	RELEASED FOR CONSTRUCTION BY:	JESSICA MCOMBE
VERT. SCALE	1:50	ORIG. SIGNED:	JESSICA MCOMBE
DATE		DATE	03 MAY 2011



BID OPPORTUNITY NO. 377-2011

THE CITY OF WINNIPEG
WATER AND WASTE DEPARTMENT

DEACON BOOSTER PUMPING STATION BLDG
UPGRADES & MAINTENANCE

DEMOLITION PLAN

SHEET 1 OF 3	CITY DRAWING NUMBER
	1-0620D-B0001-001
	REV 00