



UNDERGROUND STORAGE TANK - SIDE VIEW

NTS

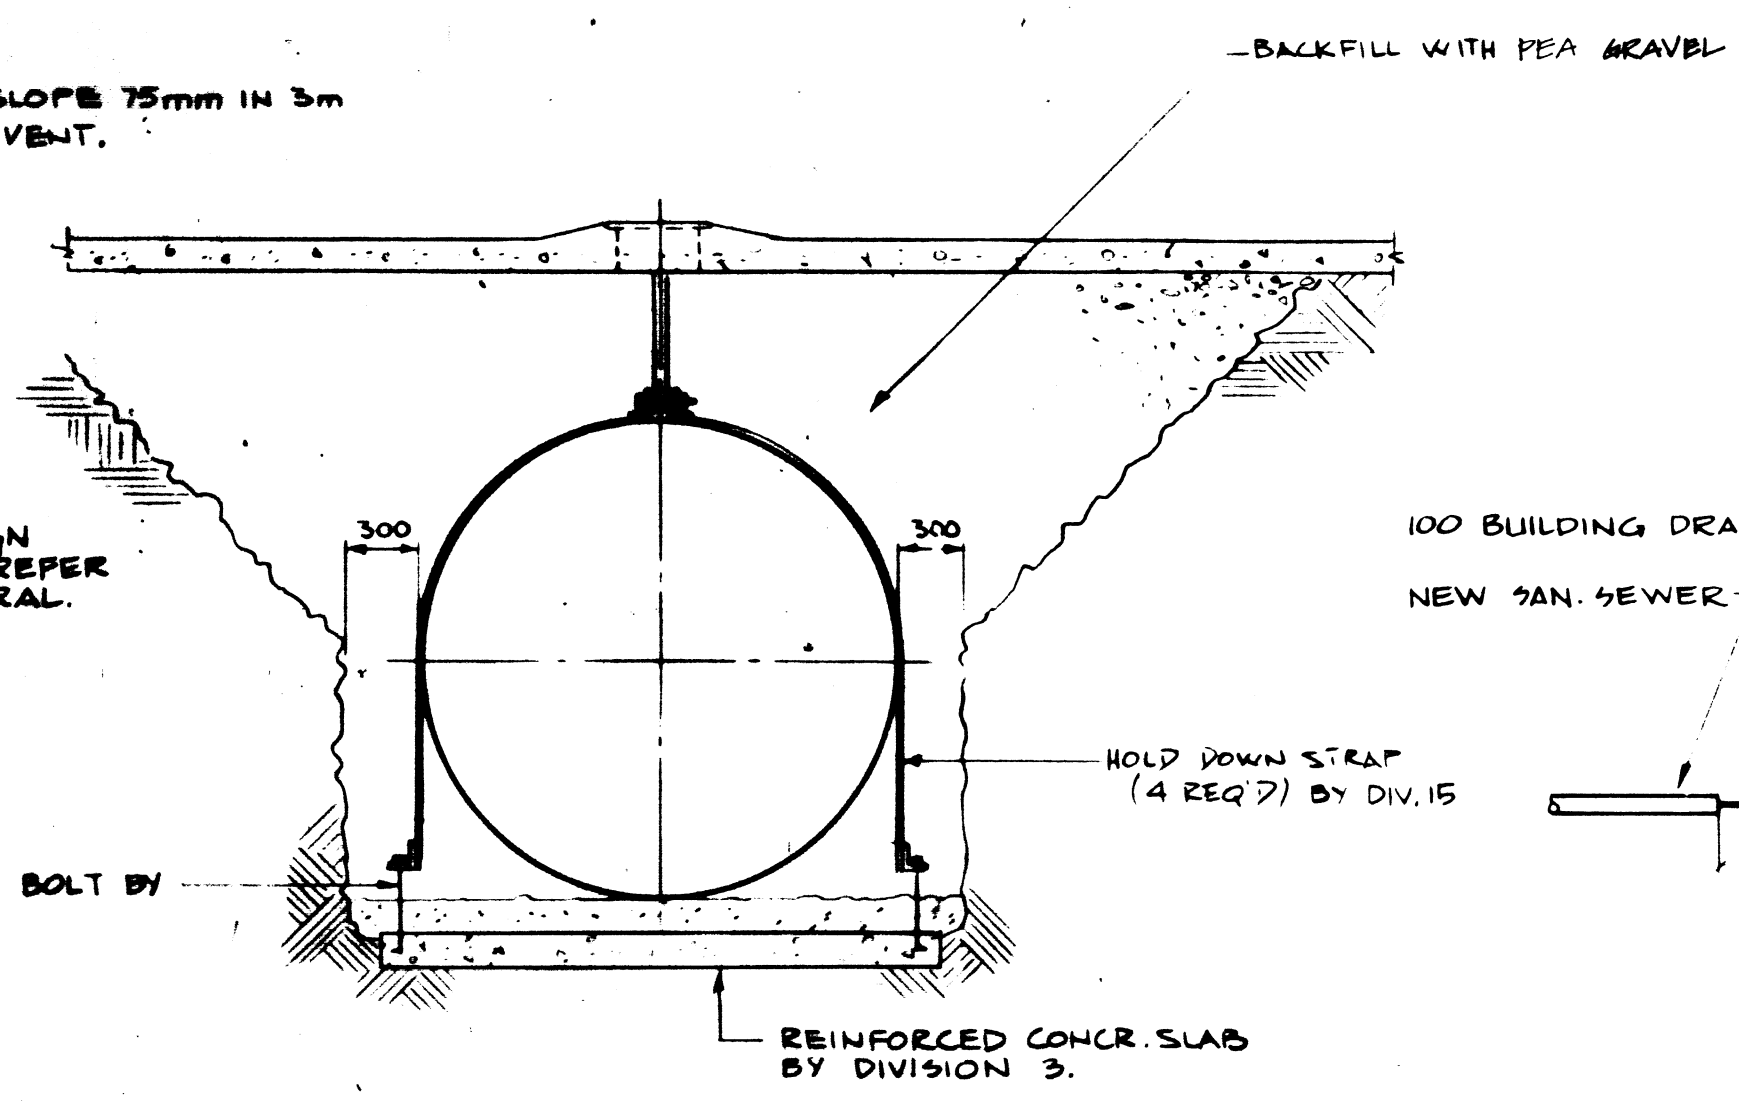


END VIEW

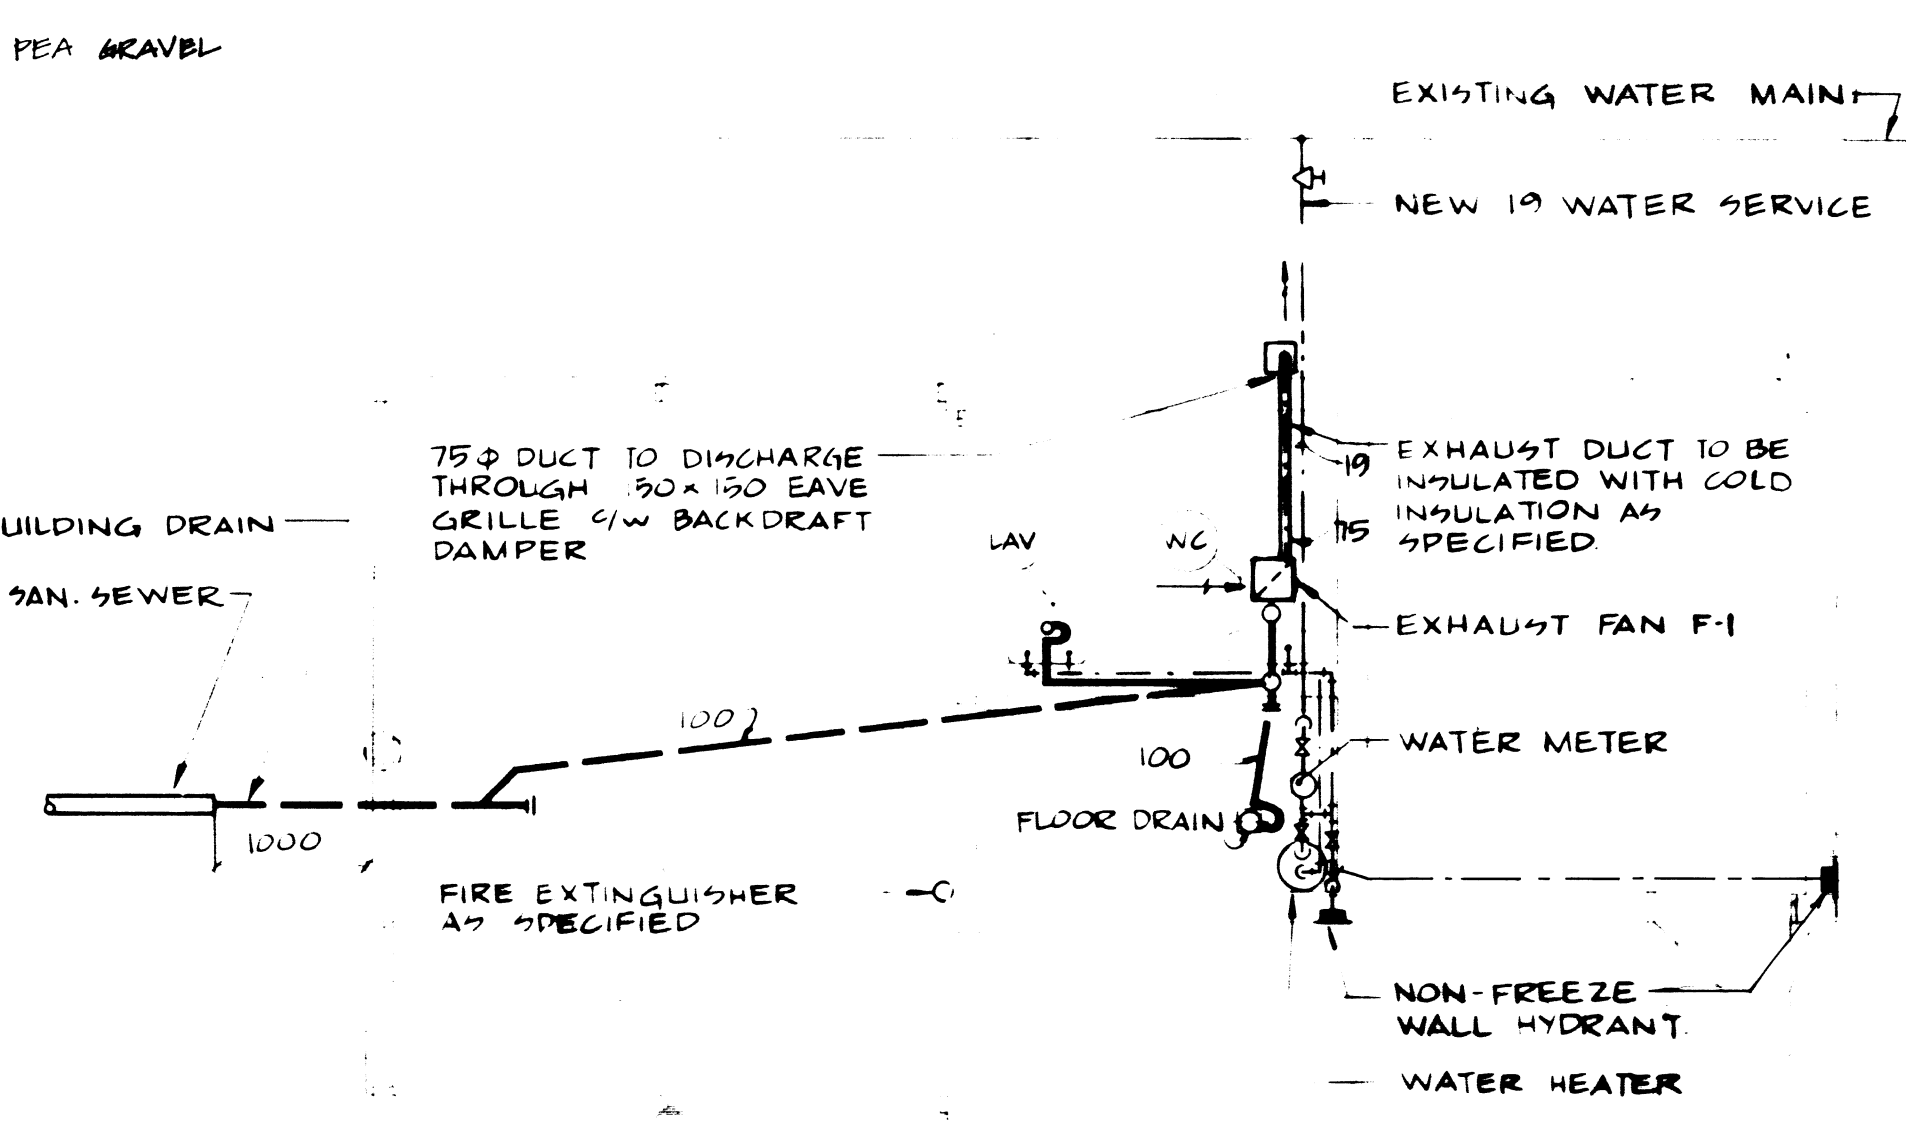


FLOOR PLAN

SCALE 1/8" = 1'-0"

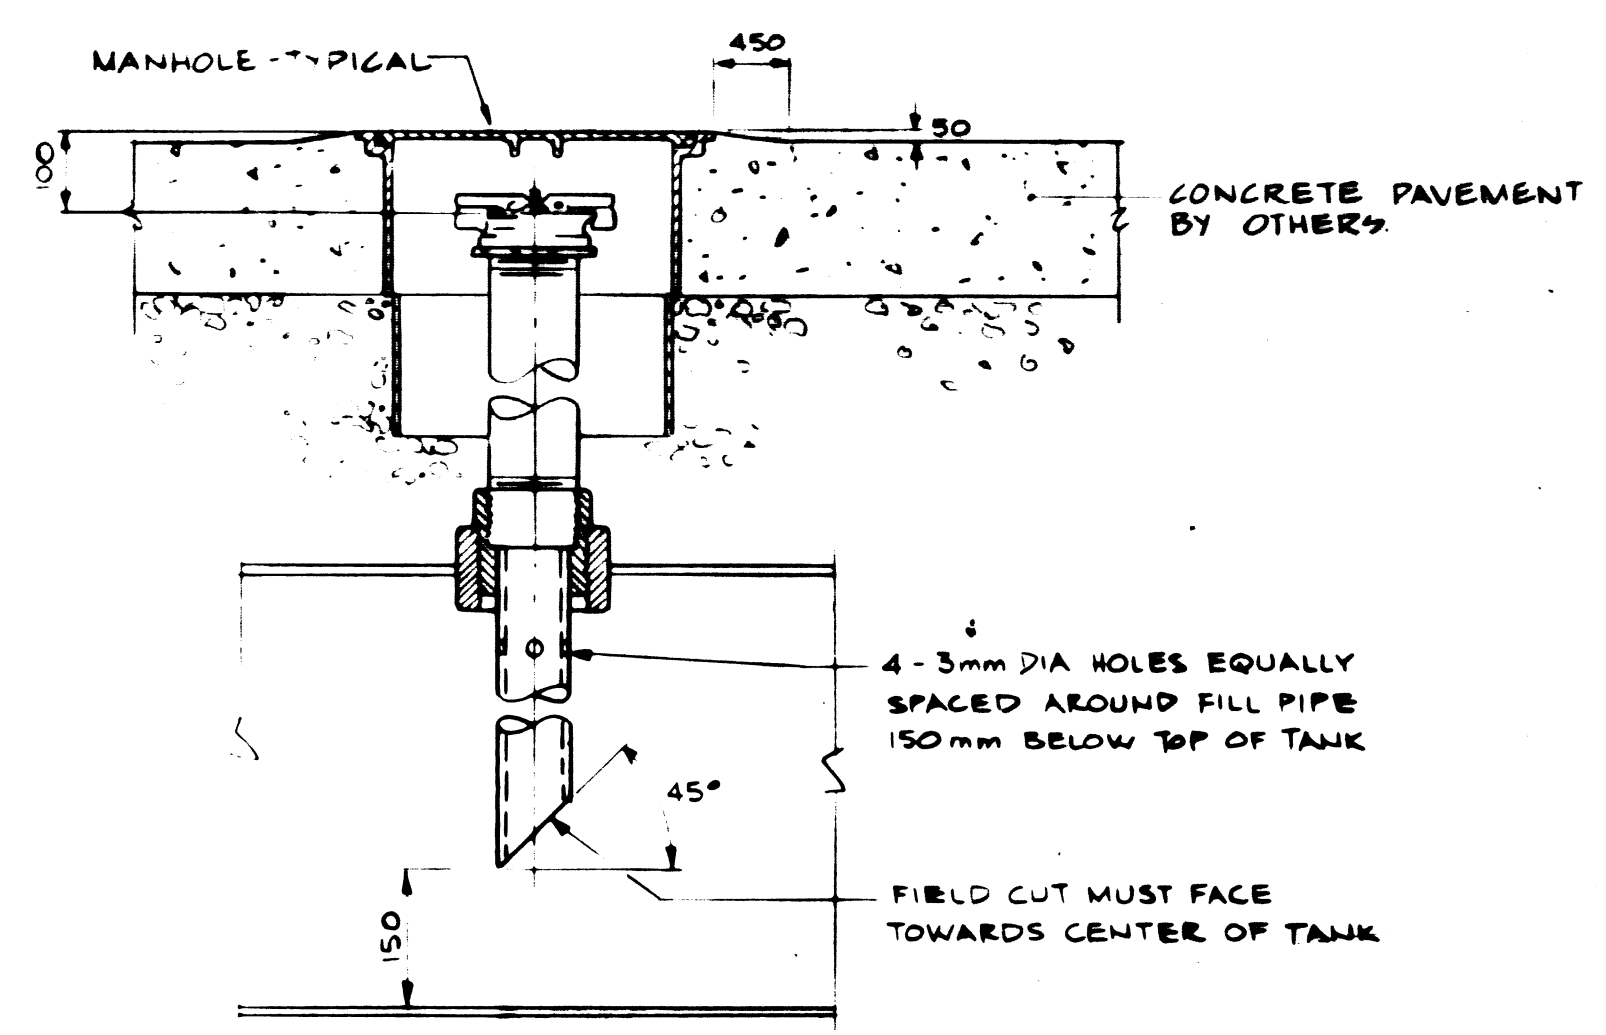


FILL PIPE DETAIL

NTS

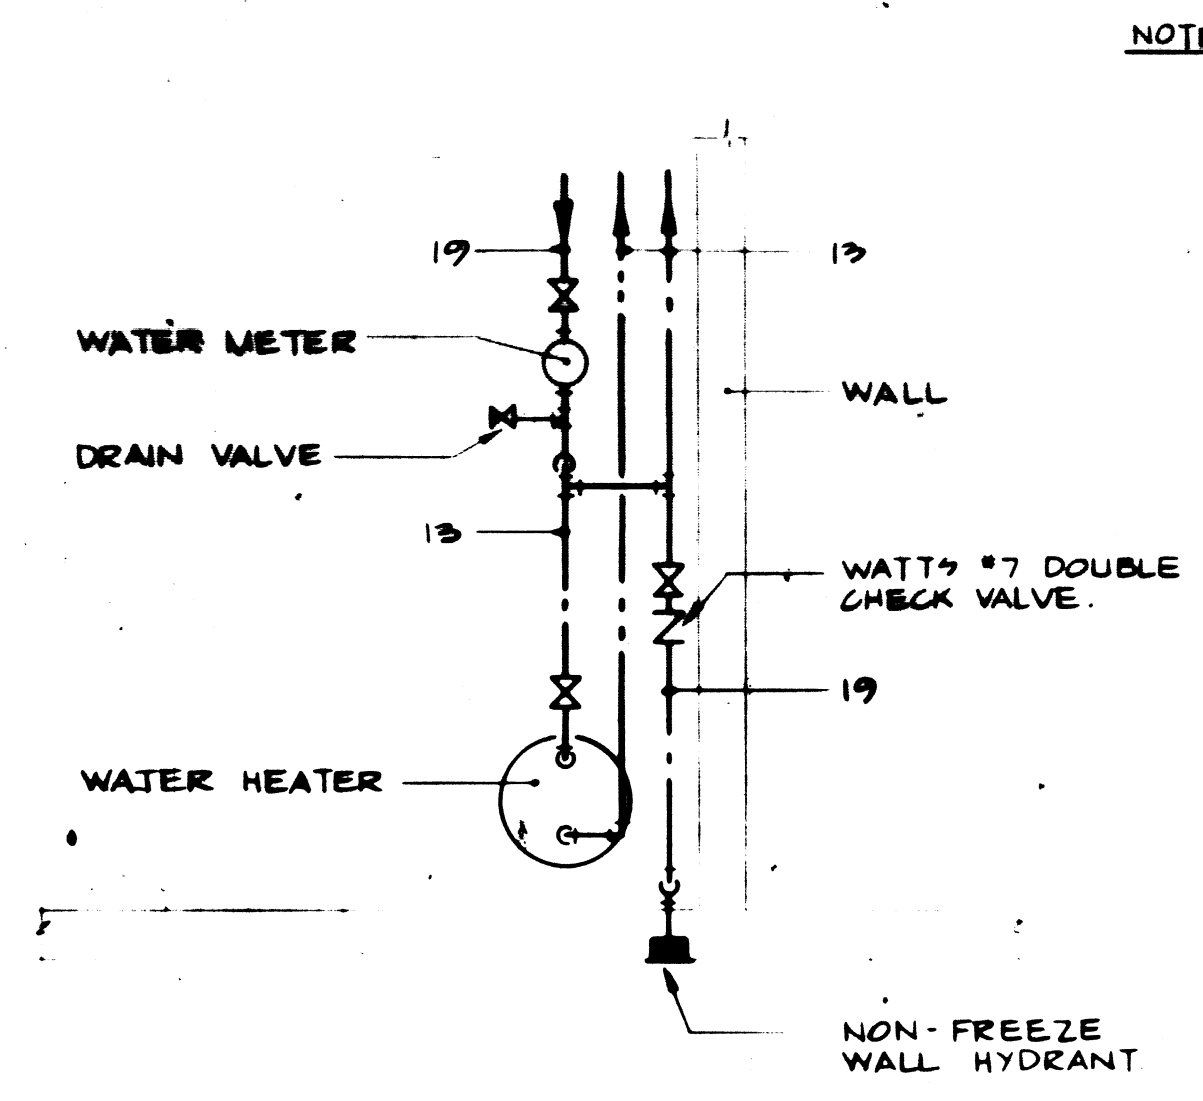

WATER PIPING DETAIL


NTS

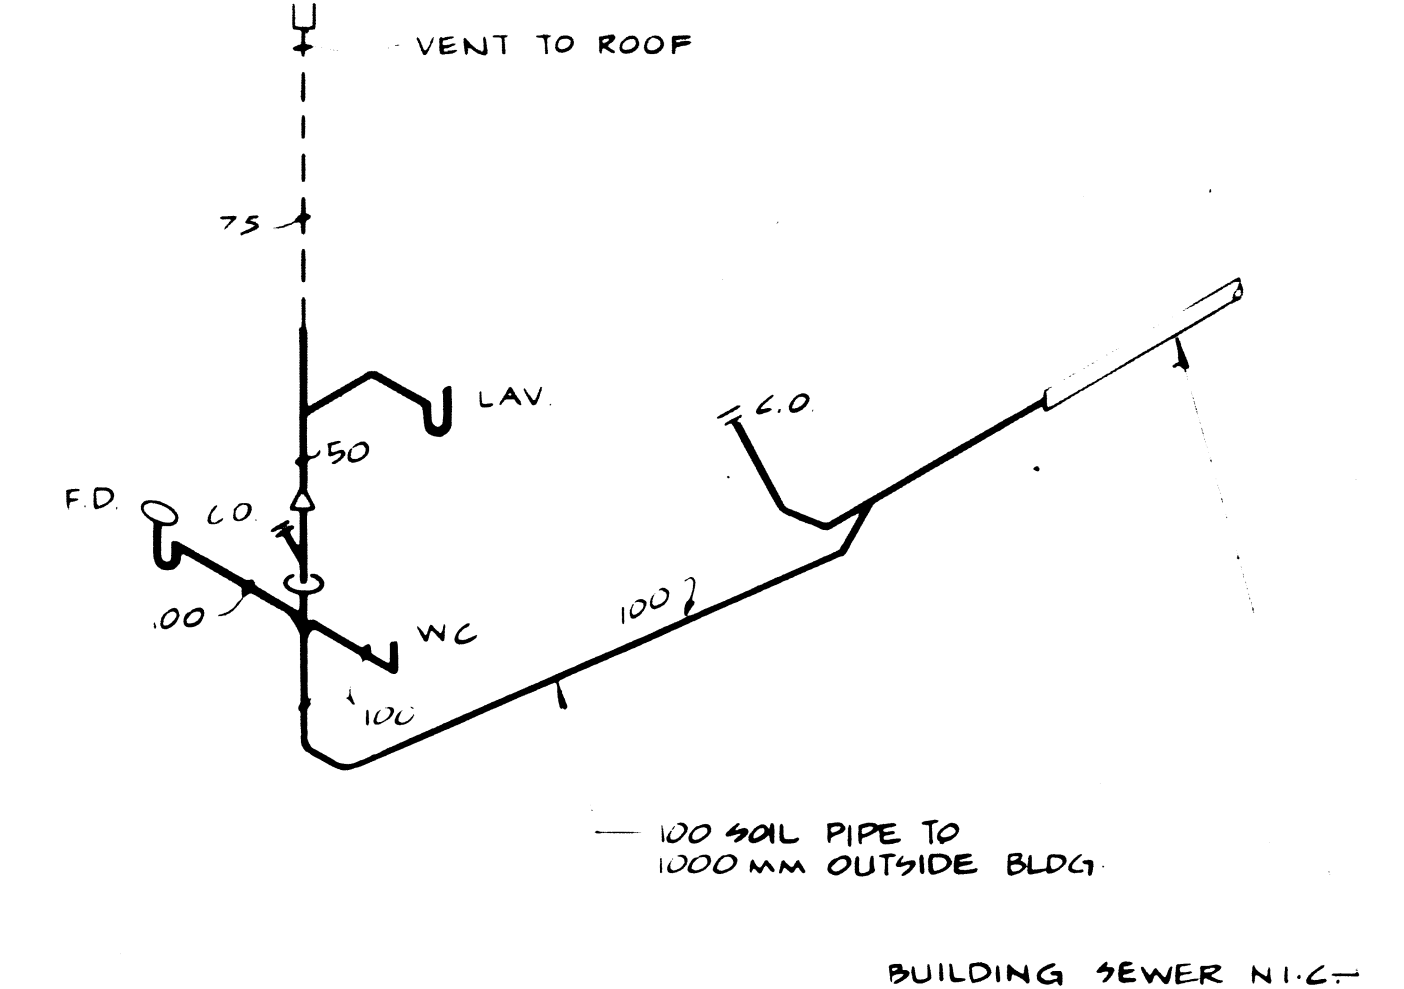

DRAINAGE DETAIL

NTS

NOTE: BACKFILL ADJACENT TO AND BEYOND FUTURE FENCE LOCATION TO BE COMPACTED CLAY AS SPECIFIED

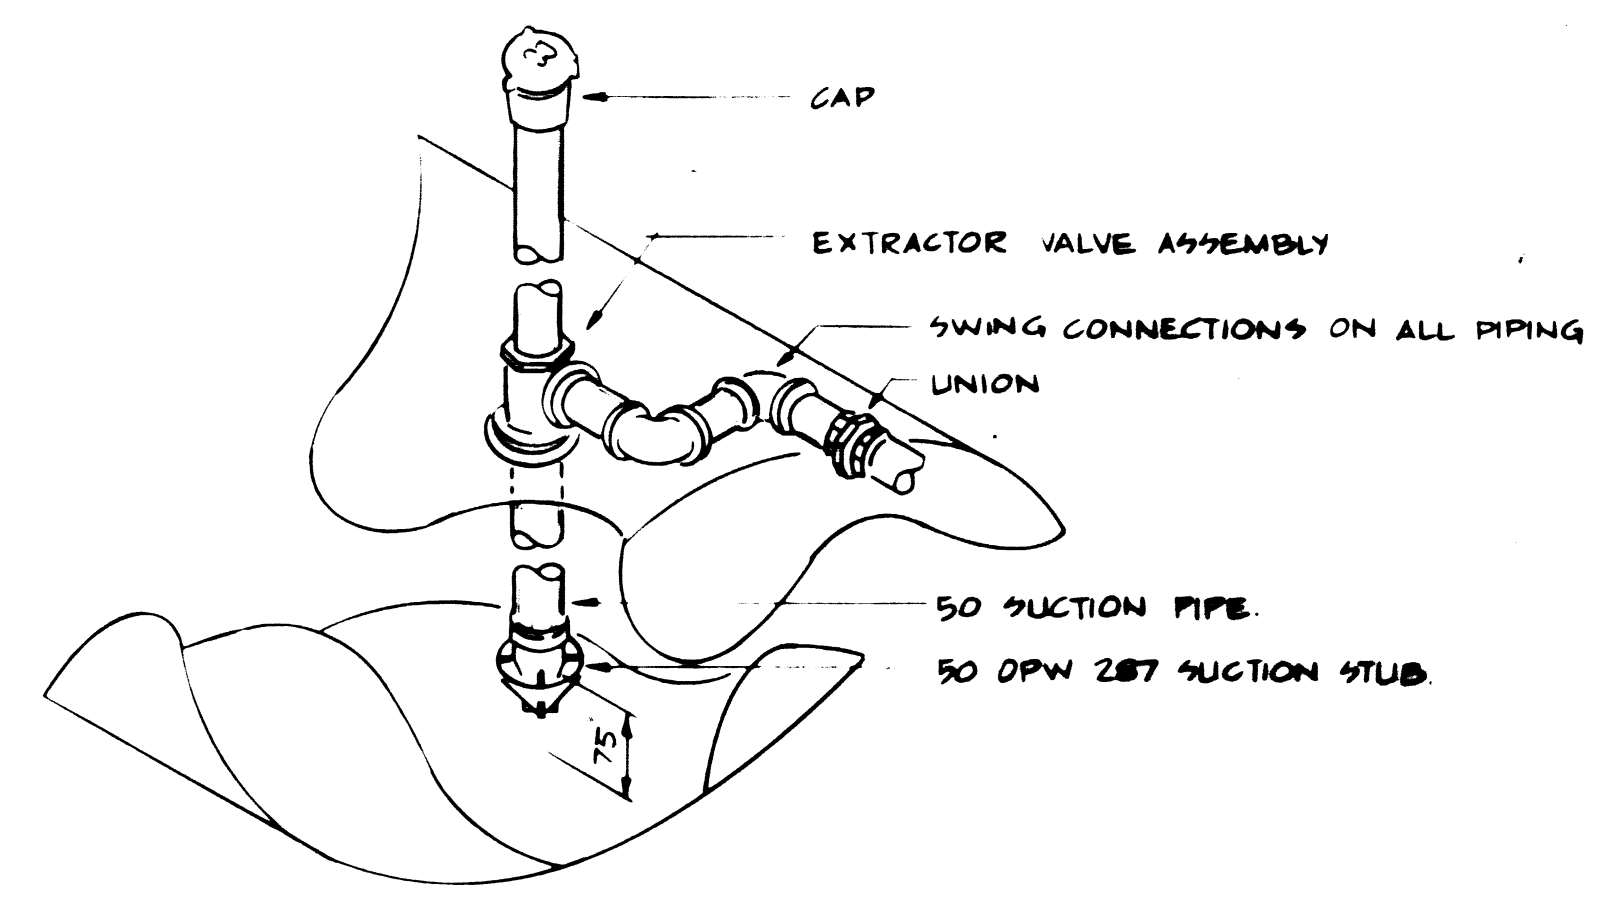

SINGLE PORT SUCTION SYSTEM

NTS

3 M2

REVISED AS CONSTRUCTED
DATE 07/2/86 BY PRAIRIE OIL
CHECKED BY B

10-059-01
Steven Michael Sigurdson
Consulting Engineers

RELEASED FOR CONSTRUCTION						IDE INTERDISCIPLINARY ENGINEERING COMPANY PROFESSIONAL ENGINEERS WINNIPEG MANITOBA				ENGINEER'S SEAL		THE CITY OF WINNIPEG CIVIC PROPERTIES DEPARTMENT	
DIRECTOR OF CIVIC PROPERTIES _____ DIRECTOR OF OPERATIONS _____ BENCH MARK: SEE DRAWING A2-67-349						DESIGNED BY K.W. CHECKED BY K.W. DATE JUNE 23, 1986		23/6/86		CENTRAL YARD REORGANIZATION PROJECT FIELD BOOK			
NO. REVISIONS DATE BY						SCALE: AS NOTED DETAIL:		APPROVED BY DATE 20.6.86		CONSULTANT PLAN NO. M2-73-349			
EXISTING	LEGEND	PROPOSED	EXISTING	LEGEND	PROPOSED					UNDERGROUND TANK DETAILS PLAN NO.			

107 TELUMSEH 2 D 86-195
 ADDRESS
 FUEL STATION M-2
 PROJECT NO.
 UNDERGROUND TANK DETAILS
 DESCRIPTION