

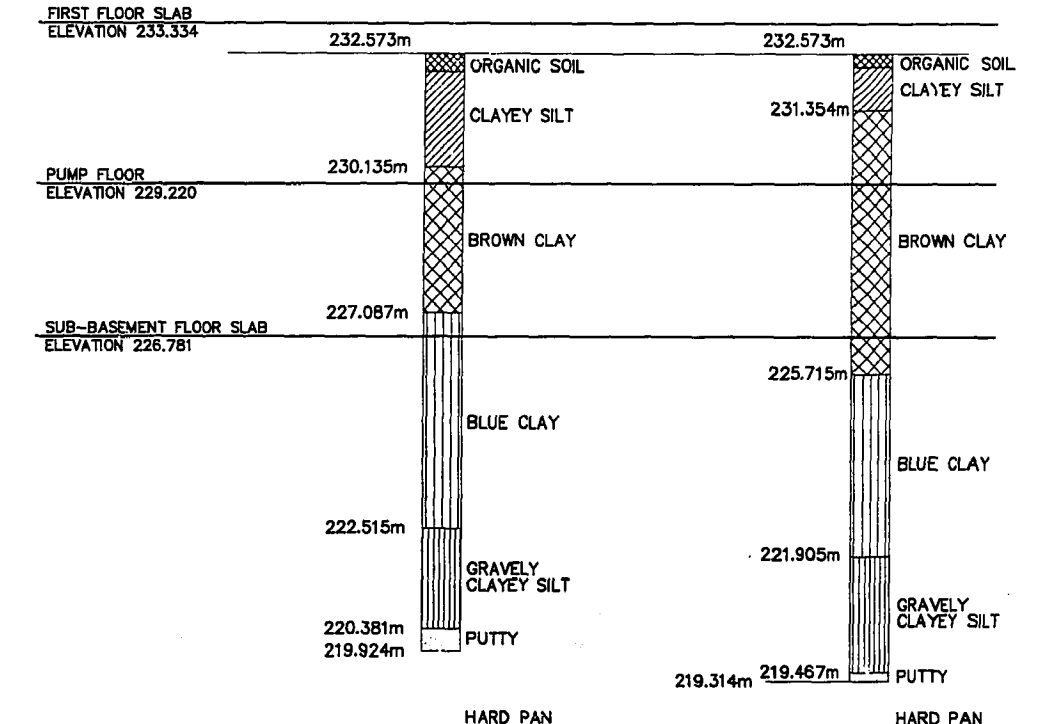


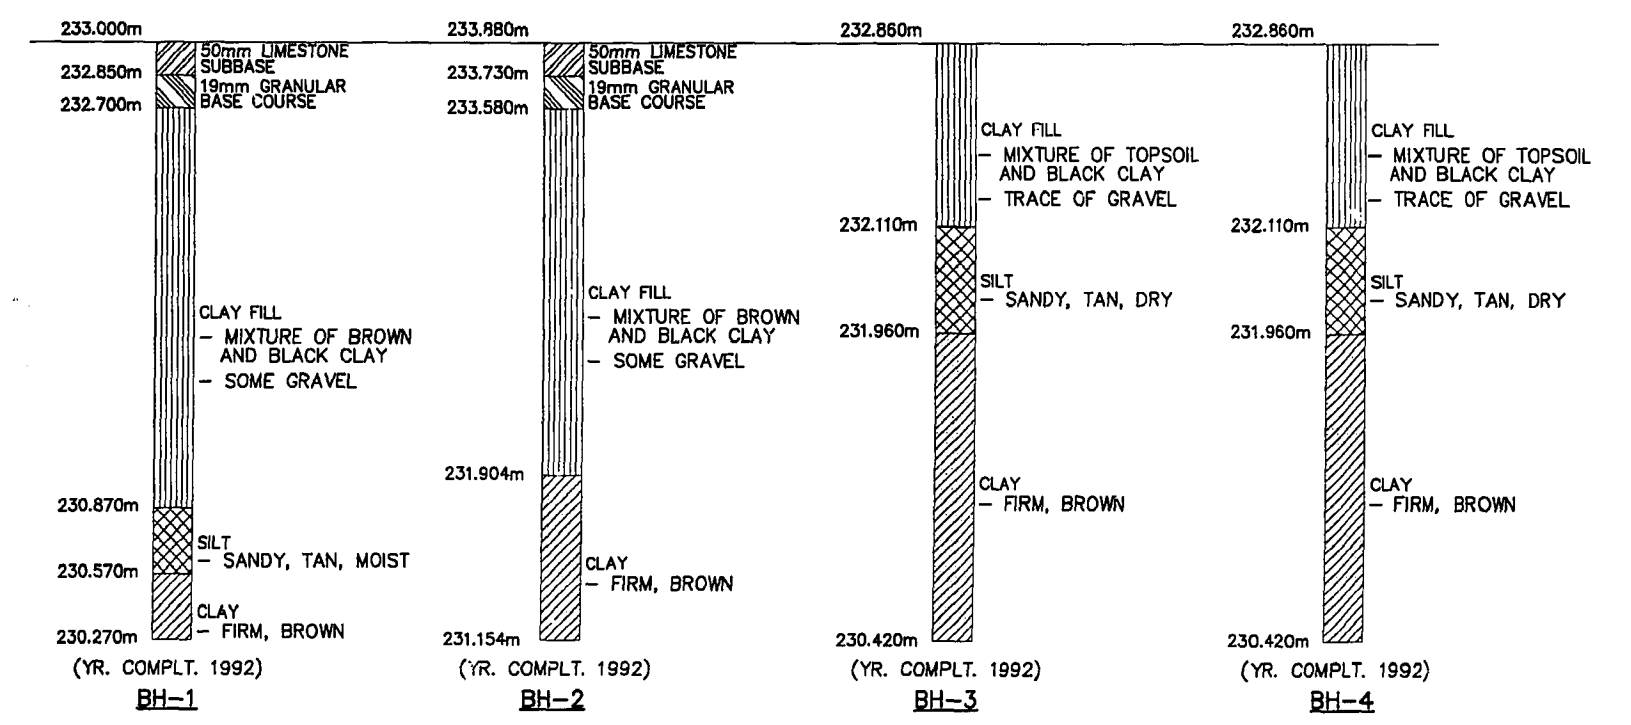

LOCATION PLAN
SCALE N.T.S.

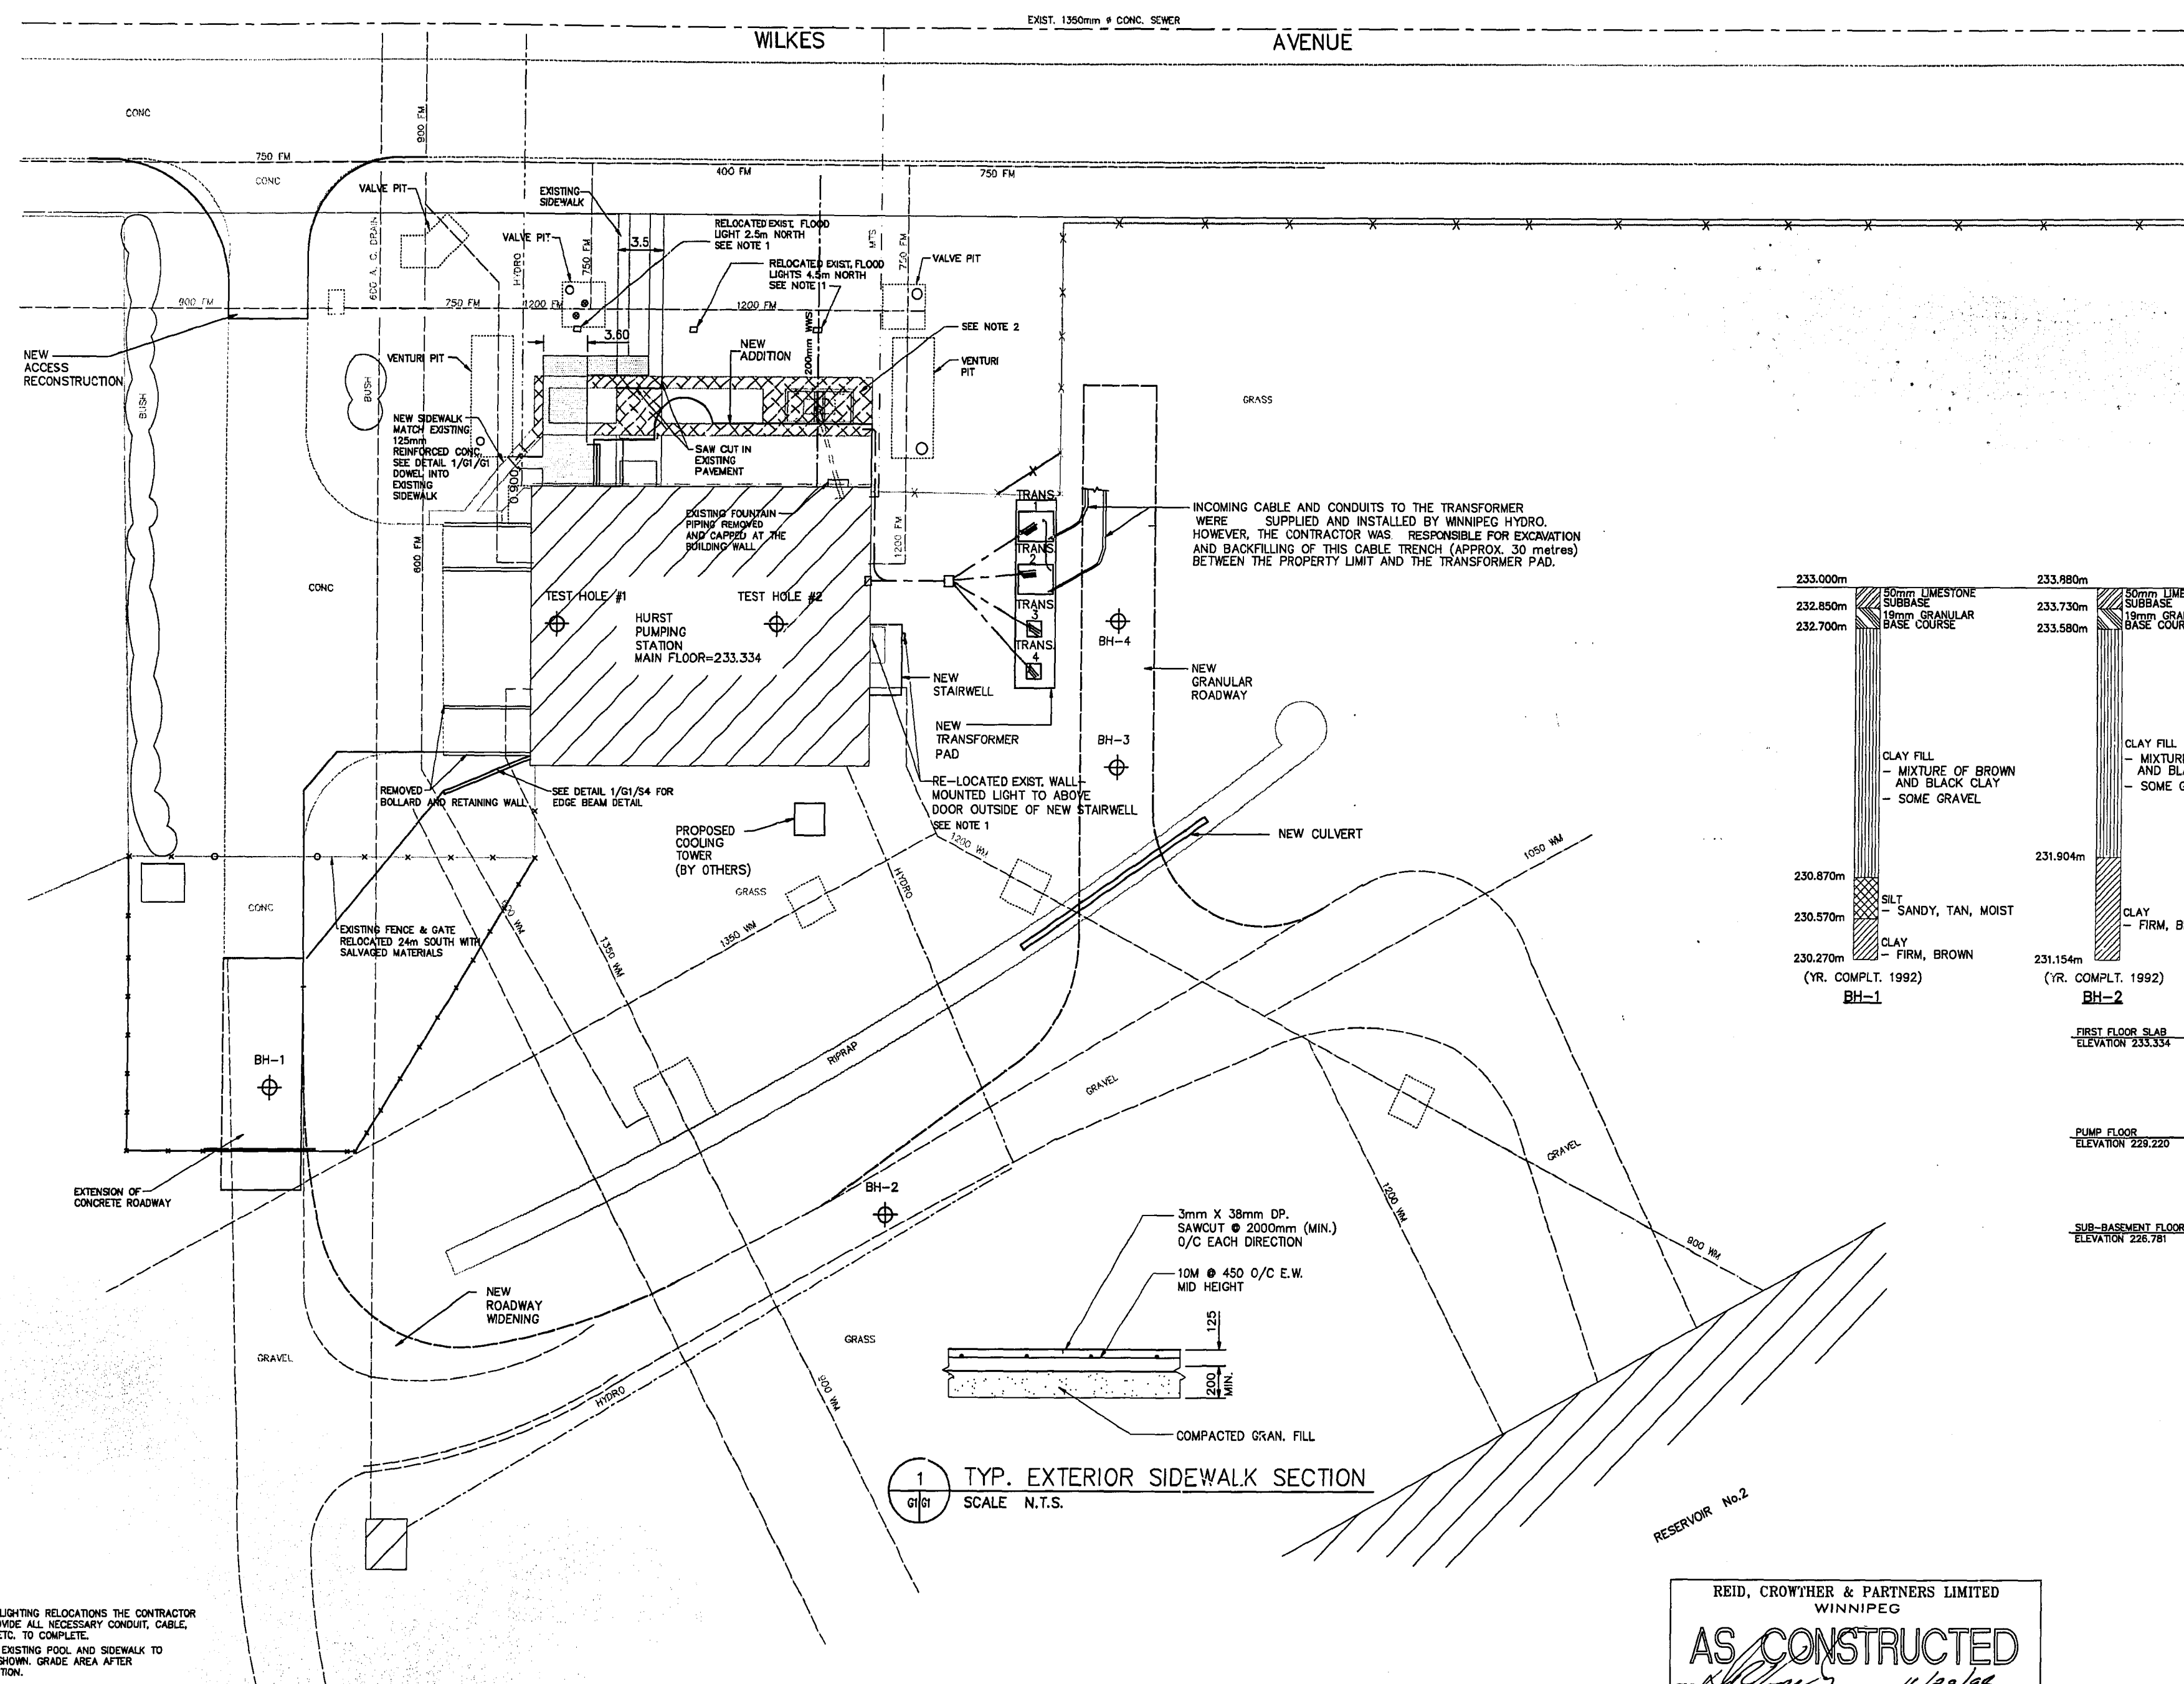

NOTE:
WATER ROSE TO 228.477m IN 24 HOURS.
TEST HOLE No. 1
(YR. COMPLT. 1959)

NOTE:
WATER ROSE TO 219.924m IN 24 HOURS.
TEST HOLE No. 2
(YR. COMPLT. 1959)

NOTE:
ANY INFORMATION PERTAINING TO SOILS AND ALL BOREHOLE AND TEST HOLE LOGS ARE FURNISHED BY THE ENGINEER AS A MATTER OF GENERAL INFORMATION ONLY AND BOREHOLE LOGS OR TEST HOLE LOGS ARE NOT TO BE INTERPRETED AS DESCRIPTIVE OF CONDITIONS AT LOCATIONS OTHER THAN THOSE DESCRIBED BY THE BOREHOLES OR TEST HOLES THEMSELVES.


SEE PLAN FOR LOCATION OF BOREHOLES OR TEST HOLES (SHOWN THUS ⊕)

1 TYP. EXTERIOR SIDEWALK SECTION
SCALE N.T.S.

NOTE:
1) FOR ANY LIGHTING RELOCATIONS THE CONTRACTOR IS TO PROVIDE ALL NECESSARY CONDUIT, CABLE, LABOUR, ETC. TO COMPLETE.
2) DEMOLISH EXISTING POOL AND SIDEWALK TO EXTENTS SHOWN. GRADE AREA AFTER CONSTRUCTION.

EXISTING SIDEWALK TO BE DEMOLISHED
NEW SIDEWALK

detail symbol
A detail number
B drawing where detail shown
C cross reference to drawing where detail taken

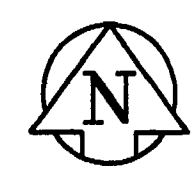

SITE PLAN
SCALE 1:250

EXISTING	LEGEND - PLAN	PROPOSED	EXISTING	LEGEND - PLAN	PROPOSED
150 mm W.M.	WATERMAIN	150 mm W.M.	SWALE		
Hydrant	HYDRANT	Valve	CULVERT		
300mm L.O.S.	LAND DRAINAGE SEWER	300mm L.O.S.	CONCRETE		
250mm W.W.S.	WASTEWATER SEWER	250mm W.W.S.	ASPHALT		
Manhole	MANHOLE	Property Line	PROPERTY LINE		
Catch Basin	CATCH BASIN	Survey Bar	SURVEY BAR		
Curb Inlet	CURB INLET	Elevation	ELEVATION	(32 750)	
Hydro	HYDRO	Tree	TREE		
M.T.S.	M.T.S.	Riprap	RIPRAP		
		Gravel	GRAVEL		
		Fence	FENCE		

LOCATION APPROVED UNDERGROUND STRUCTURES

SUPV. U/G STRUCTURES DATE COMMITTEE

NOTE:
LOCATION OF UNDERGROUND STRUCTURES AS SHOWN ARE BASED ON THE BEST INFORMATION AVAILABLE. BUT NO GUARANTEE IS GIVEN THAT ALL EXISTING UTILITIES ARE SHOWN OR THAT THE GIVEN LOCATIONS ARE EXACT. CONFIRMATION OF EXISTENCE AND EXACT LOCATION OF ALL SERVICES MUST BE OBTAINED FROM THE INDIVIDUAL UTILITIES BEFORE PROCEEDING WITH CONSTRUCTION.

S.I.M. 85-001
ELEV. 233.336m
1.3m S. OF WIRE FENCE ON S. SIDE OF WILKES AVE. 1.0m E. OF E. WALL OF PUMPING STATION 7m E. OF WIRE FENCE

REID, CROWTHER & PARTNERS LIMITED
WINNIPEG

AS CONSTRUCTED

SIG. *[Signature]* DATE 11/20/92

DESIGNED BY	JNH	CHECKED BY	
DRAWN BY	BC/GGB	APPROVED BY	
HOR. SCALE:	AS NOTED	RELEASED FOR BID:	
NO. REVISIONS		DATE	93-01-13

IN ASSOCIATION WITH

Black & Veatch

ENGINEER'S SEAL
PROFESSIONAL ENGINEER
D.R.
DATE 02-03-93
REGISTERED PROFESSIONAL ENGINEER

CONSULTANT DRAWING NO.
61370 - C4-G1

THE CITY OF WINNIPEG
WORKS AND OPERATIONS DIVISION
WATERWORKS WASTE AND DISPOSAL DEPT.

REGIONAL WATER SUPPLY SYSTEM
INSTRUMENTATION, CONTROL AND DATA ACQUISITION
CONTRACT 4 - EXPANSION TO
W.D. HURST PUMPING STATION

CITY DRAWING NUMBER
SHEET OF
HURST25

FILE # WP10549