


- NOTES:
- REUSE WIRING AS REQUIRED FOR NEW CHEMICAL TREATMENT SYSTEM (120V).
- GENERAL NOTES:
- REFER TO DRAWING E-004 TO PROVIDE AND INSTALL ALL NEW ELECTRICAL EQUIPMENT AS REQUIRED.
  - RUN NEW CABLES AND CONDUITS BETWEEN EQUIPMENT ON THE EXISTING UNISTRUT SUPPORT AND ADD NEW UNISTRUT SUPPORT AS REQUIRED.
  - MOUNT TR-NPP-1 ON THE WALL ABOVE THE PANEL NPP-1.
  - DISCONNECT COMMUNICATION CABLES FROM EQUIPMENT IN CONTROL OFFICE AND PULL CABLES OUT OF CONDUIT THROUGH THE PULL BOX. COORDINATE WITH DIVISION 23 AND RE-ROUTE CONDUIT 100mm ABOVE THE Ø250 MECHANICAL PIPES. RE-PULL THE CABLES BACK INTO THE CONDUIT AND RE-CONNECT CABLES TO EQUIPMENT.


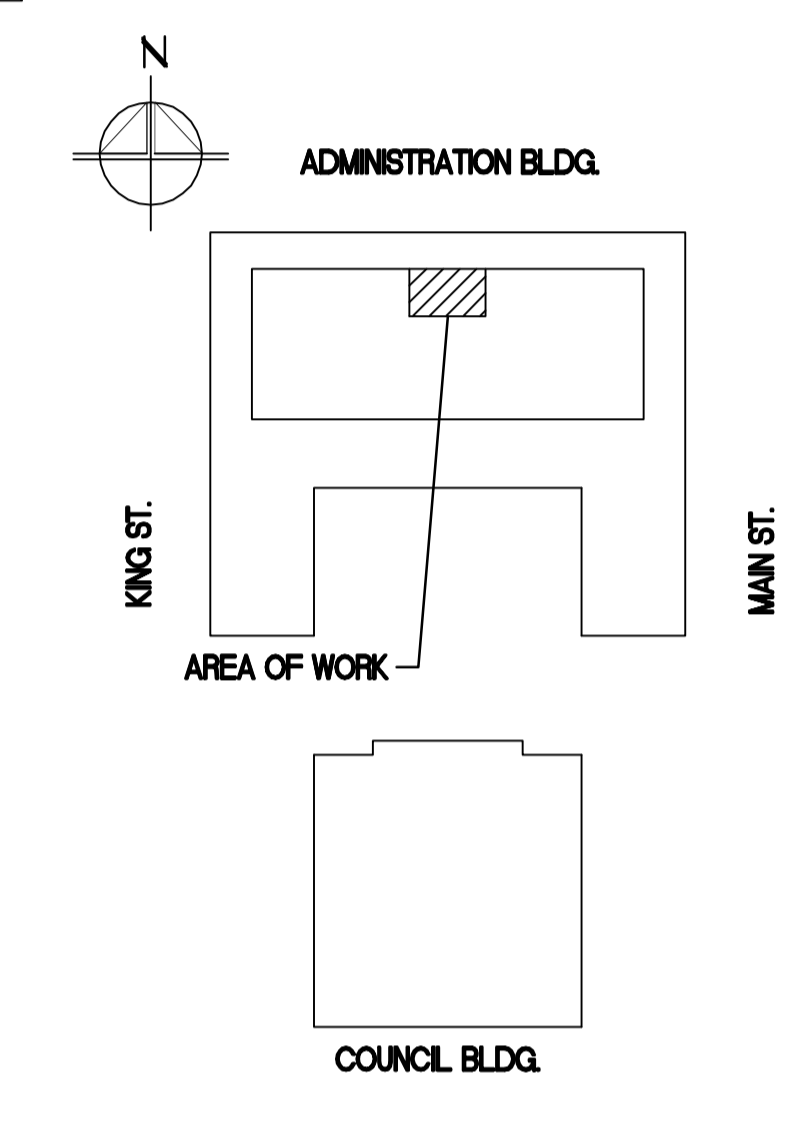


**AECOM**

This drawing has been prepared for the use of AECOM's client and may not be used, reproduced or relied upon by third parties, except as agreed by AECOM and its client, as required by law or for use by governmental reviewing agencies. AECOM accepts no responsibility, and denies any liability whatsoever, to any party that modifies this drawing without AECOM's express written consent. Do not scale this document. All measurements must be obtained from stated dimensions.

No.	REVISION/DESCRIPTION	BY	DATE
1	ISSUED FOR ADDENDUM 1	SS	2011.11.19
0	ISSUED FOR TENDER	SS	2011.11.09

SEAL

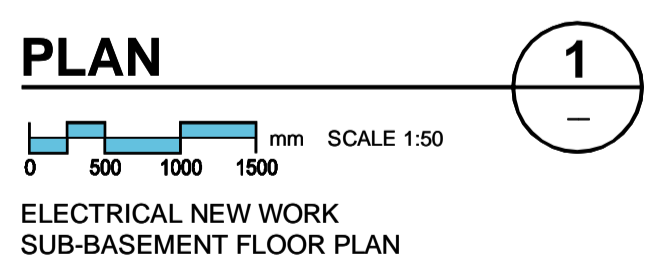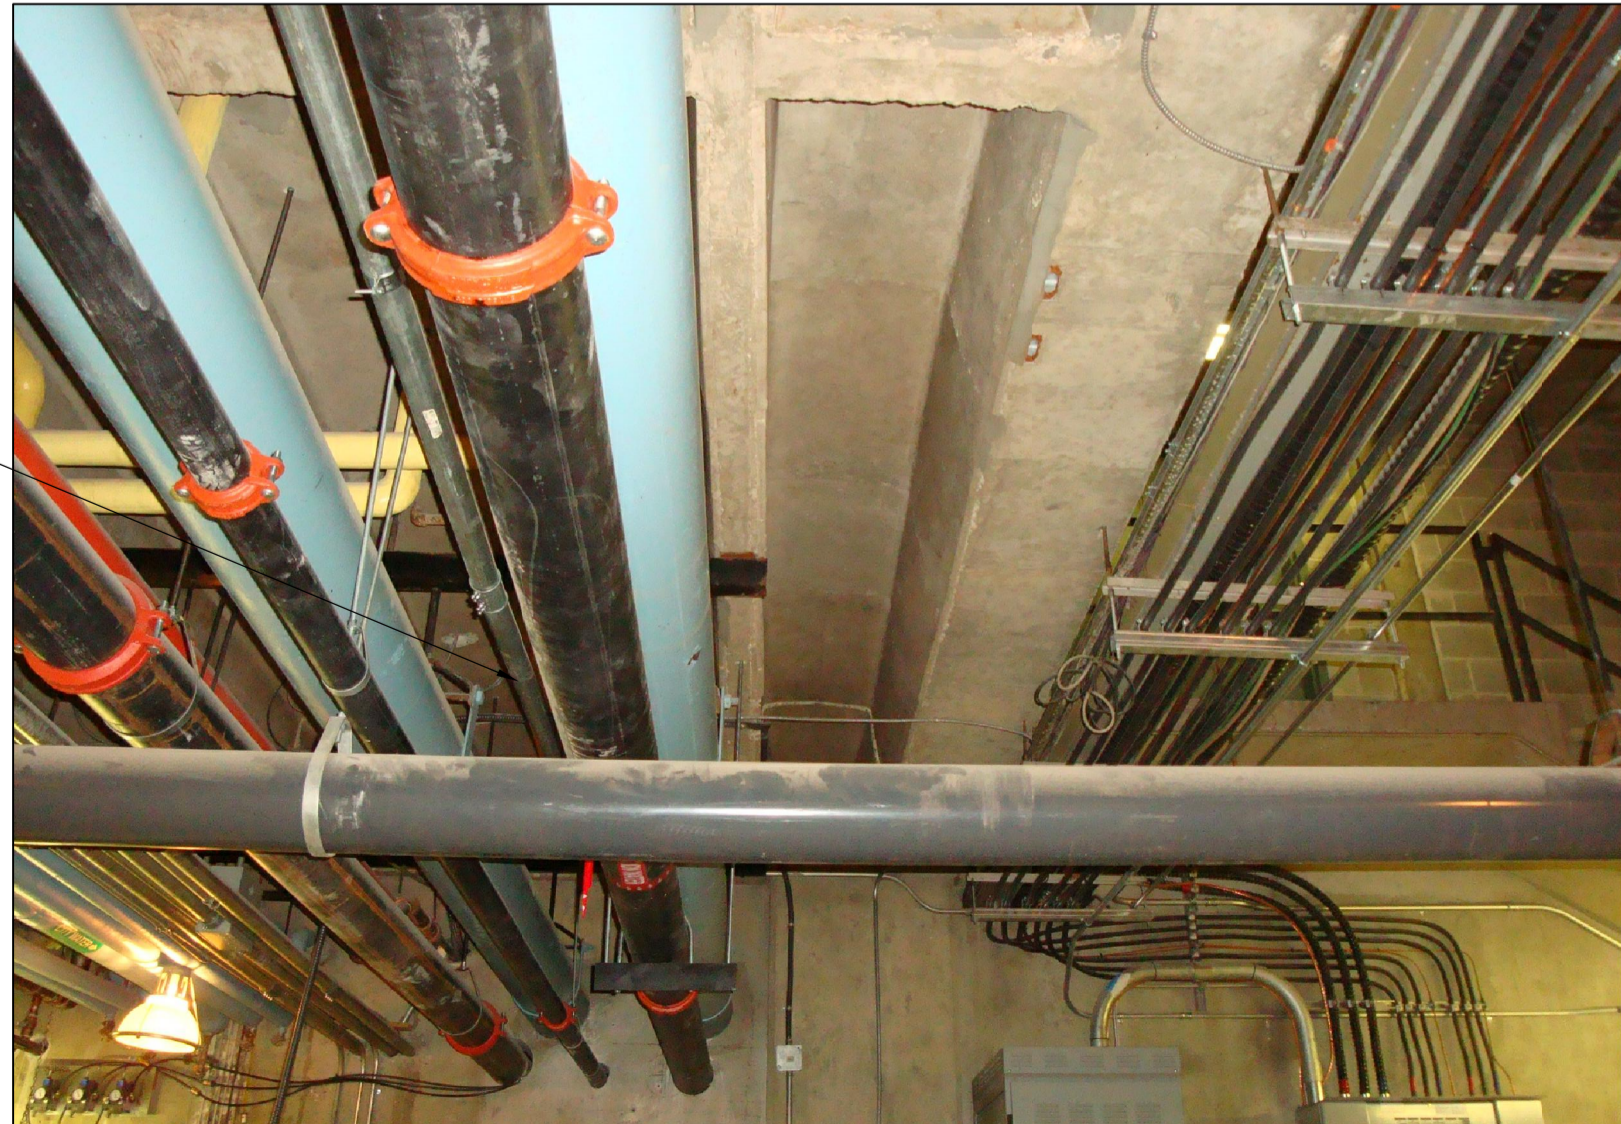

**APEGN**  
Certificate of Authorization  
AECOM Canada Ltd.  
No. 4671 Date: \_\_\_\_\_

DRN	CHK	DES	ENG	IDR
AECOM REVIEW				

DRAWN	QC	CHECKED	AL	DESIGNED	QC	APPROVED	SS
DATE	2011.09.02	USER APPROVAL					

THE CITY OF WINNIPEG  
PLANNING, PROPERTY AND DEVELOPMENT DEPARTMENT  
MUNICIPAL ACCOMMODATIONS DIVISION  
3-65 GARRY STREET, R3C 4K4

PROJECT  
ADMINISTRATION & COUNCIL BUILDING  
REPLACEMENT OF COOLING PLANT - 510 MAIN STREET  
BID OPPORTUNITY NO. 673-2011  
510 MAIN STREET, WINNIPEG, MANITOBA

SHEET TITLE  
**ELECTRICAL NEW WORK SUB-BASEMENT FLOOR PLAN**

SCALE	PROJECT No:	SHEET No:
1:50	60220937	E-003

DRAWING SHEET SIZE: A1 (841mm x 594mm) PLOT 1:1