



REF. or DRAWING NO. NEP 1104  
**DETAILS OVERALL SITE PLAN**

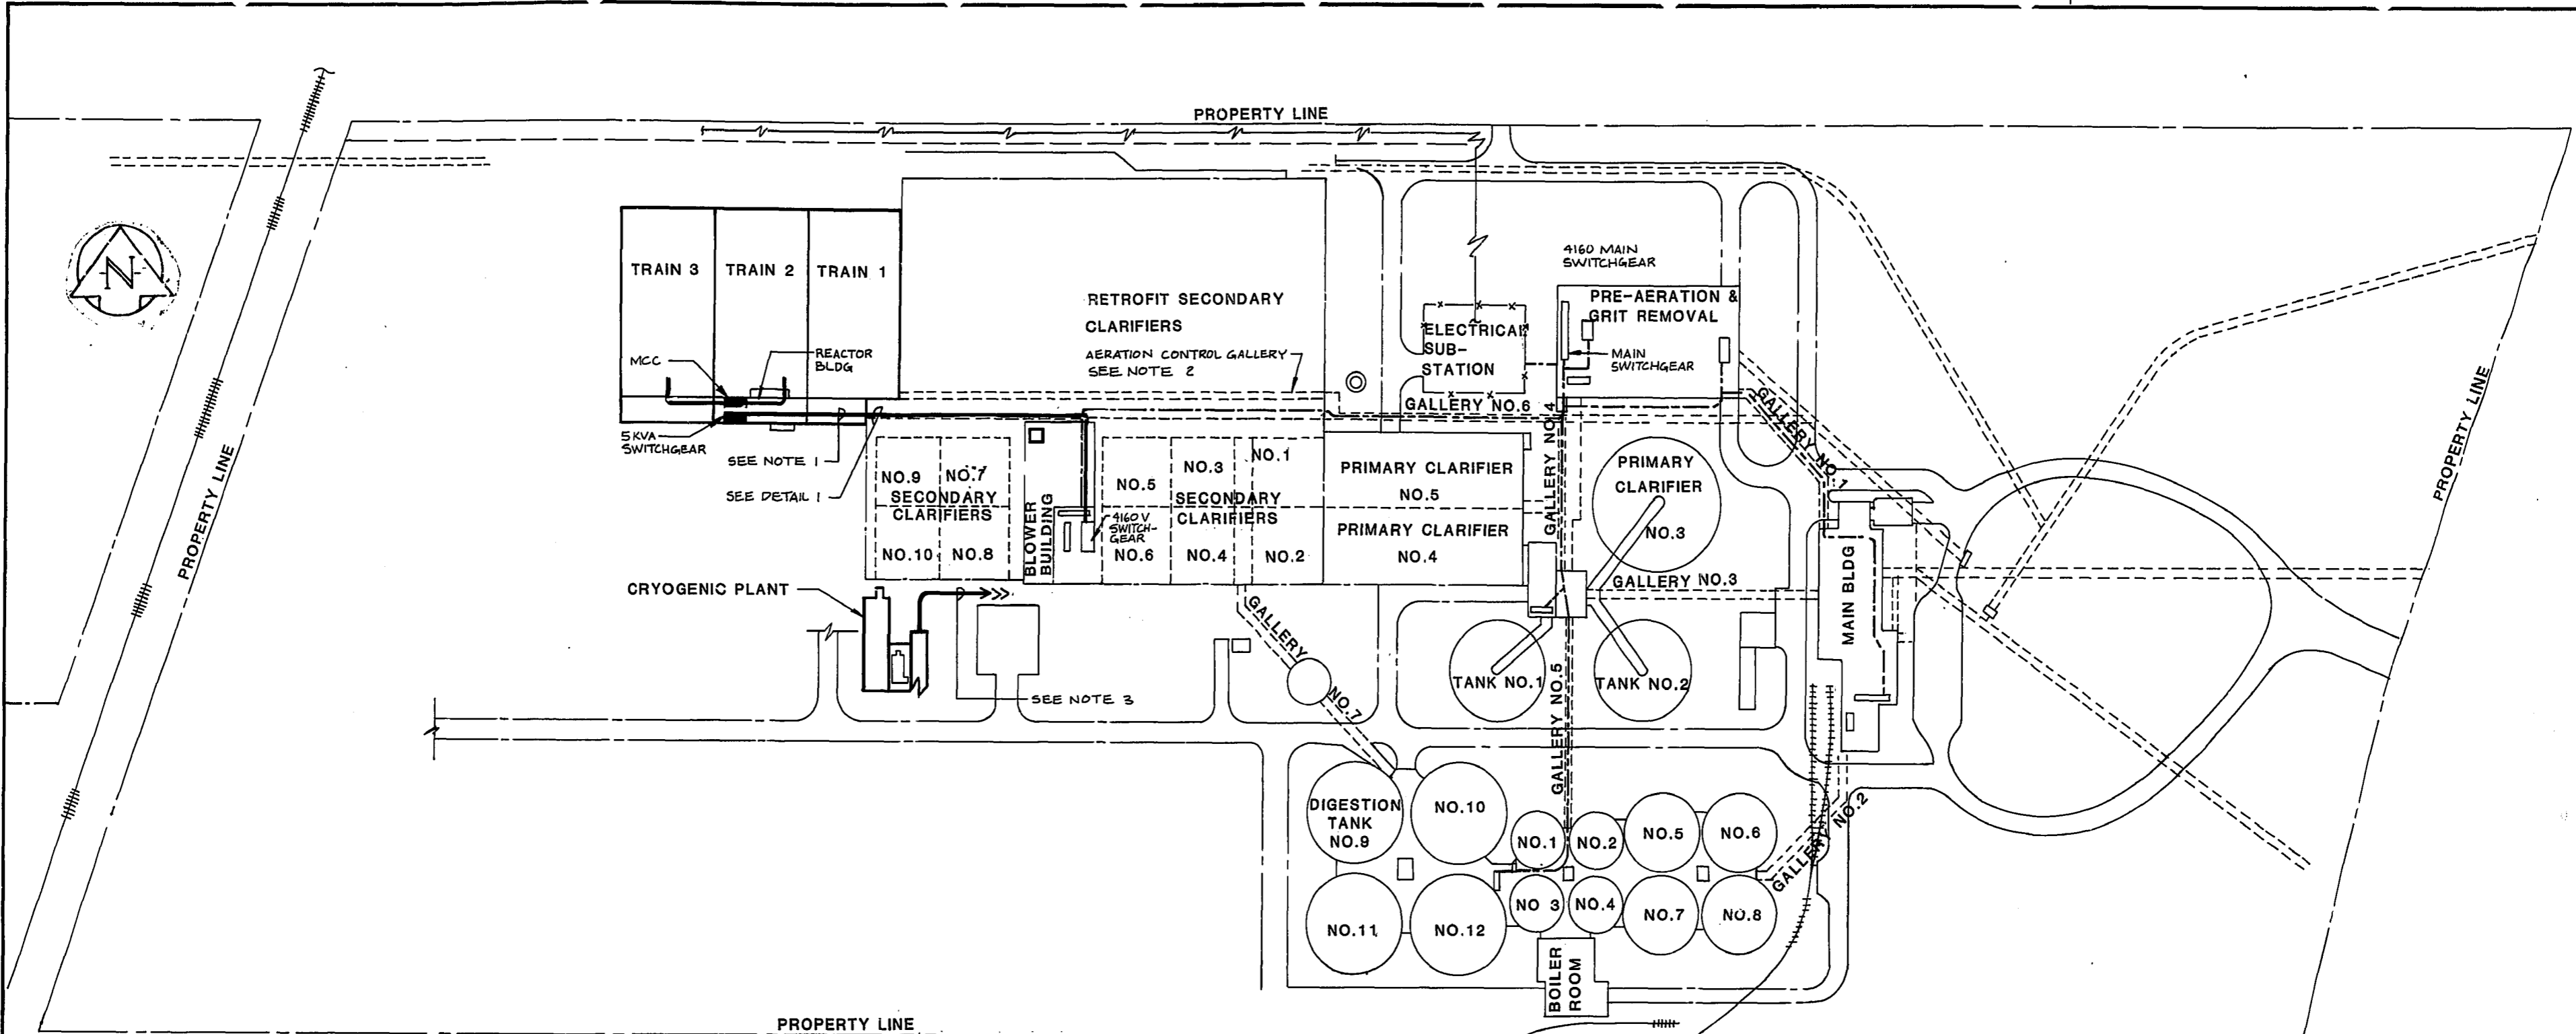


**SITE PLAN**  
 SCALE 1:1250

- LEGEND**
- INDICATES FEEDERS TO BE SUPPLIED UNDER THIS CONTRACT.
  - - - INDICATES FUTURE FEEDERS
  - INDICATES EXISTING FEEDERS

- NOTES:**
1. FOR NEW GALLERY LAYOUT AND CABLE TRAY REROUTING SEE DRAWING E308.
  2. CABLE TRAYS AND CABLES IN THIS AREA TO BE SUPPLIED UNDER CONTRACT 8.
  3. CONCRETE INCASED DUCT AND CABLES TO BE SUPPLIED UNDER ANOTHER CONTRACT.

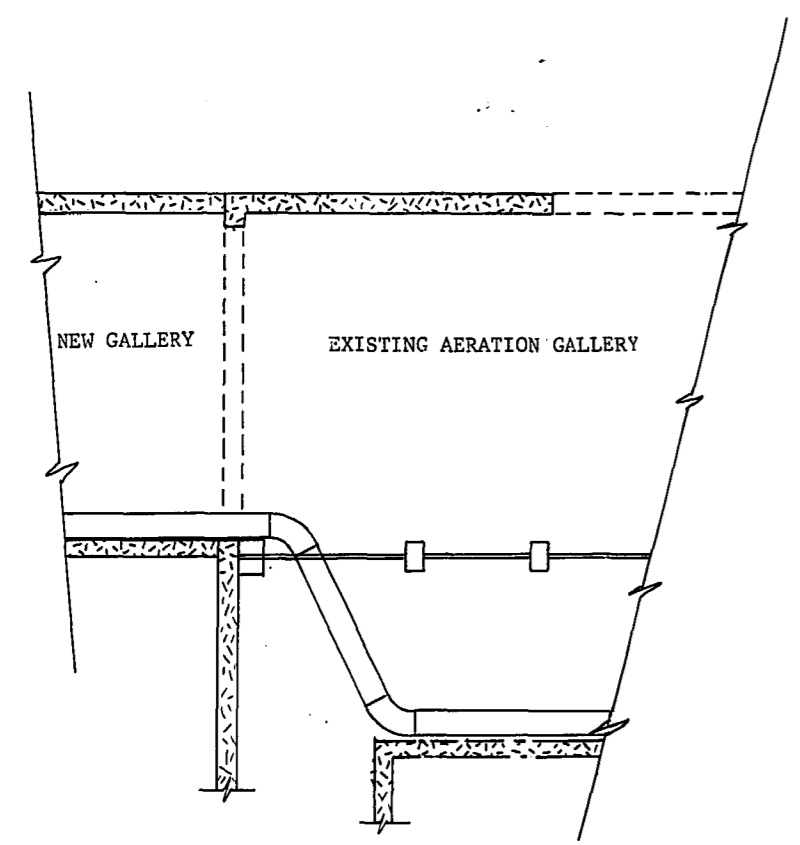

**DETAIL 1**  
 SCALE 1:100

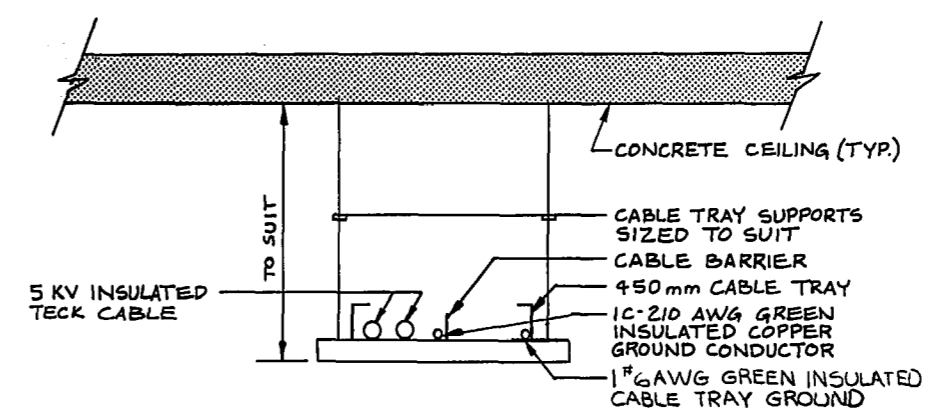

**CABLE TRAY DETAIL**  
 (TYPICAL)  
 NTS

REVISED AS CONSTRUCTED  
 DATE 85-01-04 BY D.N.  
 CHECKED BY *[Signature]*

**METRIC**  
 WHOLE NUMBERS INDICATE MILLIMETRES  
 DECIMALIZED NUMBERS INDICATE METRES

| NO. | REVISIONS              | DATE     | APP.        |
|-----|------------------------|----------|-------------|
| 2   | REVISED TO AS-BUILT    | 85-01-04 | [Signature] |
| 1   | ISSUED FOR TENDER      | 82-10-08 | [Signature] |
| 0   | ISSUED FOR CITY REVIEW | 82-10-15 | [Signature] |



W.L. WARDROP & ASSOCIATES LTD.  
 MacLAREN ENGINEERS INC.

DESIGNED BY: IP/WRB  
 DRAWN BY: SM

CHECKED BY: WRB  
 DATE: 82-10-08

APPROVED BY: *[Signature]* DATE: Dec/82

**THE CITY OF WINNIPEG**  
 WORKS & OPERATIONS DIVISION  
 WATERWORKS, WASTE & DISPOSAL DEPARTMENT

NORTH END WATER POLLUTION CONTROL CENTRE  
 SECONDARY TREATMENT EXPANSION  
**OXYGEN REACTOR TANKS ELECTRICAL**  
 OVERALL SITE PLAN

RELEASED FOR CONSTRUCTION DATE: 1982-11-29  
 SCALE: AS SHOWN  
 DRAWING NO.: NEP 1104