



2 TYP SECTION
WS-B0110 1:25

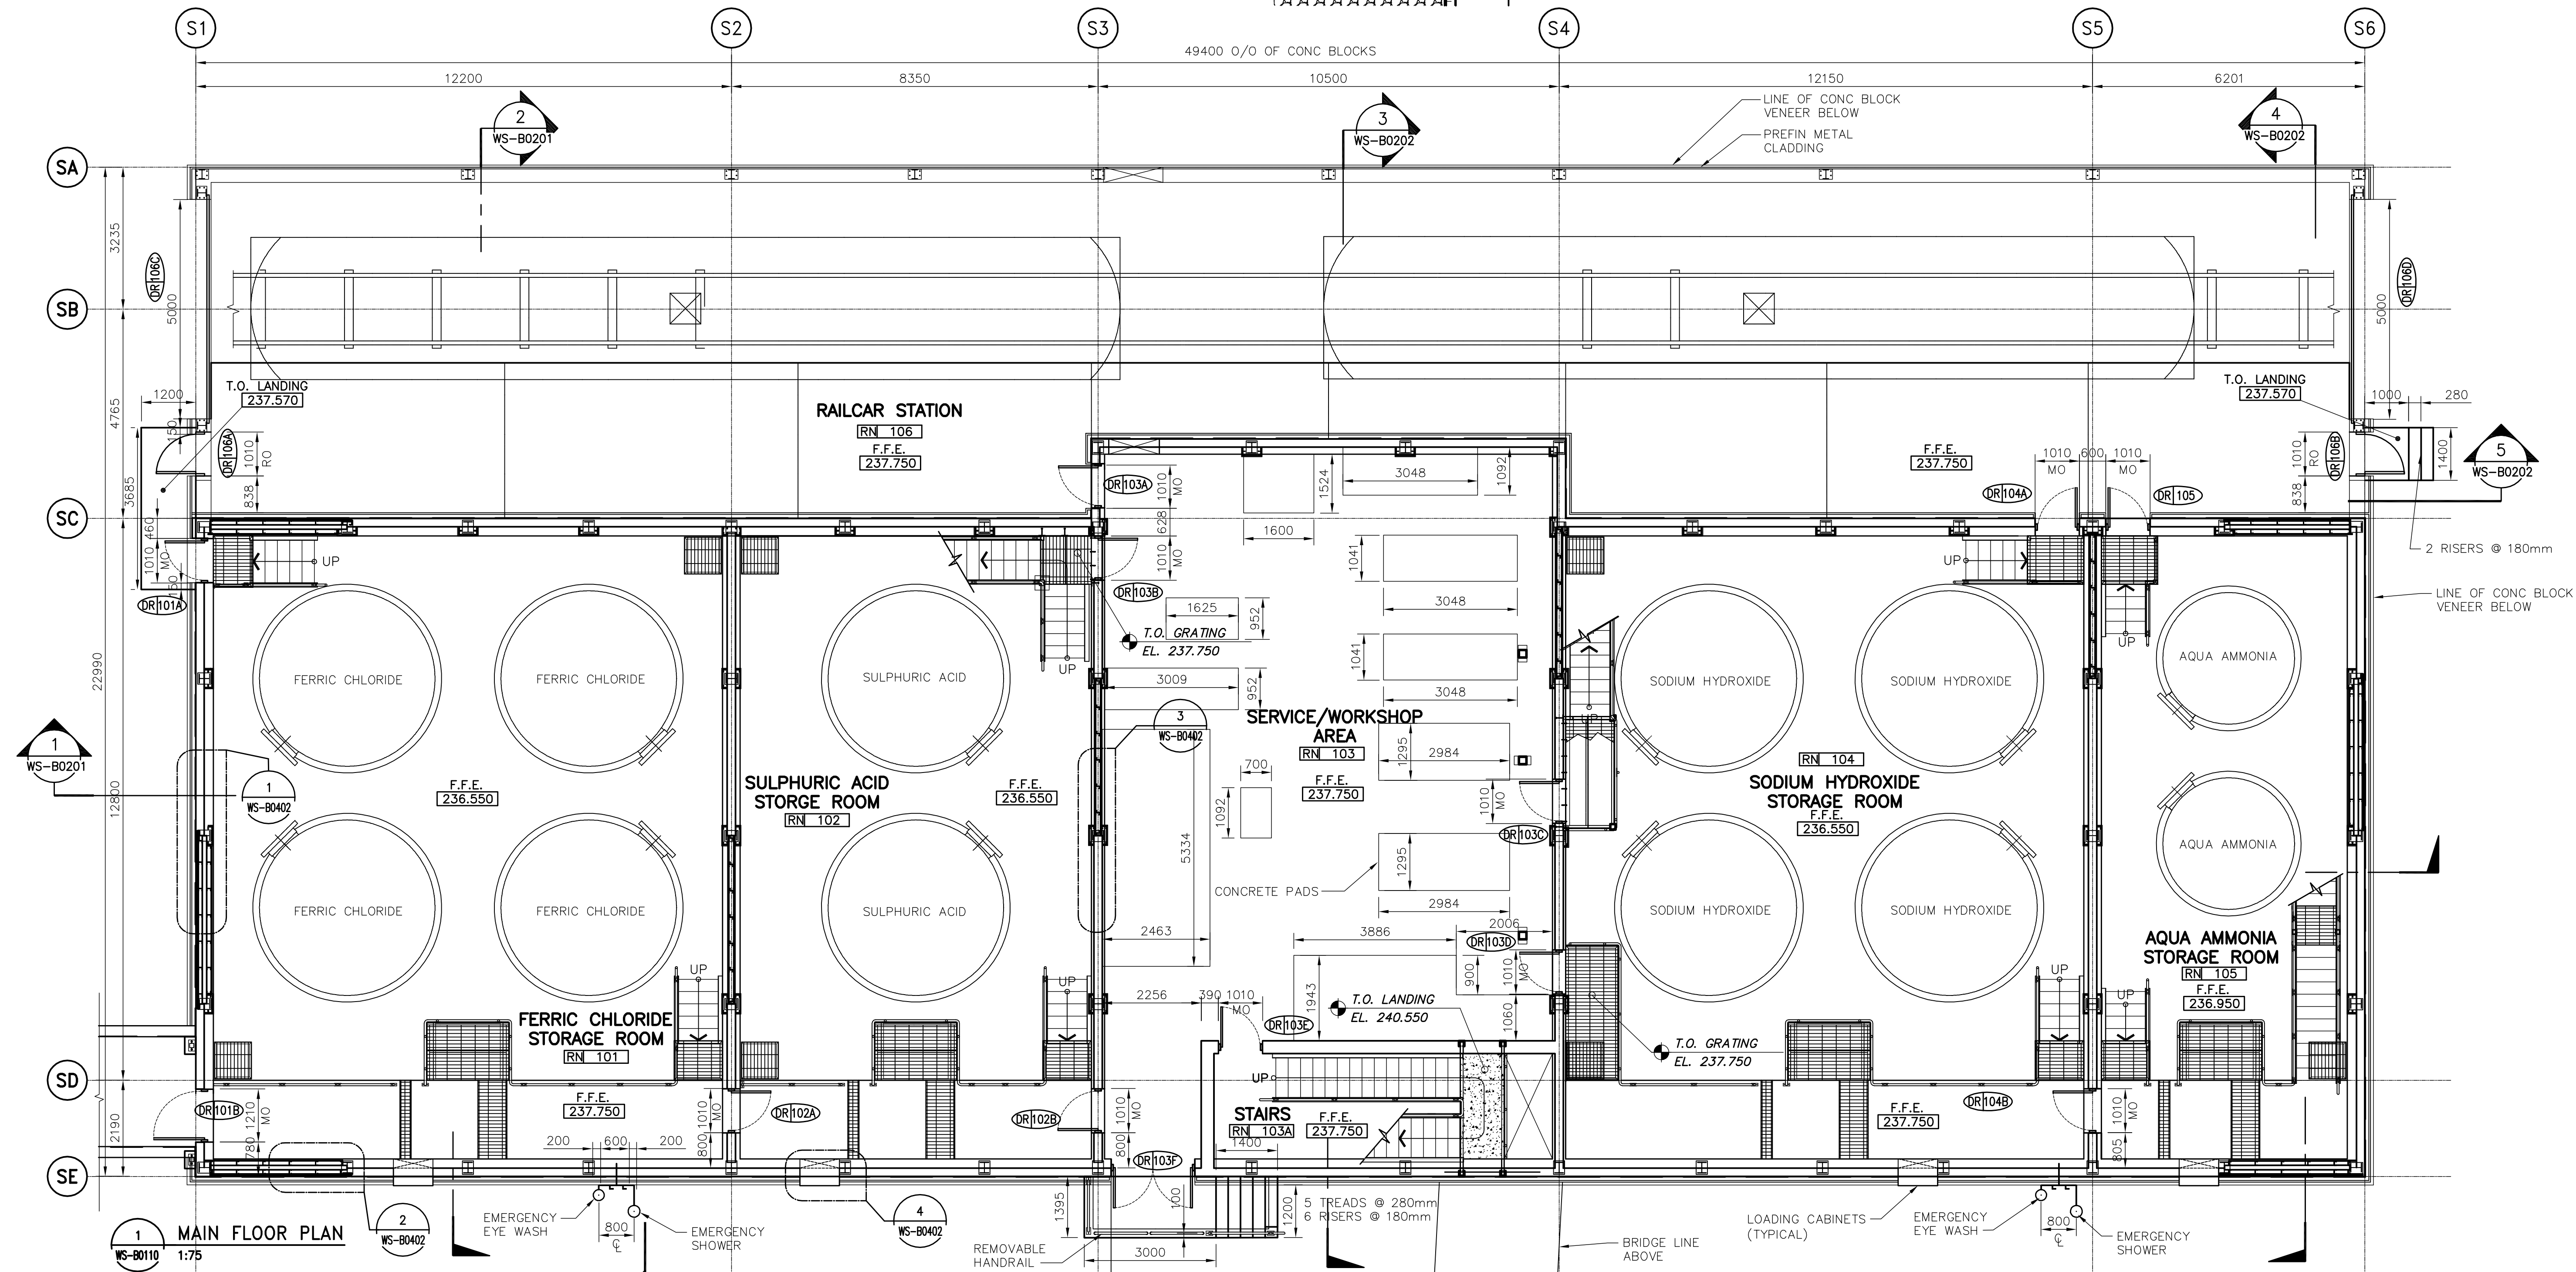


1 MAIN FLOOR PLAN
WS-B0110 1:75

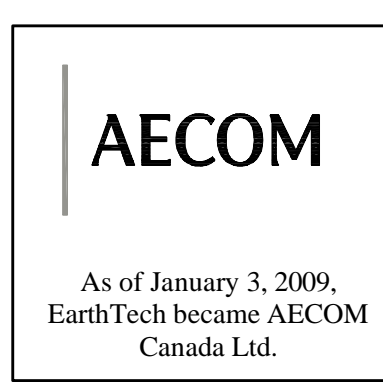

AECOM AS-CONSTRUCTED
SIG. DATE



| B.M. ELEV. | NO. | REVISIONS | DATE | BY | DATE | BY |
|------------|-----|-------------------------|----------|----|------|----|
| | 08 | 792-2006 FI-0-170-FC | 08/08/15 | AG | | |
| | 07 | 792-2006 FI-0-162-FC-R1 | 08/07/23 | AL | | |
| | 06 | 792-2006 FI-0-162-FC | 08/06/10 | AL | | |
| | 05 | 792-2006 FI-0-111-FC | 08/01/10 | AL | | |
| | 04 | 792-2006 FI-0-071-FC | 07/10/10 | AL | | |
| | 03 | ISSUED FOR CONSTRUCTION | 07/06/01 | AL | | |
| | 02 | 792-2006 ADDENDUM 5 | 07/04/11 | AL | | |
| | 01 | 792-2006 ADDENDUM 3 | 07/03/30 | AL | | |
| | 00 | ISSUED FOR TENDER | 07/01/31 | AL | | |

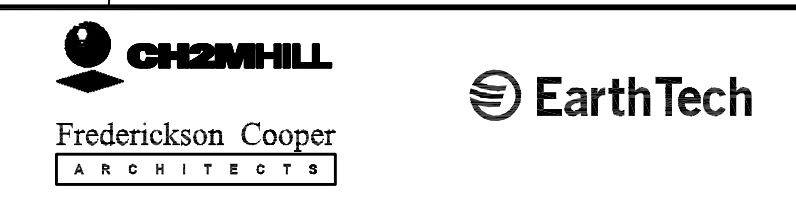

| | |
|------------------|---|
| DESIGNED BY: NC | CHECKED BY: LK |
| DRAWN BY: AL | APPROVED BY: AHL |
| SCALE: AS SHOWN | RELEASED FOR CONSTRUCTION BY: R. SOROKOWSKI |
| DATE: 2006/09/01 | DATE: 2007/01/31 |

ENGINEER'S SEAL
ORIGINAL SIGNED BY: NEIL COOPER
2007/01/31
CONSULTANT DRAWING NO. WS-B0110



WATER TREATMENT PLANT
BULK CHEMICAL STORAGE
SODIUM HYPOCHLORITE AND CHEMICAL BUILDING
ARCHITECTURAL MAIN FLOOR PLAN
CITY FILE NUMBER
SHEET OF
CITY DRAWING NUMBER
1-0601S-B0002-001-09