


1 PARTIAL PLAN AT 245.00
1:50

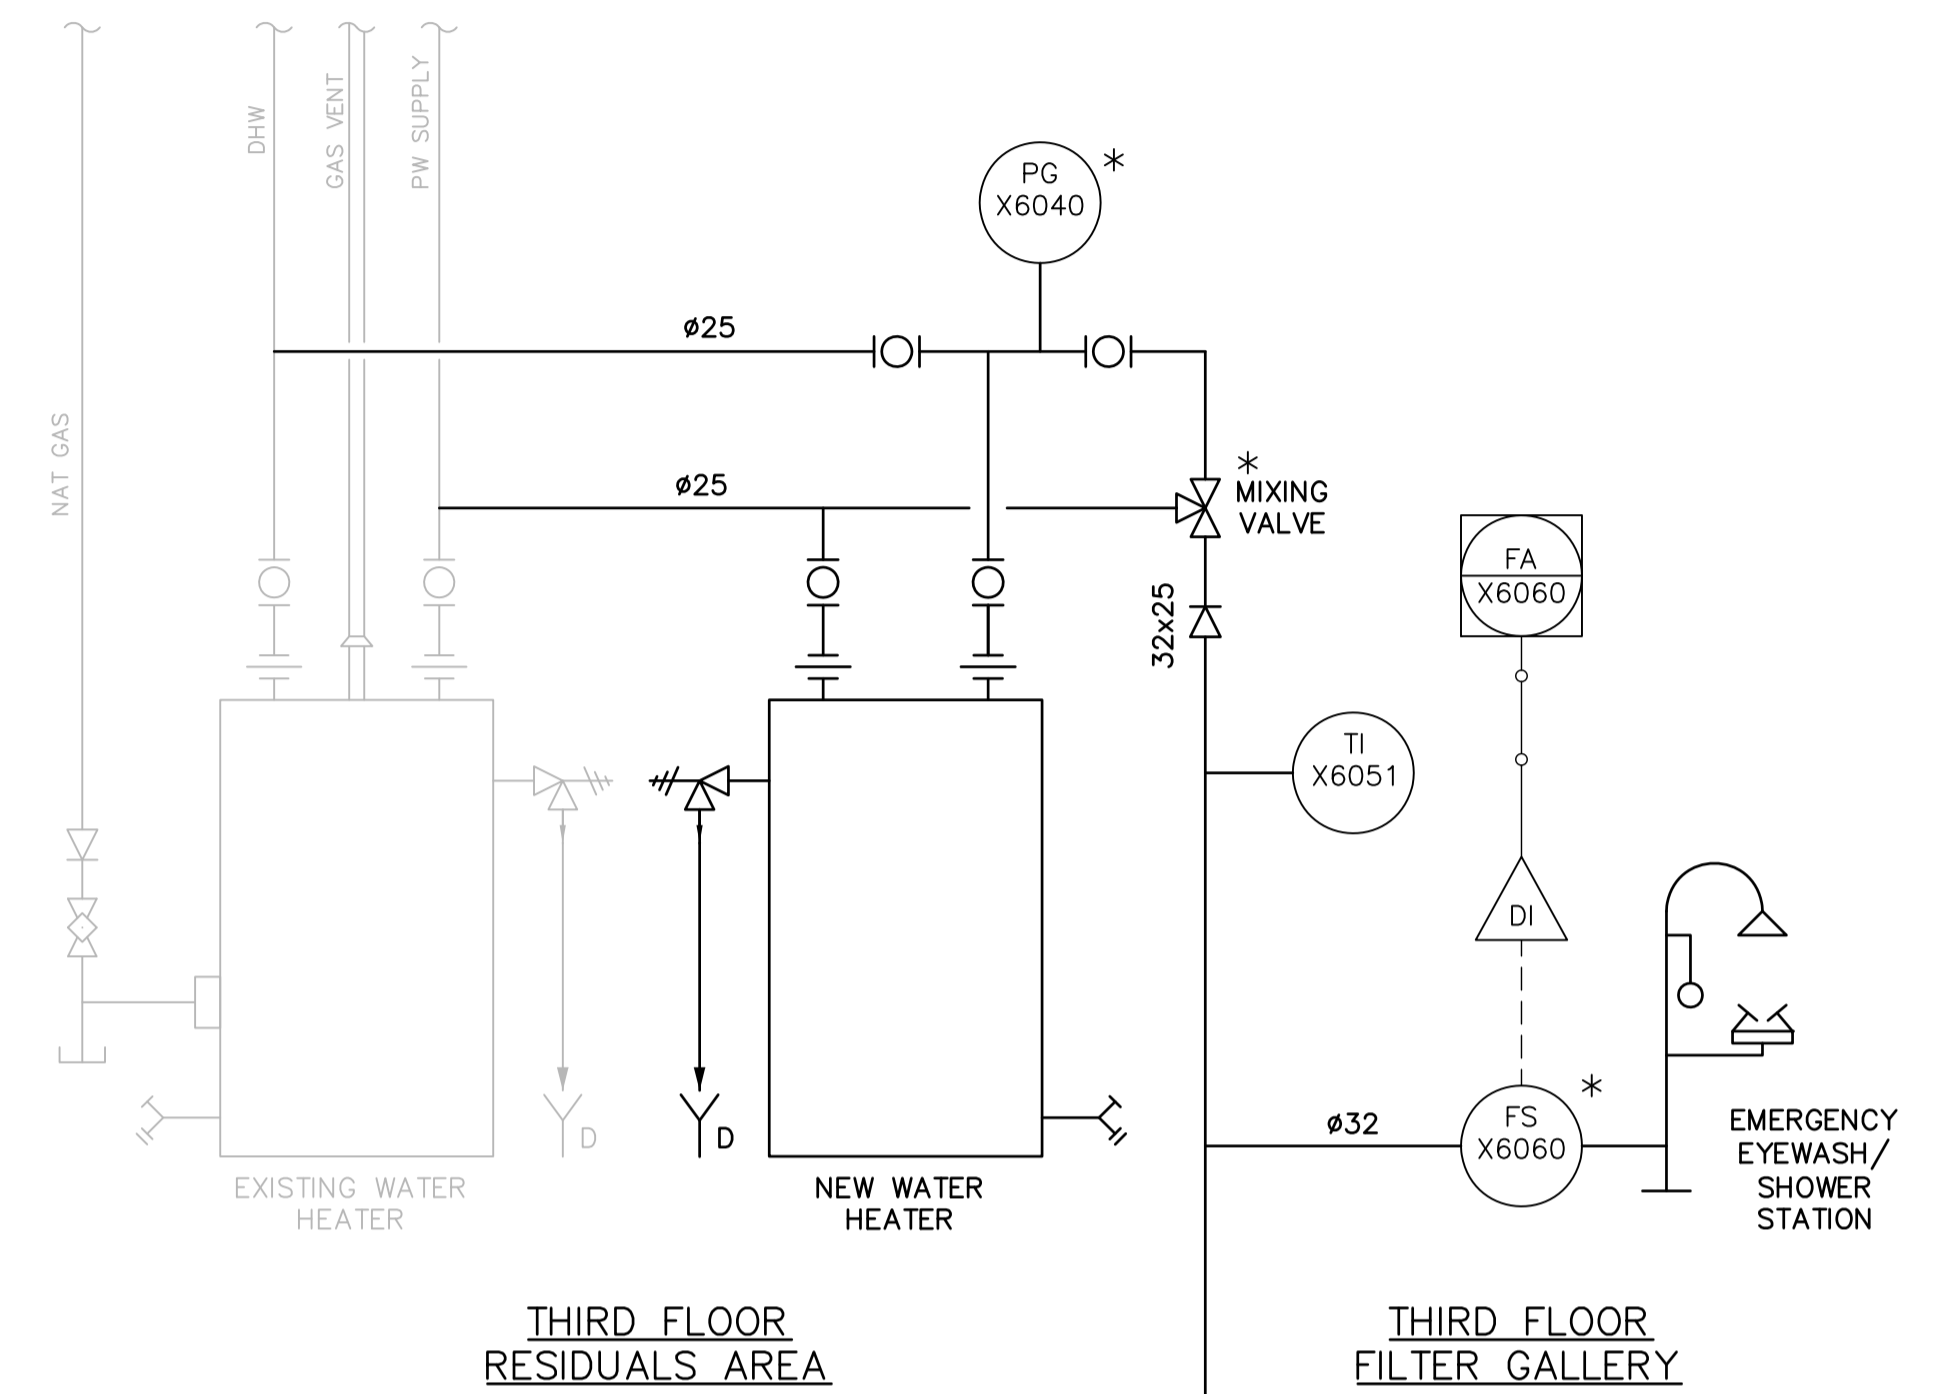


THIRD FLOOR
RESIDUALS AREA

THIRD FLOOR
FILTER GALLERY

EMERGENCY
EYEWASH/
SHOWER
STATION

WTRPO ROOM

SCHEMATIC
NTS

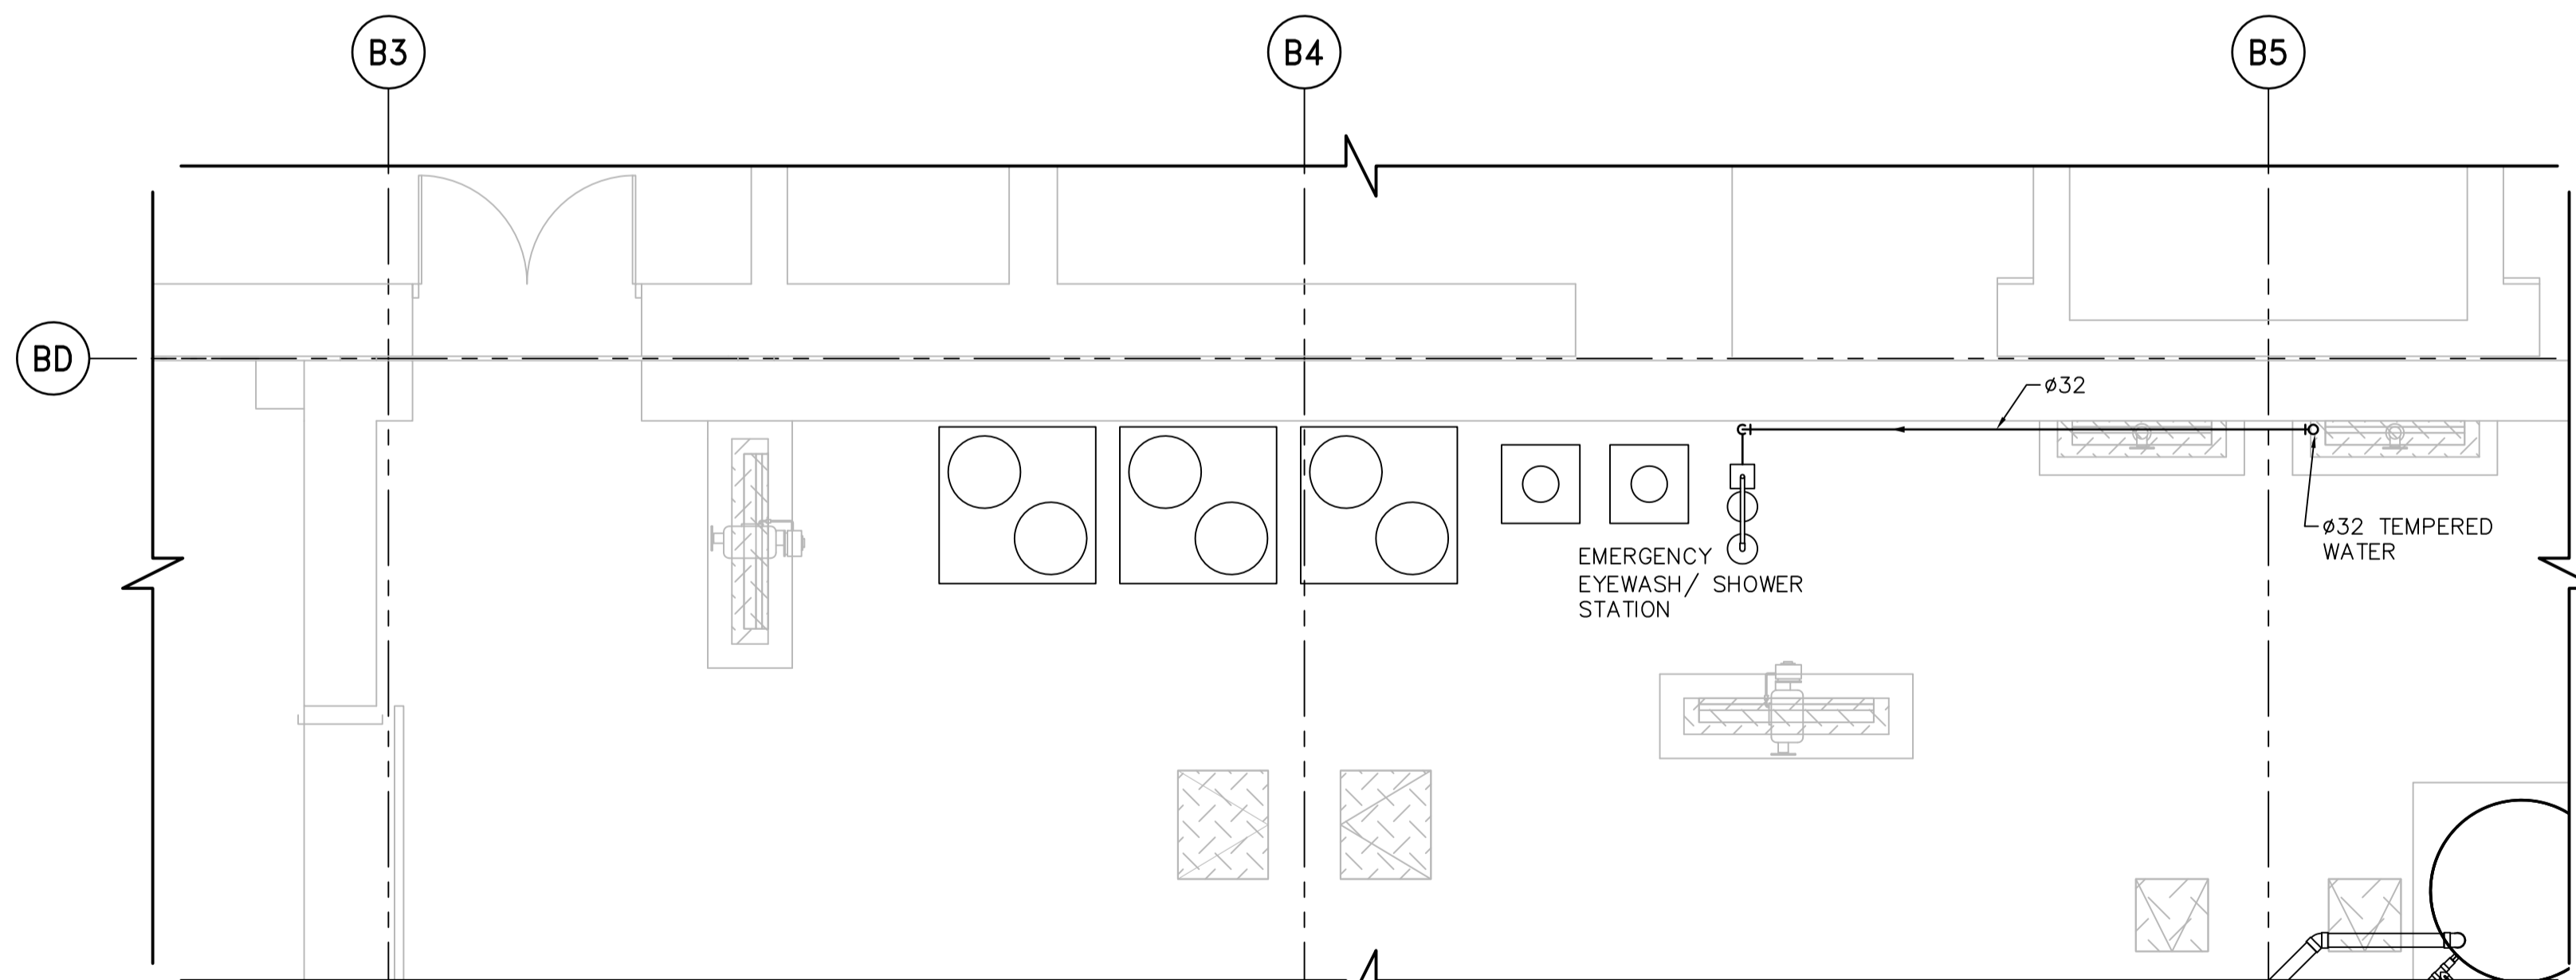

2 PARTIAL PLAN AT 239.410
1:50

NOTES:

* CITY OF WINNIPEG TO SUPPLY EQUIPMENT/ INSTRUMENTATION.
CONTRACTOR TO INSTALL.

REFERENCE DRAWINGS:


1-0601R-H0005-001-03 PLUMBING RESIDUALS AREA THIRD FLOOR PLAN



B.M. ELEV.			
CONSTRUCTION COMPLETION DATE: YYYY MM DD			
NO.	REVISIONS	DATE	BY
2	ISSUED FOR BID OP. 1068-2014	15/01/23	JBC
1	ISSUED FOR ADDENDUM No. 1	14/06/24	JBC
0	ISSUED FOR TENDER	14/06/13	JBC



DESIGNED BY	KG	CHECKED BY	BW
DRAWN BY	JBC	APPROVED BY	BW
SCALE:		RELEASED FOR CONSTRUCTION	
HORIZONTAL	1:50	DATE	2014 06 13
VERTICAL	-	DATE	

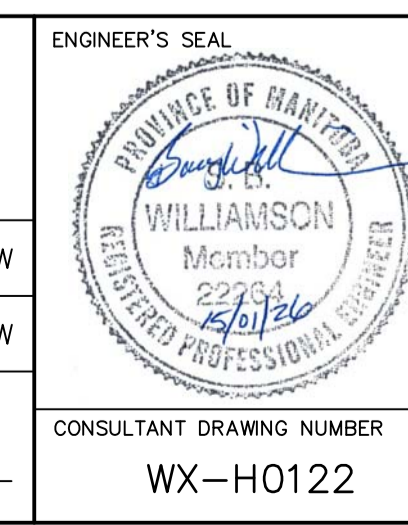

ENGINEER'S SEAL

Winnipeg

THE CITY OF WINNIPEG
WATER AND WASTE DEPARTMENT
ENGINEERING DIVISION

CITY OF WINNIPEG WATER TREATMENT RESEARCH
AND PROCESS OPTIMIZATION FACILITY

PLUMBING
PLANS AND SCHEMATIC

CONSULTANT DRAWING NUMBER
WX-H0122

SHEET X OF X
CITY DRAWING NUMBER
1-0601X-H0003-001-02

