

**DEMOLITION KEYNOTES:**

- ① EXISTING LIGHT FIXTURE TO BE RELOCATED. REFER TO A/B104.
- ② EXISTING CEILING TILE TO REMAIN AS-IS.


**LEGEND:**

- 9'-0" CEILING HEIGHT ABOVE FINISHED FLOOR
- ACT ACOUSTIC CEILING TILE
- CT CEILING TILE
- EX EXISTING
- Light fixture symbol LIGHT FIXTURE TO BE RELOCATED
- Light fixture symbol EXISTING LIGHT FIXTURE TO REMAIN AS-IS
- Light fixture symbol EXISTING LIGHT FIXTURE TO REMAIN AS-IS

A EXISTING REFLECTED CEILING PLAN  
 B103 1/4" = 1' - 0"

7				
6				
5				
4				
3				
2				
1				
0	ISSUED WITH ADDENDUM #3	VCV	KRD	FEB 14 2014
REV	DESCRIPTION	DWN	APP	REV DATE

**Accutech Engineering Inc.**  
*Tomorrow's Technology Today*  
 605-287 Broadway, Winnipeg, Manitoba Canada R3C 0R9  
 Phone 204.944.1555 Fax 204.944.1444  
 www.accutecheng.ca

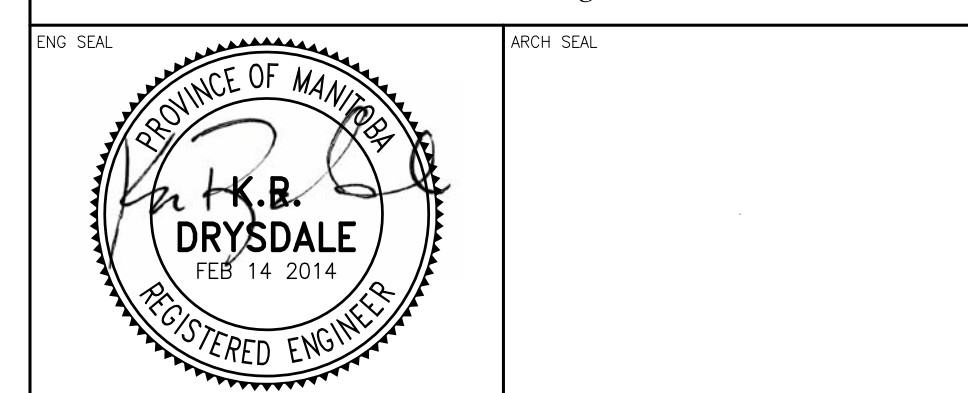

PROJECT  
**CITY OF WINNIPEG**  
**SIR JOHN FRANKLIN CC BASEMENT STRUCTURAL REPAIRS**

SHEET TITLE  
**EXISTING REFLECTED CEILING PLAN**

BID OPPORTUNITY No. 32-2014

DRAWN BY VCV	CHECKED BY KRD	DATE FEB 14 2014	SHEET NO <b>B103</b>
DESIGNED BY KRD	CHECKED BY KRD	SCALE AS NOTED	REVISION NO 0

