



PART PILING PLAN
1:125

- NOTES:**
- REFER TO DWG 1-0102-SGAD-A001 FOR GENERAL NOTES.
 - REFER TO DWG 1-0102-SGAD-A002 FOR OVERALL SITE PLAN AND SEQUENCING.
 - PILE DIAMETER (D) = 400mm
 - PILE CUT-OFF ELEVATION = 225.525 UNLESS NOTED OTHERWISE.
 - ESTIMATED PILE REFUSAL EL 210.000

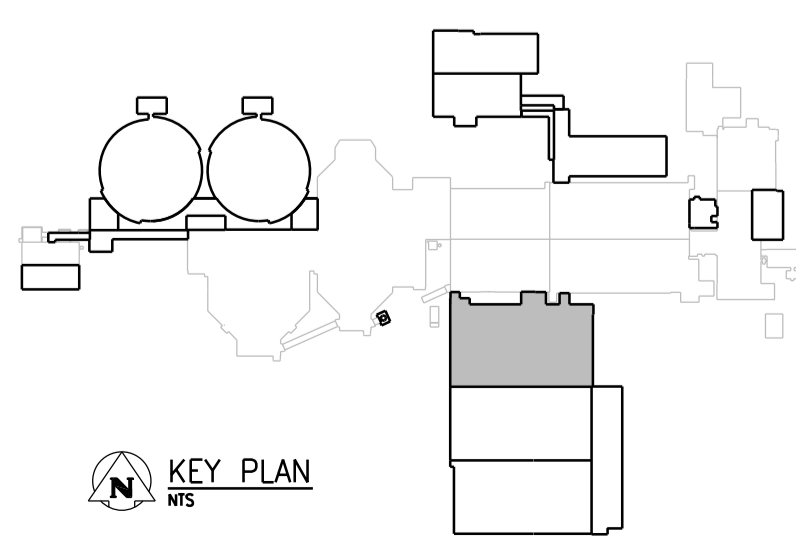

00	ISSUED FOR TENDER	06/2014	G.O. B.W.
NO.	REVISIONS	DATE	DESIGN CHECK

CH2MHILL	
DESIGNED BY: E. LUI	CHECKED BY: B. WILLIAMSON
DRAWN BY: G. OMORI	APPROVED BY: E. LUI
SCALE: 1:125	ISSUED FOR CONSTRUCTION BY:
DATE: 2014/06/27	DATE:
CONSULTANT NO.: 474248	

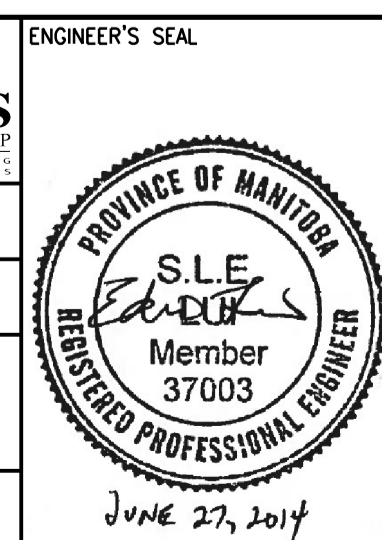

THE CITY OF WINNIPEG
Winnipeg WATER AND WASTE DEPARTMENT

SOUTH END WATER POLLUTION CONTROL CENTRE
SEWPPC UPGRADING/EXPANSION PROJECT
STRUCTURAL
BIOREACTORS/BLOWER BUILDING
PART PILING PLAN (1)

CITY DRAWING NUMBER: 1-0102-SFDW-R002
SHEET: 001
REV: 00
SIZE: A1