


### BASEMENT FLOOR PLAN

1:100



NOTE:  
 1. REFER TO SHOP DRAWINGS PROVIDED BY VEOLIA WATER TECHNOLOGIES CANADA INC. FOR EQUIPMENT CONFIGURATIONS AND INSTALLATION DETAILS.

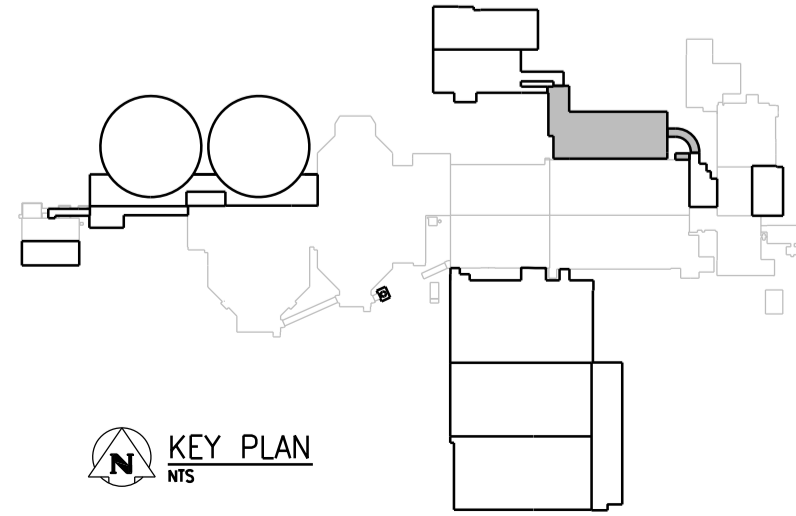

**APEGM**  
 Certificate of Authorization  
 CH2M HILL Canada Ltd.  
 No. 1441

NO.	REVISIONS	DATE	DESIGN	CHECK
01	ISSUED FOR ADDENDUM NO. 3	09/2015	B.C.	J.C.
00	ISSUED FOR TENDER	08/2015	B.C.	J.C.

<b>CH2MHILL</b>	
DESIGNED BY: J. KRAEMER	CHECKED BY: J. KRAEMER
DRAWN BY: B. COOPER	APPROVED BY: F. ABSI
SCALE: 1:100	ISSUED FOR CONSTRUCTION BY: T. TURZAK
DATE: 2015/08/13	DATE: 2015/08/13
CONSULTANT NO.: 474248	



**THE CITY OF WINNIPEG**  
 WATER AND WASTE DEPARTMENT

SOUTH END WATER POLLUTION CONTROL CENTRE  
 SEWPCC UPGRADING/EXPANSION PROJECT  
 PROCESS  
 HIGH RATE CLARIFICATION BUILDING  
 BASEMENT PLAN

CITY DRAWING NUMBER: 1-0102-PGAD-K001

SHEET: 01 REV: 01 SIZE: A1