


PILING PLAN
1:50


NOTES:

1. REFER TO DWG 1-0102-SGAD-A001 FOR GENERAL NOTES.
2. REFER TO DWG 1-0102-SGAD-A002 FOR OVERALL SITE PLAN AND SEQUENCING.
3. PILE DIAMETER (D) = 400mm UNLESS NOTED OTHERWISE.
4. PILE CUT-OFF ELEVATION = 226.856 UNLESS NOTED OTHERWISE.
5. ESTIMATED PILE REFUSAL EL 212.000

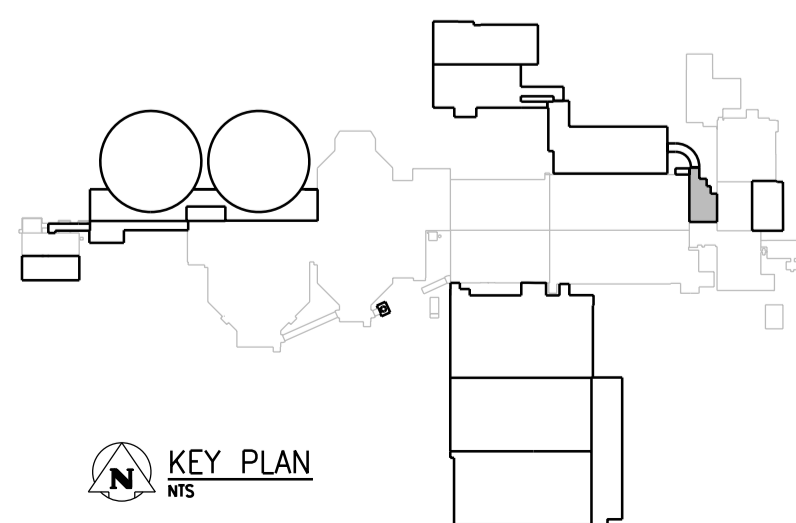

NO.	REVISIONS	DATE	DESIGN	CHECK
00	ISSUED FOR TENDER	08/2015	G.O.	J.C.

CH2MHILL.		KCS GROUP CONSULTING ENGINEERS	
DESIGNED BY: E. LUI	CHECKED BY: R. PARIKH	APPROVED BY: E. LUI	ISSUED FOR CONSTRUCTION BY: T. TURZAK
DRAWN BY: G. OMORI	DATE: 2015/08/13	DATE: 2015/08/13	CONSULTANT NO.: 474248
SCALE: 1:50			

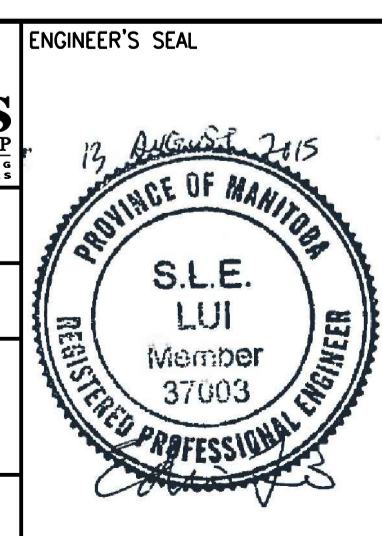

THE CITY OF WINNIPEG
Winnipeg WATER AND WASTE DEPARTMENT

SOUTH END WATER POLLUTION CONTROL CENTRE
SEWPCC UPGRADING/EXPANSION PROJECT
STRUCTURAL
GRIT TANKS 1 AND 2
PILING PLAN

CITY DRAWING NUMBER: 1-0102-SFDW-G004 SHEET: 00 REV: 00 SIZE: A1