




# THE CITY OF WINNIPEG

WATER AND WASTE DEPARTMENT  
ENGINEERING DIVISION

## WILKES RESERVOIR NORTH CELL REHABILITATION CONSTRUCTION OF LAYDOWN AREA

BID OPPORTUNITY 711-2015

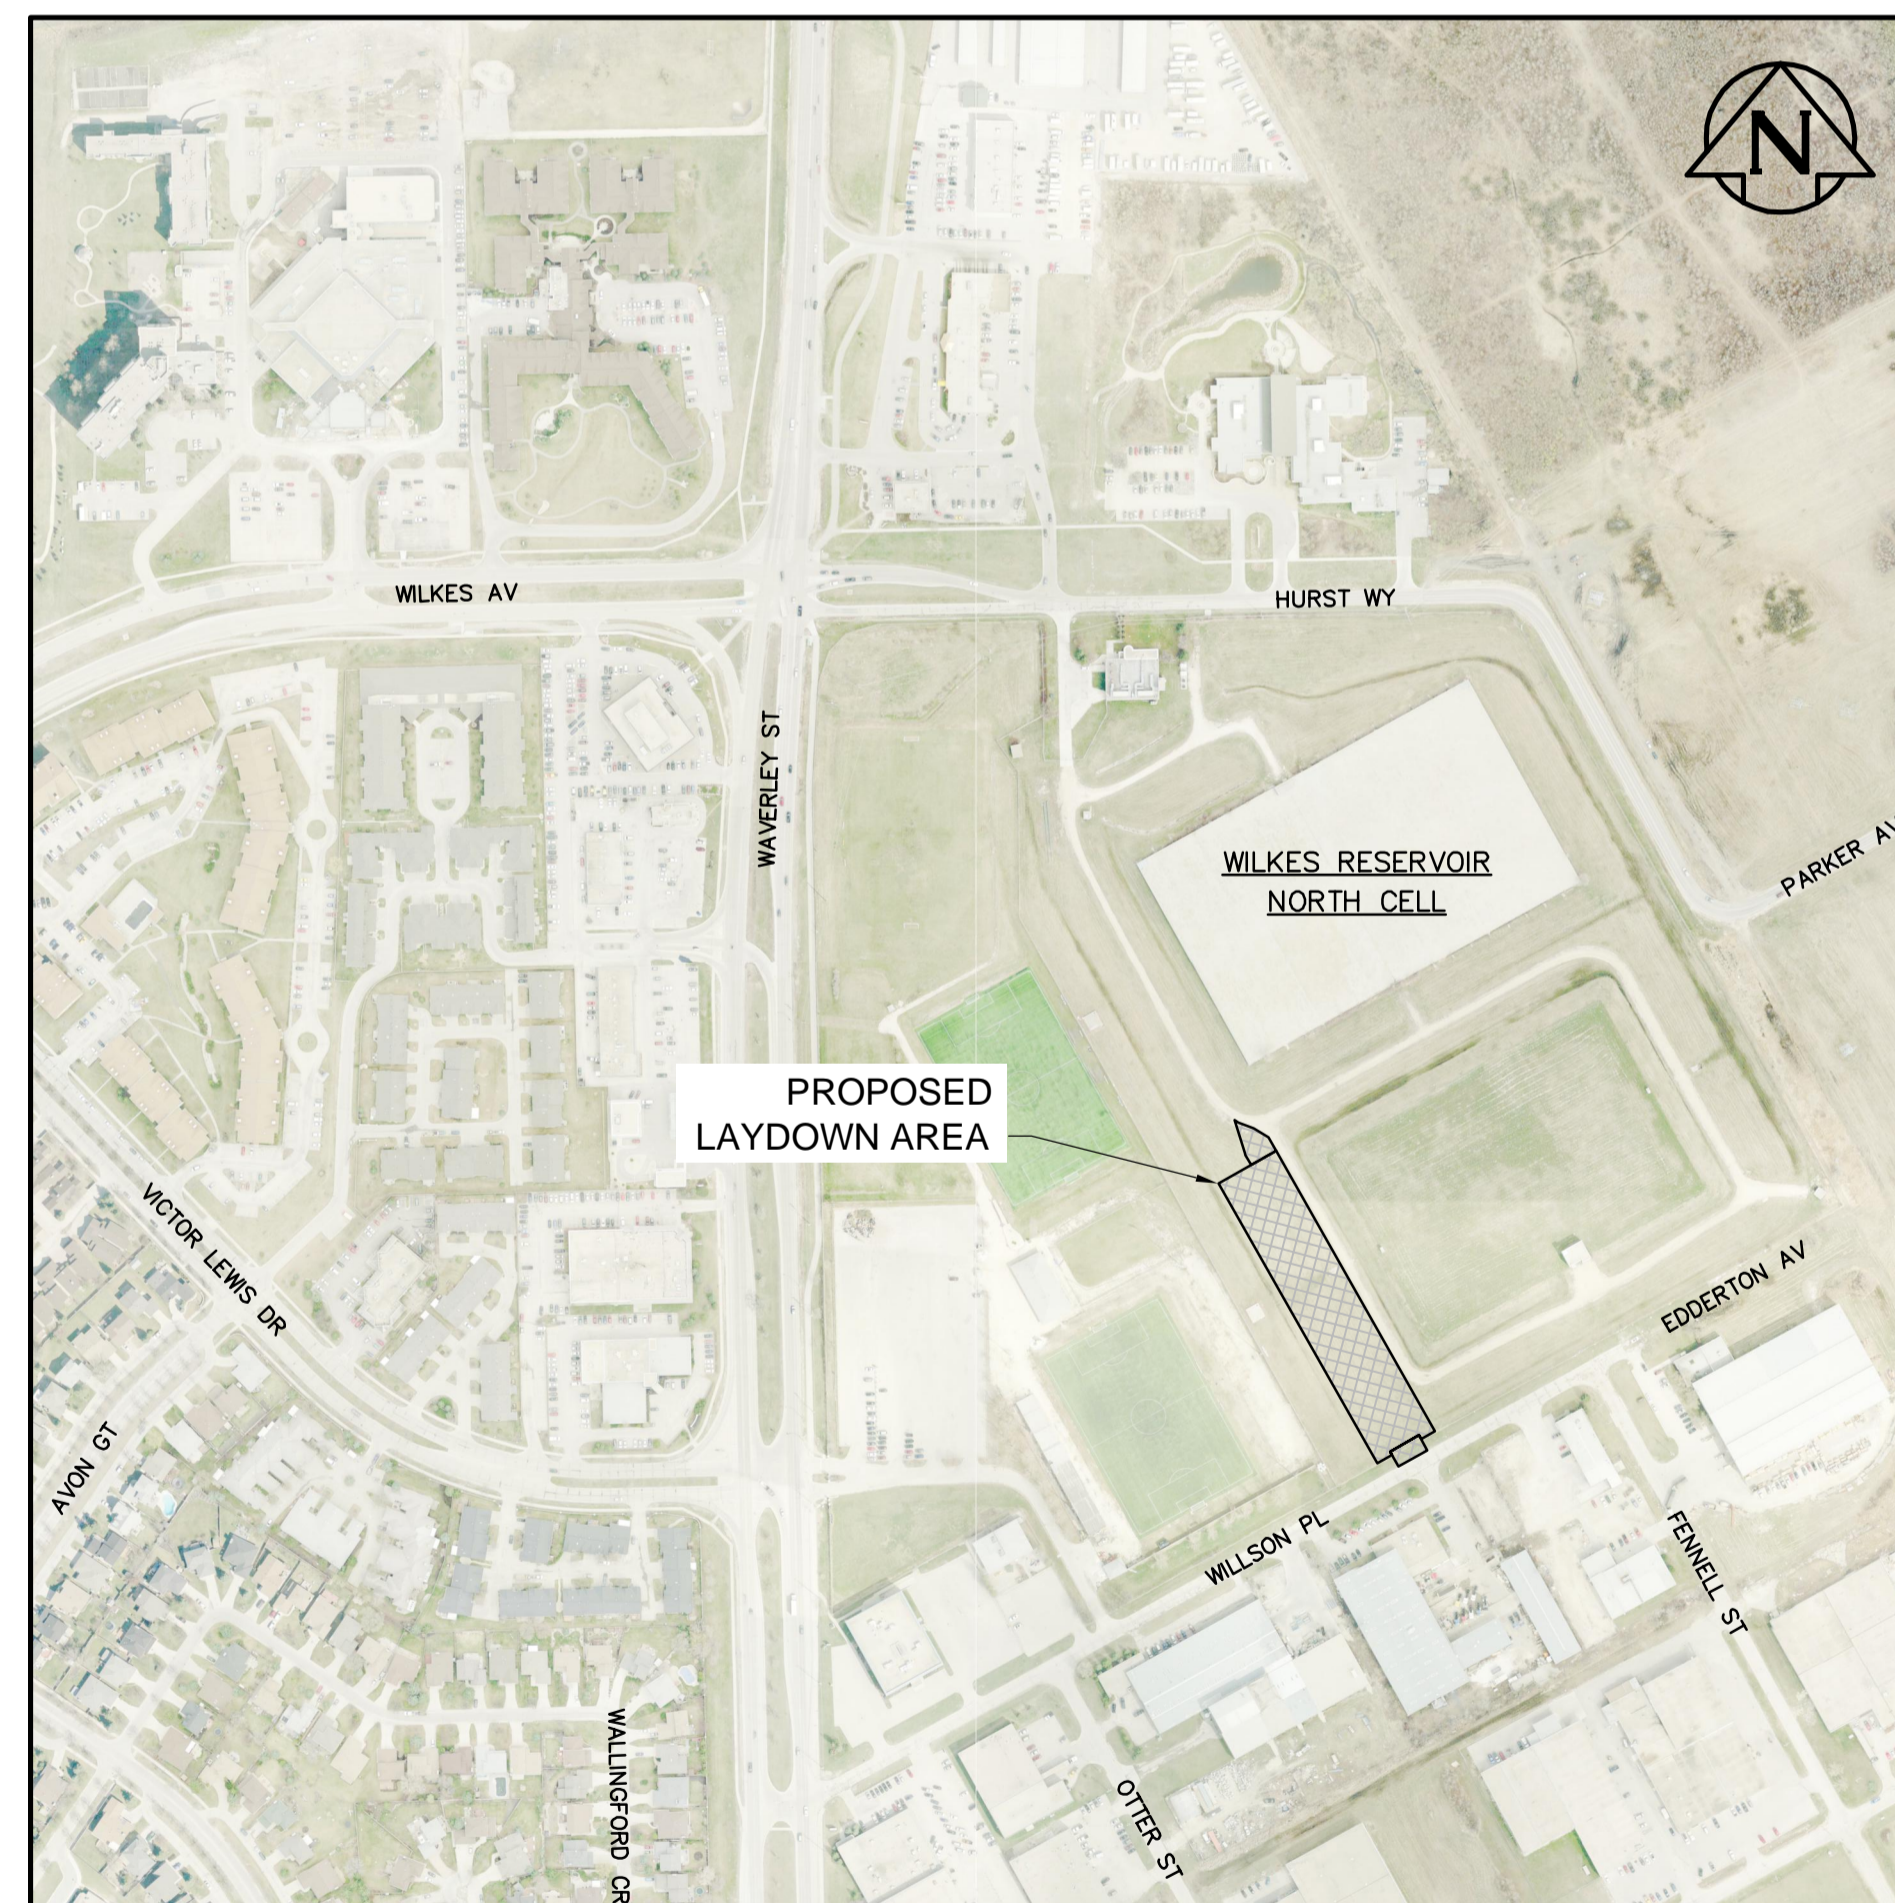

KEY MAP

### DRAWING INDEX

SHEET NUMBER	CITY OF WINNIPEG DRAWING NUMBER	CONSULTANT DRAWING NUMBER	REVISION	DRAWING TITLE
GENERAL				
1	1-0650R-D0001-001	14-1411-G-100	A	COVER SHEET AND DRAWING INDEX
CIVIL				
2	1-0650R-C0001-001	14-1411-C-100	A	SITE PLAN
3	1-0650R-C0002-001	14-1411-C-101	A	LAYDOWN AREA SECTIONS
4	1-0650R-C0003-001	14-1411-C-102	A	TYPICAL SECTIONS AND DETAILS