




THE CITY OF WINNIPEG PLANNING, PROPERTY & DEVELOPMENT

PAN AM INDOOR POOL PARKING LOT REDEVELOPMENT - STAGE 2 25 POSEIDON BAY

DRAWING LIST:

DRAWING No:	DESCRIPTION:
921-2015-C01	EXISTING SITE PLAN
921-2015-C02	REMOVALS PLAN
921-2015-C03	LAYOUT PLAN
921-2015-C04	GRADING PLAN
921-2015-C05	LANDSCAPING, SITE FURNISHINGS & SIGNAGE PLAN
921-2015-E01	ELECTRICAL PLAN

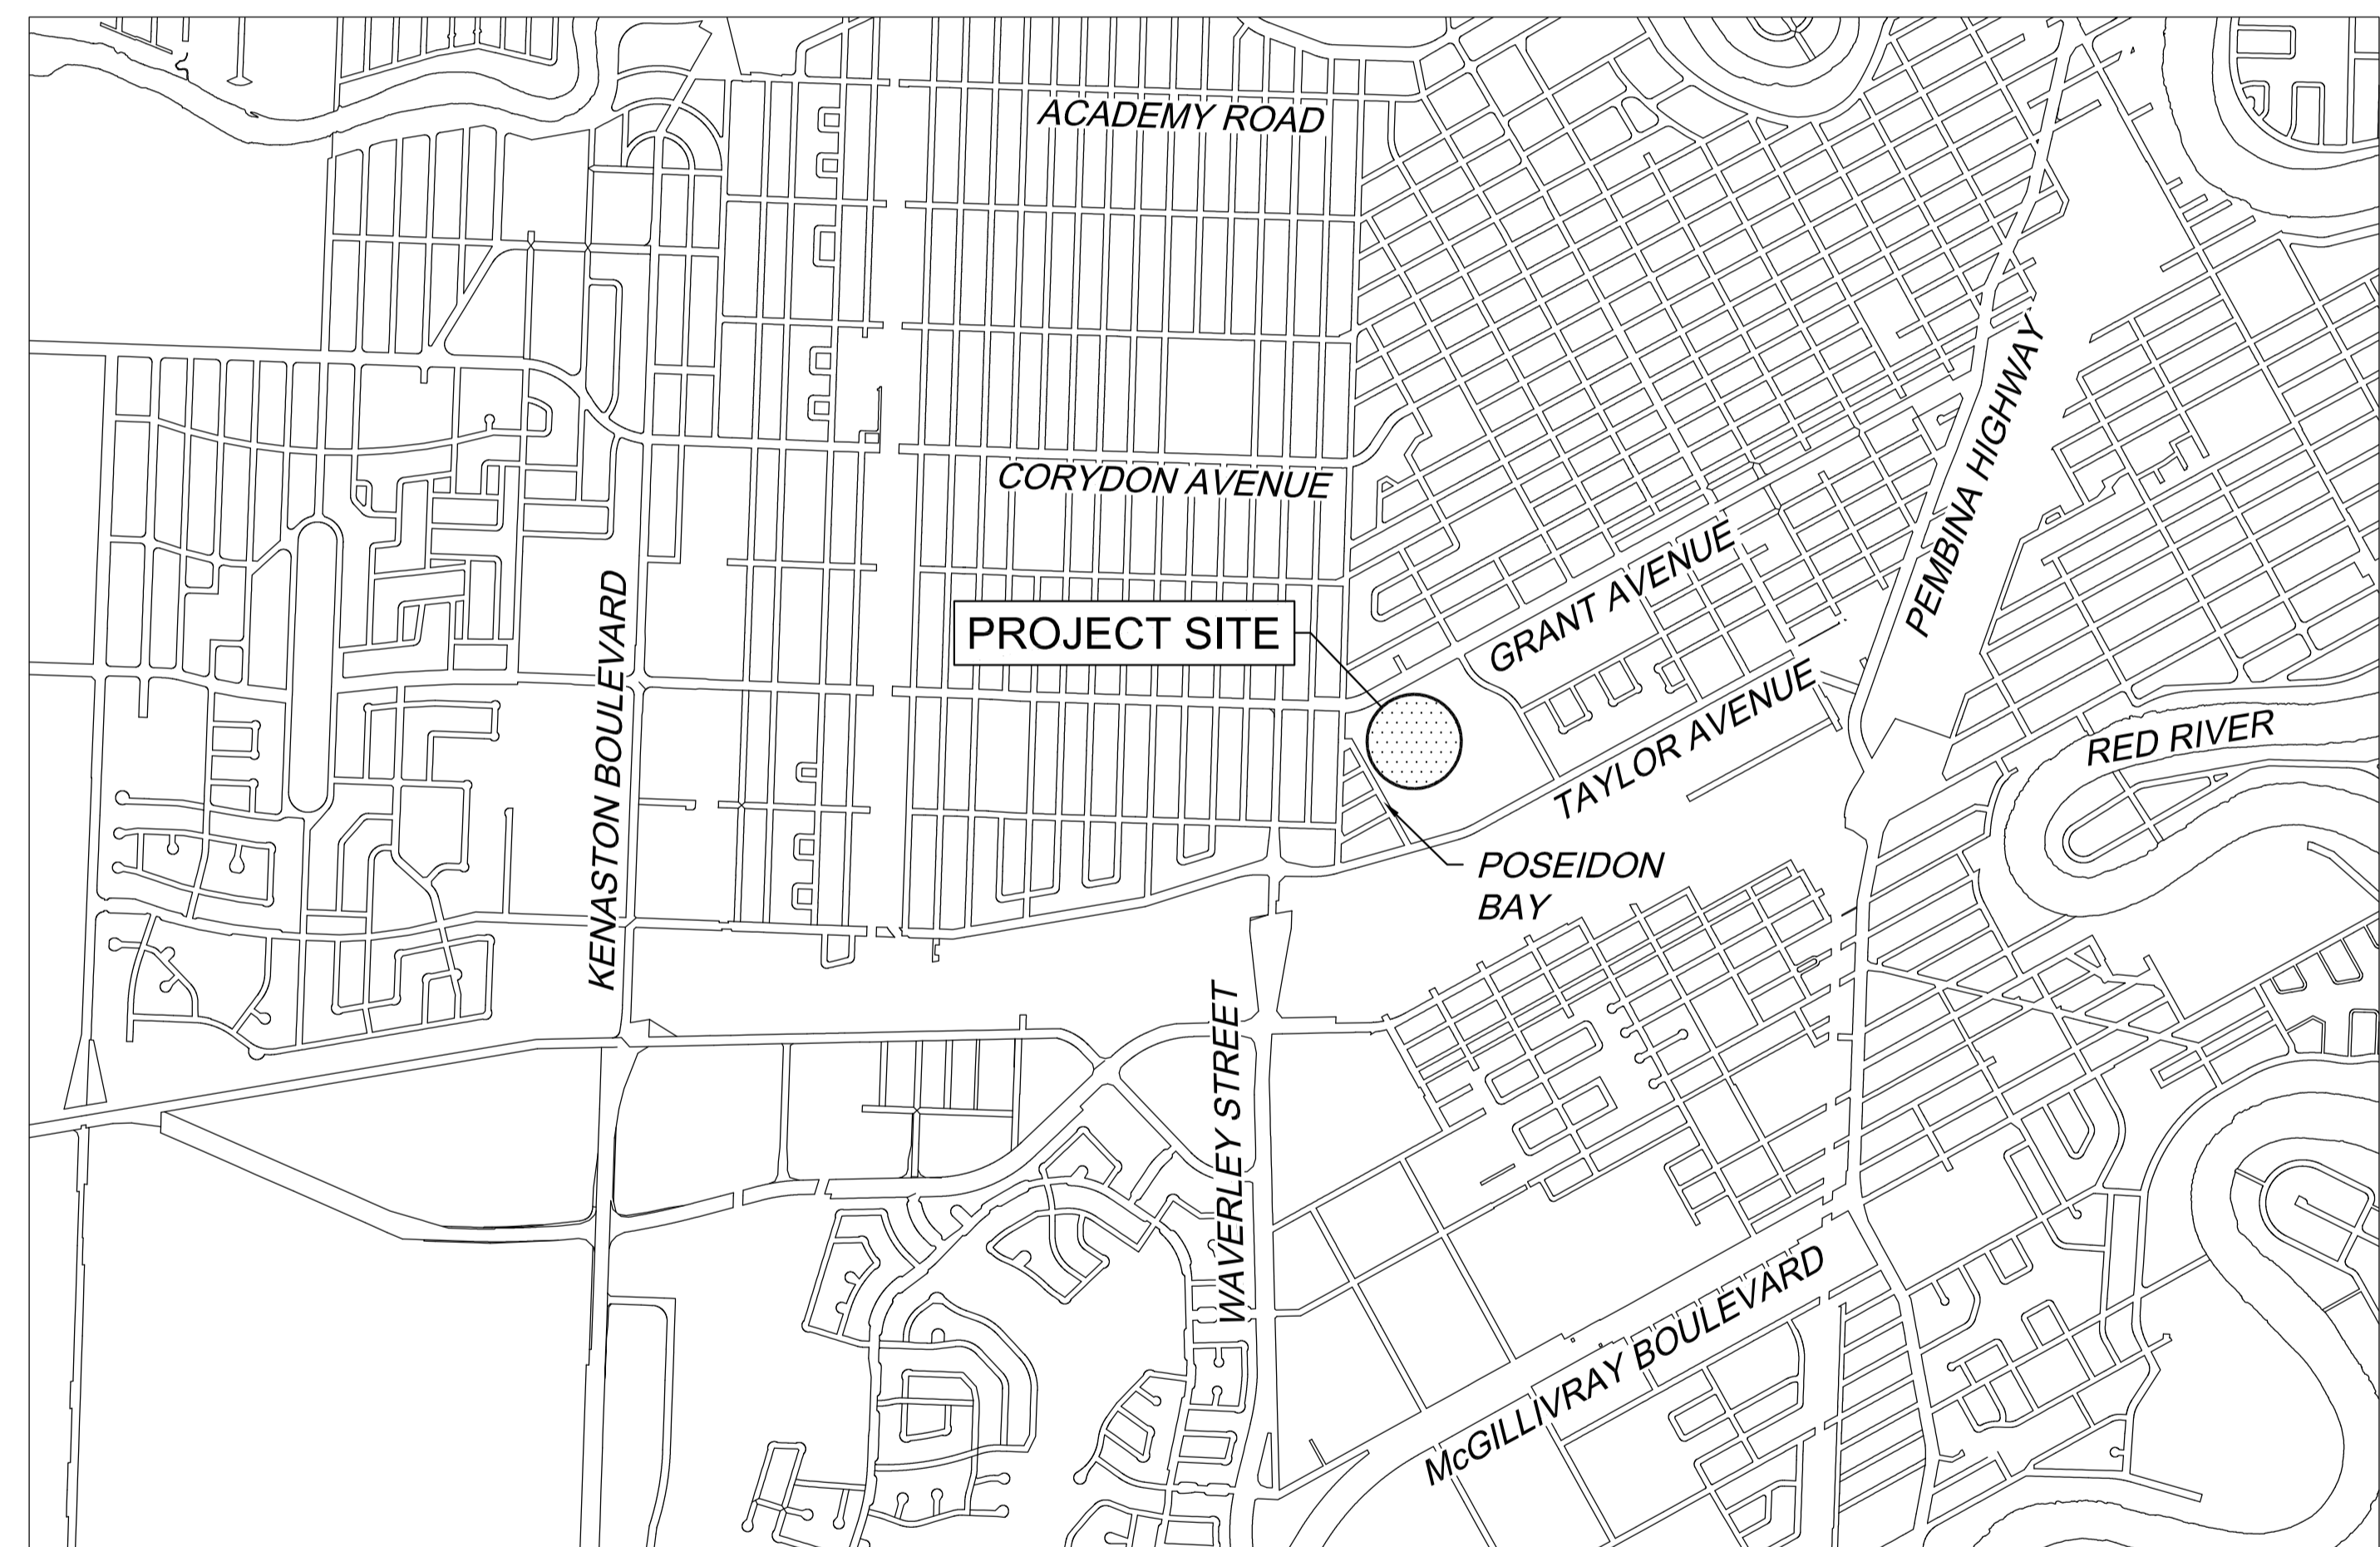

Unit 10 - 5 Scurfield Boulevard
Winnipeg, MB, R3Y 1G3
T: (204) 505-0855 / F: (204) 505-0850

www.SBCinc.ca

BID OPPORTUNITY No. 921-2015
SBC PROJECT No. 15127-00

ISSUED FOR BID OPPORTUNITY

SUBMITTED: 16/03/08