


1 DEMOLITION PLAN
1:40

LEGEND
- - - - - PIPE TO BE REMOVED


HAULED WASTEWATER BUILDING NO. 1&2

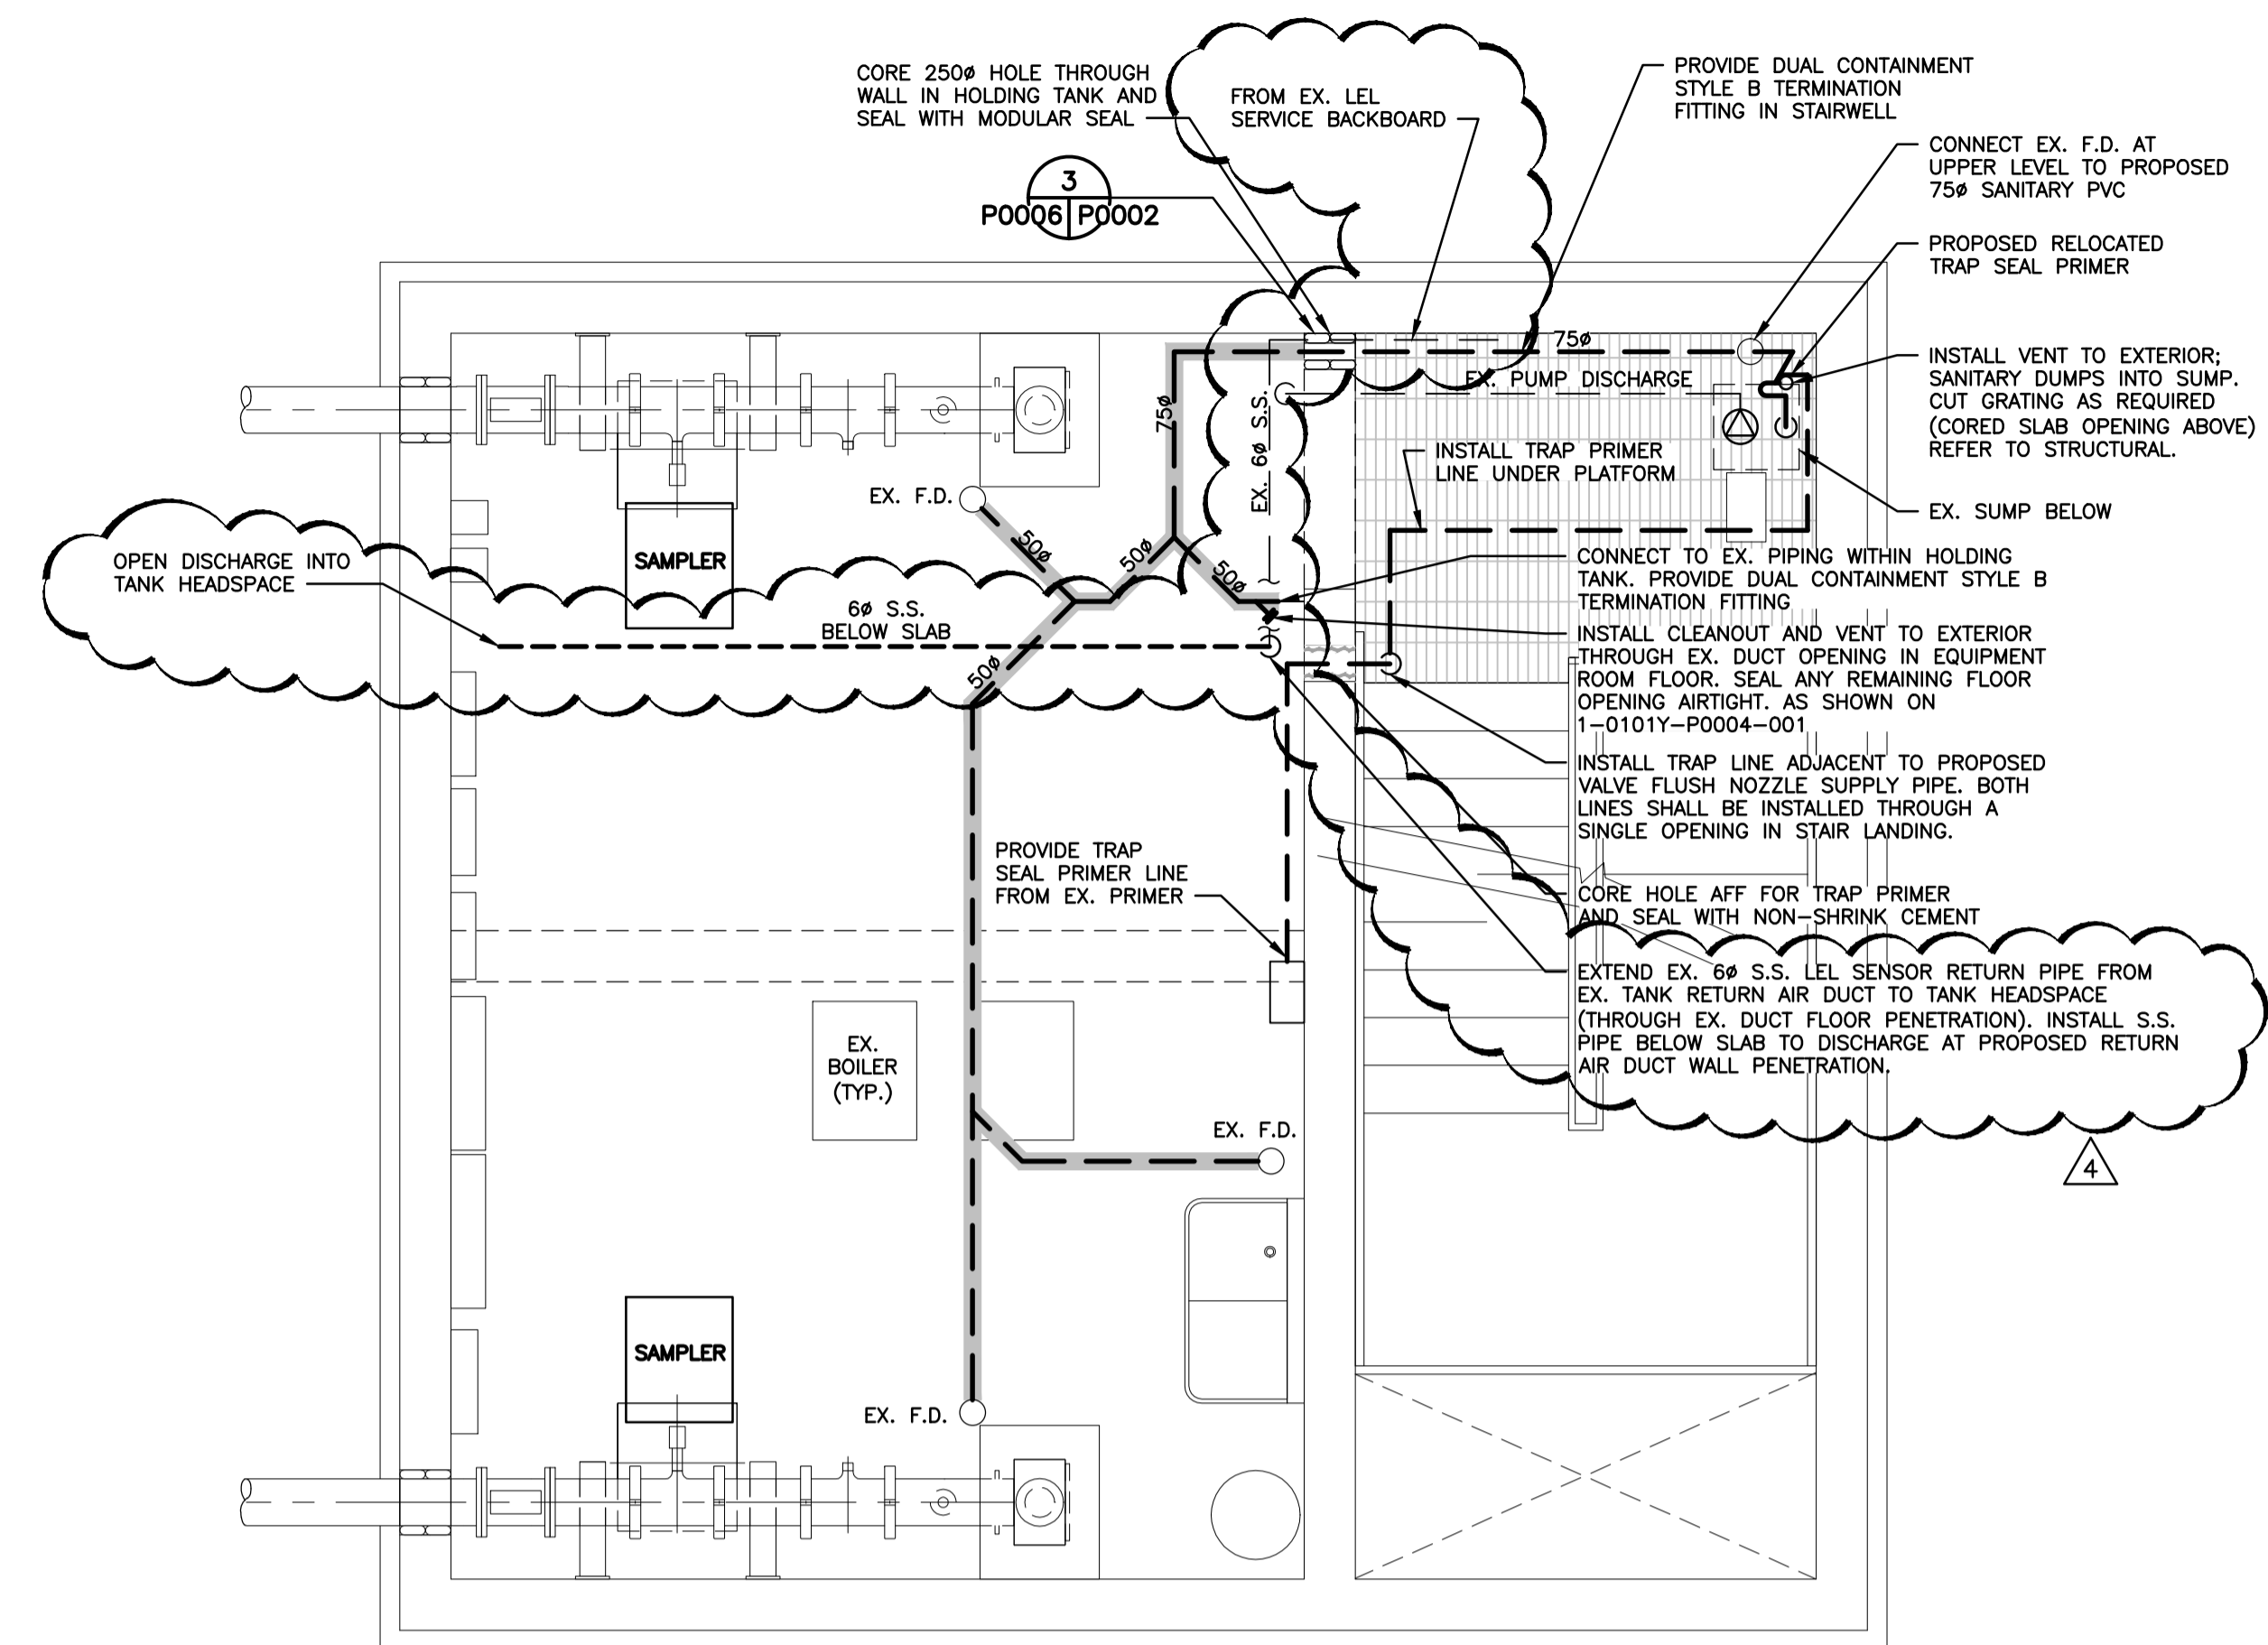

2 PROPOSED PLAN
1:40

LEGEND
- - - - - DUAL CONTAINMENT PVC BELOW SLAB
- - - - - 6# 0.89mm WALL THICKNESS S.S. TUBE

HAULED WASTEWATER BUILDING NO. 1&2

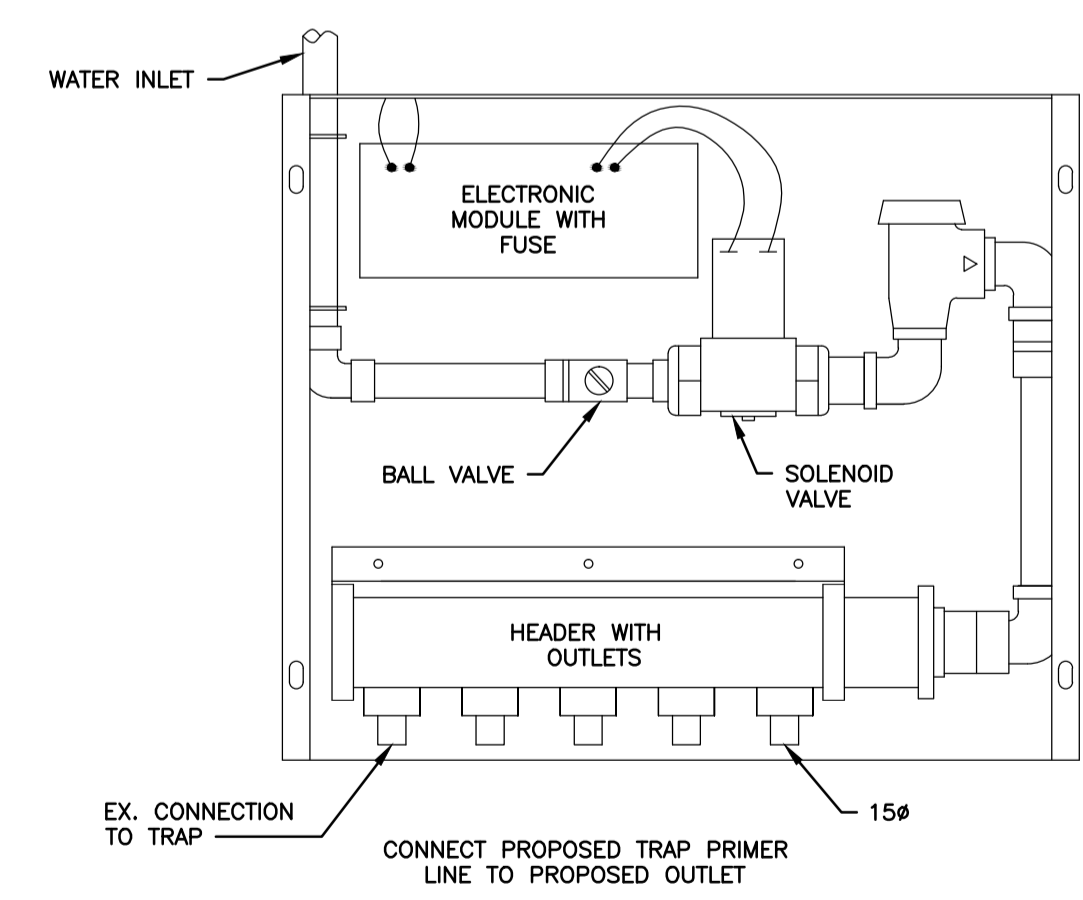

EX. FLOOR DRAIN TRAP PRIMER DETAIL

HAULED WASTEWATER BUILDING NO. 1 (FORMERLY HAULED WASTEWATER BUILDING)
HAULED WASTEWATER BUILDING NO. 2 (FORMERLY LEACHATE RECEIVING BUILDING)

WARNING
IF POWER EQUIPMENT OR EXPLOSIVES ARE TO BE USED FOR EXCAVATION ON THIS PROJECT THE CONTRACTOR MUST:
1) NOTIFY THE GAS COMPANY OF THE PROPOSED LOCATION OF EXCAVATION.
2) TAKE PRECAUTION TO AVOID DAMAGE TO GAS COMPANY INSTALLATIONS.
SEE PROVINCIAL REGULATION 140/92 FOR DETAILS

METRIC
WHOLE NUMBERS INDICATE MILLIMETRES
DECIMALIZED NUMBERS INDICATE METRES

LOCATION APPROVED UNDERGROUND STRUCTURES

SUPV. U/G STRUCTURES	DATE COMMITTEE

NOTE:
LOCATION OF UNDERGROUND STRUCTURES AS SHOWN ARE BASED ON THE BEST INFORMATION AVAILABLE BUT NO GUARANTEE IS GIVEN THAT ALL EXISTING UTILITIES ARE SHOWN OR THAT THE GIVEN LOCATIONS ARE EXACT. CONFIRMATION OF EXISTENCE AND EXACT LOCATION OF ALL SERVICES MUST BE OBTAINED FROM THE INDIVIDUAL UTILITIES BEFORE PROCEEDING WITH CONSTRUCTION.

NO.	REVISIONS	DATE	BY	B.M. ELEV.
4	ISSUED FOR ADDENDUM #3	16.03.29	R.J.G.	
3	ISSUED FOR TENDER	16.03.09	S.K.B.	
2	ISSUED FOR TENDER REVIEW	16.03.07	S.K.B.	
1	ISSUED FOR 95% REVIEW	16.01.29	S.K.B.	

Stantec
500-311 Portage Ave. Winnipeg MB Canada
www.stantec.com

DESIGNED BY: R.G.	CHECKED BY: S.A.B.
DRAWN BY: K.R.	APPROVED BY: S.K.B.
HOR. SCALE: AS NOTED	RELEASED FOR CONSTRUCTION: DATE
VERTICAL: DATE	DATE

ENGINEER'S SEAL
PROVINCE OF MANITOBA
R.J. GILLIS
Member 24774
REGISTERED PROFESSIONAL ENGINEER

THE CITY OF WINNIPEG WATER AND WASTE DEPARTMENT
Winnipeg

NORTH END SEWAGE TREATMENT PLANT (NEWPC) HAULED LIQUID WASTE FACILITY PHASE II UPGRADE

HAULED WASTEWATER BUILDINGS 1 & 2
SANITARY PLAN UPGRADES

TENDER NO. 952-2015
CITY DRAWING NUMBER 1-0101Y-P0006-001
SHEET 6 OF 8

APEGM
Certificate of Authorization
Stantec Consulting Ltd.
No. 1301