



LEGEND
 // PIPE TO BE REMOVED
 1
 -
 DEMOLITION PLAN
 1:40

HAULED WASTEWATER BUILDING NO. 1&2

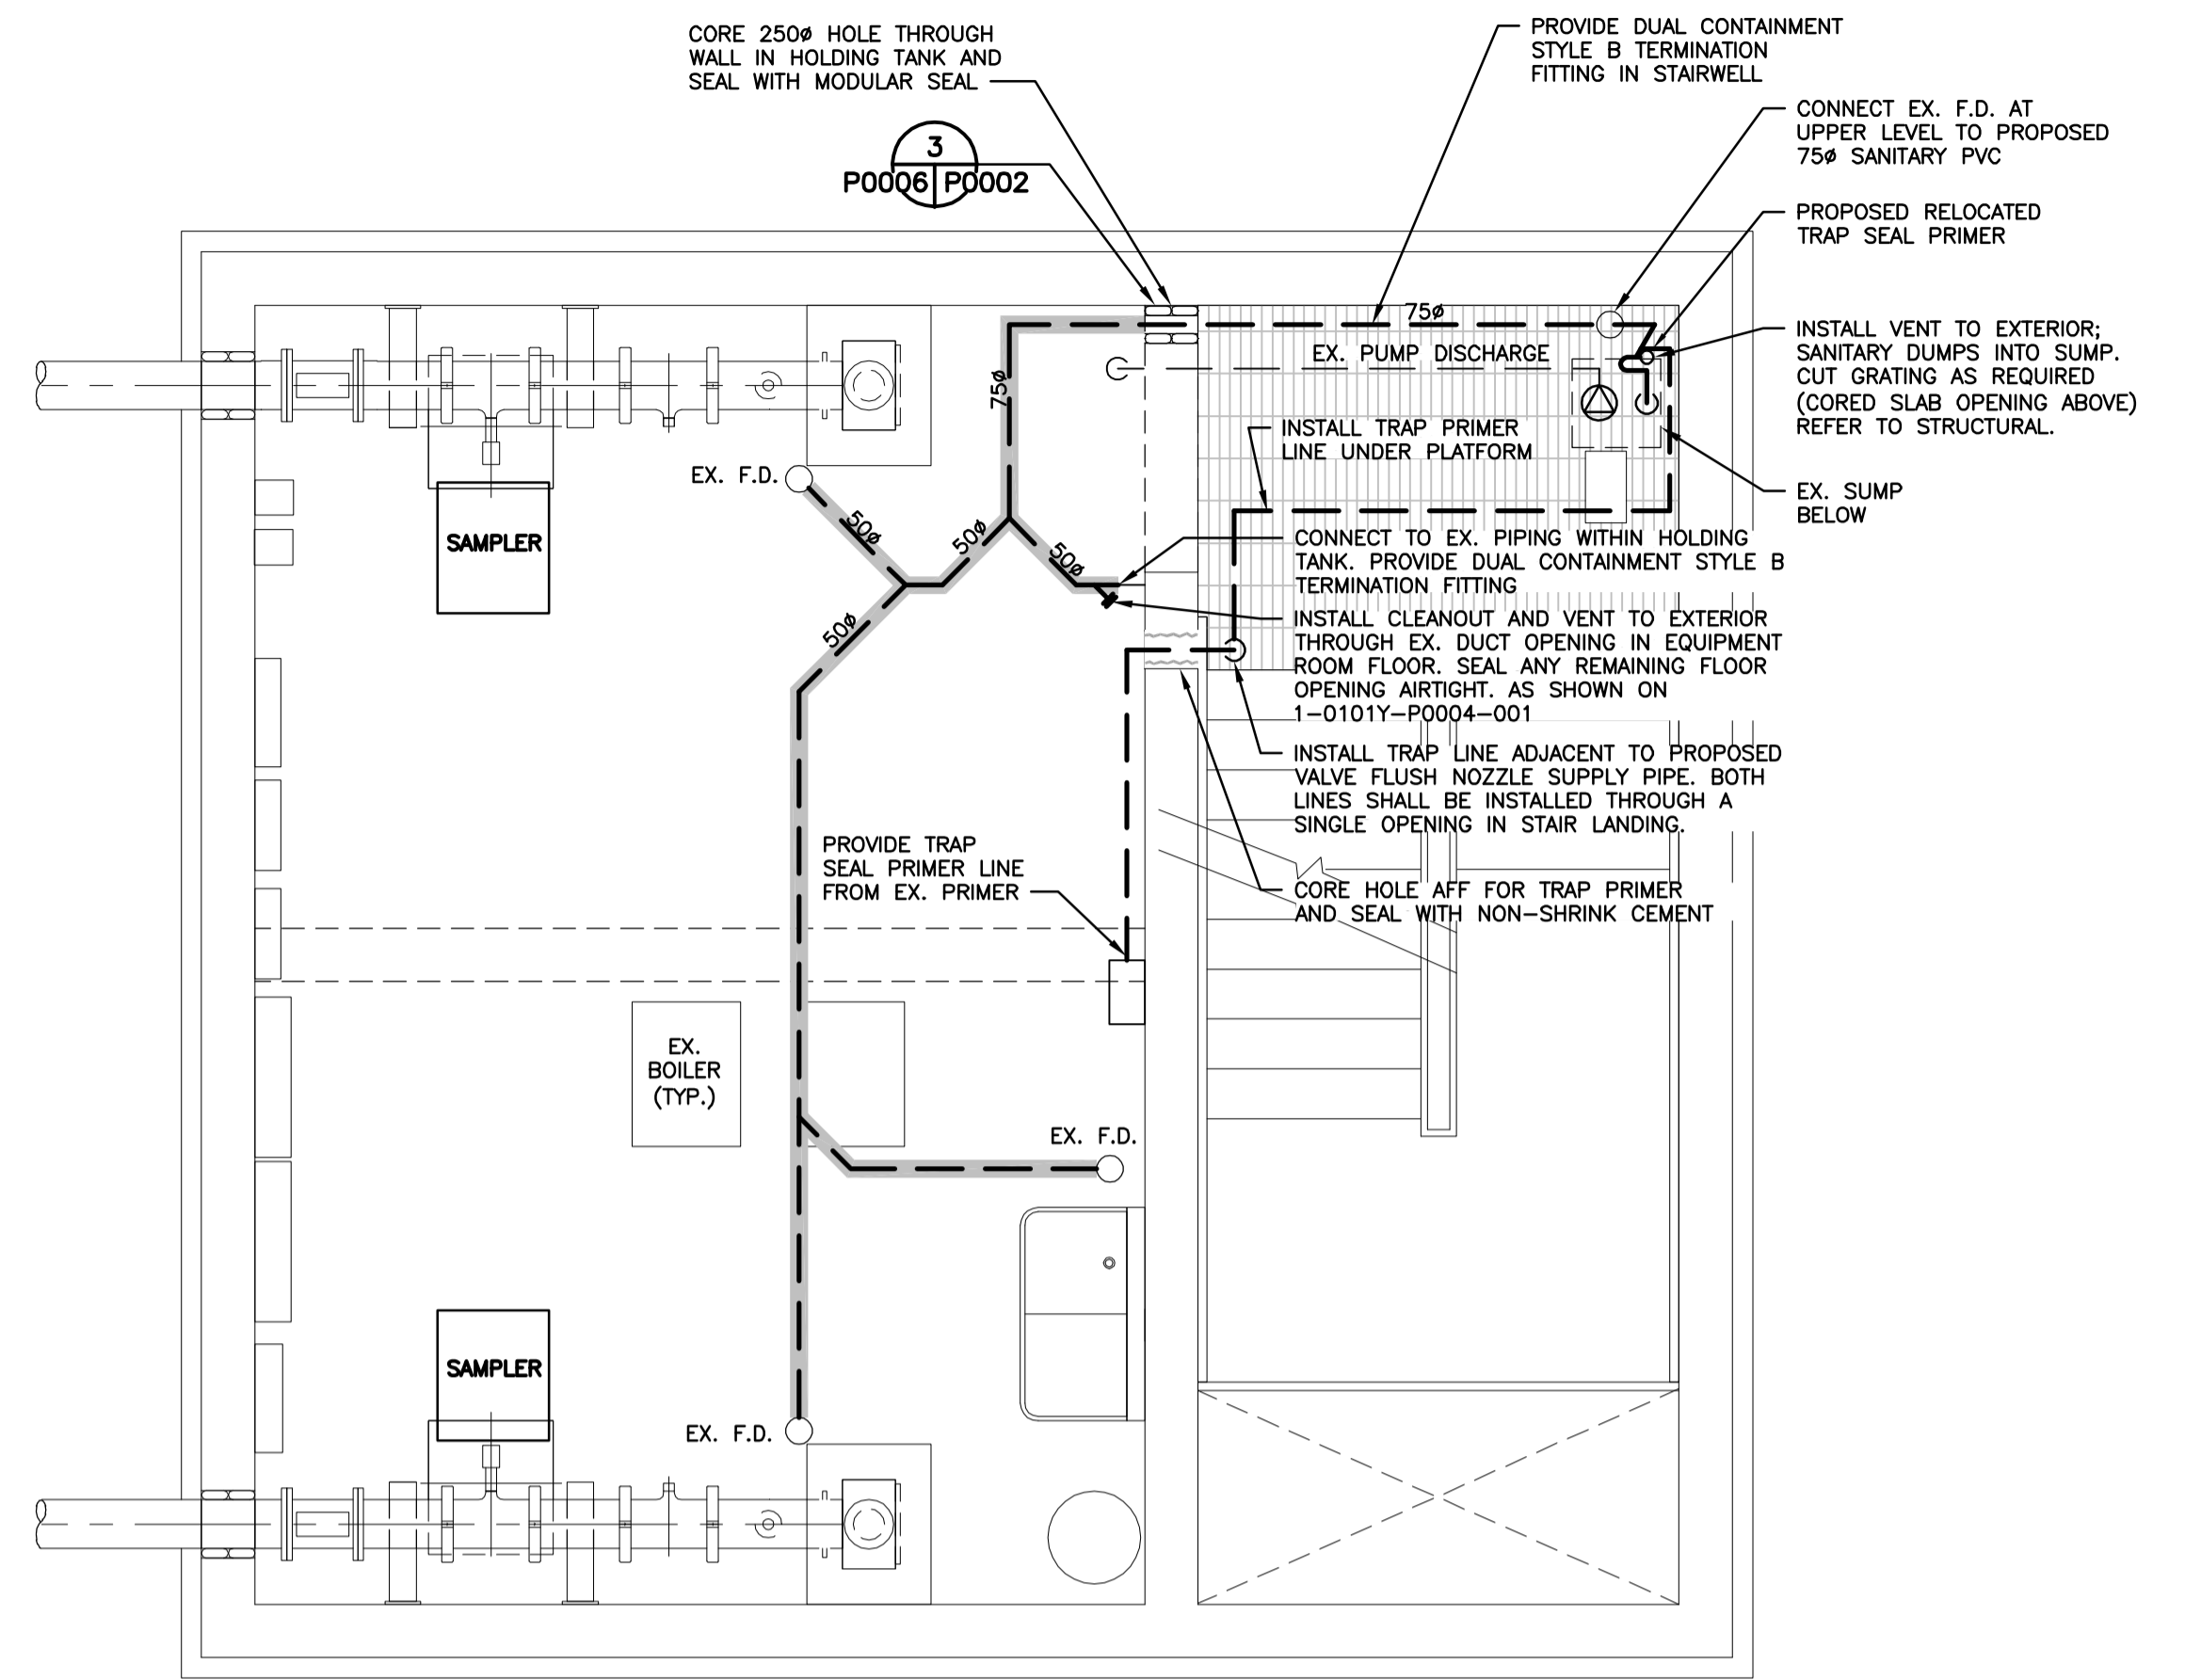

LEGEND
 --- DUAL CONTAINMENT PVC BELOW SLAB
 2
 -
 PROPOSED PLAN
 1:40

HAULED WASTEWATER BUILDING NO. 1&2

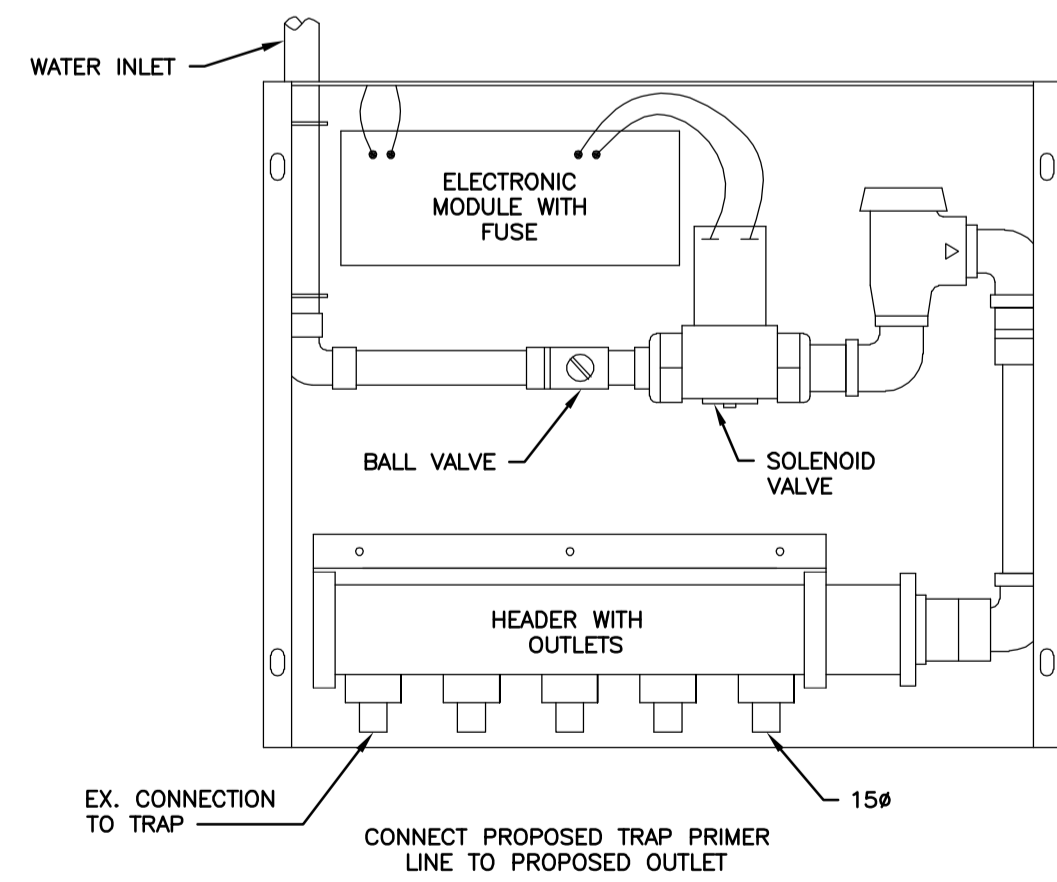

EX. FLOOR DRAIN TRAP PRIMER DETAIL

HAULED WASTEWATER BUILDING NO. 1
 (FORMERLY HAULED WASTEWATER BUILDING)
 HAULED WASTEWATER BUILDING NO. 2
 (FORMERLY LEACHATE RECEIVING BUILDING)

WARNING
 IF POWER EQUIPMENT OR EXPLOSIVES ARE TO BE USED FOR EXCAVATION ON THIS PROJECT THE CONTRACTOR MUST:
 1) NOTIFY THE GAS COMPANY OF THE PROPOSED LOCATION OF EXCAVATION.
 2) TAKE PRECAUTION TO AVOID DAMAGE TO GAS COMPANY INSTALLATIONS.
 SEE PROVINCIAL REGULATION 140/92 FOR DETAILS

METRIC
 WHOLE NUMBERS INDICATE MILLIMETRES
 DECIMALIZED NUMBERS INDICATE METRES

LOCATION APPROVED UNDERGROUND STRUCTURES		B.M.	ELEV.
SUPV. U/G STRUCTURES COMMITTEE	DATE		
NOTE: LOCATION OF UNDERGROUND STRUCTURES AS SHOWN ARE BASED ON THE BEST INFORMATION AVAILABLE BUT NO GUARANTEE IS GIVEN THAT ALL EXISTING UTILITIES ARE SHOWN OR THAT THE GIVEN LOCATIONS ARE EXACT. CONFIRMATION OF EXISTENCE AND EXACT LOCATION OF ALL SERVICES MUST BE OBTAINED FROM THE INDIVIDUAL UTILITIES BEFORE PROCEEDING WITH CONSTRUCTION.			
NO.	REVISIONS	DATE	BY
3	ISSUED FOR TENDER	16.03.09	S.K.B.
2	ISSUED FOR TENDER REVIEW	16.03.07	S.K.B.
1	ISSUED FOR 95% REVIEW	16.01.29	S.K.B.

Stantec 500-311 Portage Ave, Winnipeg MB Canada www.stantec.com		ENGINEER'S SEAL PROVINCE OF MANITOBA R. Gillis R.J. Gillis March 16/16 24774 REGISTERED PROFESSIONAL ENGINEER	
DESIGNED BY	R.G.	CHECKED BY	S.A.B.
DRAWN BY	K.R.	APPROVED BY	S.K.B.
HOR. SCALE:	AS NOTED	RELEASED FOR CONSTRUCTION:	
VERTICAL:		DATE	
NO.	REVISIONS	DATE	BY
3	ISSUED FOR TENDER	16.03.09	S.K.B.
2	ISSUED FOR TENDER REVIEW	16.03.07	S.K.B.
1	ISSUED FOR 95% REVIEW	16.01.29	S.K.B.

APEGM Certificate of Authorization Stantec Consulting Ltd. No. 1301		THE CITY OF WINNIPEG WATER AND WASTE DEPARTMENT Winnipeg	
NORTH END SEWAGE TREATMENT PLANT (NEWPC) HAULED LIQUID WASTE FACILITY PHASE II UPGRADE			
HAULED WASTEWATER BUILDINGS I & 2 SANITARY PLAN UPGRADES			
TENDER NO. 952-2015	CITY DRAWING NUMBER I-0101Y-P0006-001	SHEET OF 6 OF 8	