




GROUND FLOOR PLAN
 1:50
 0 500 1000 1500 2000 2500

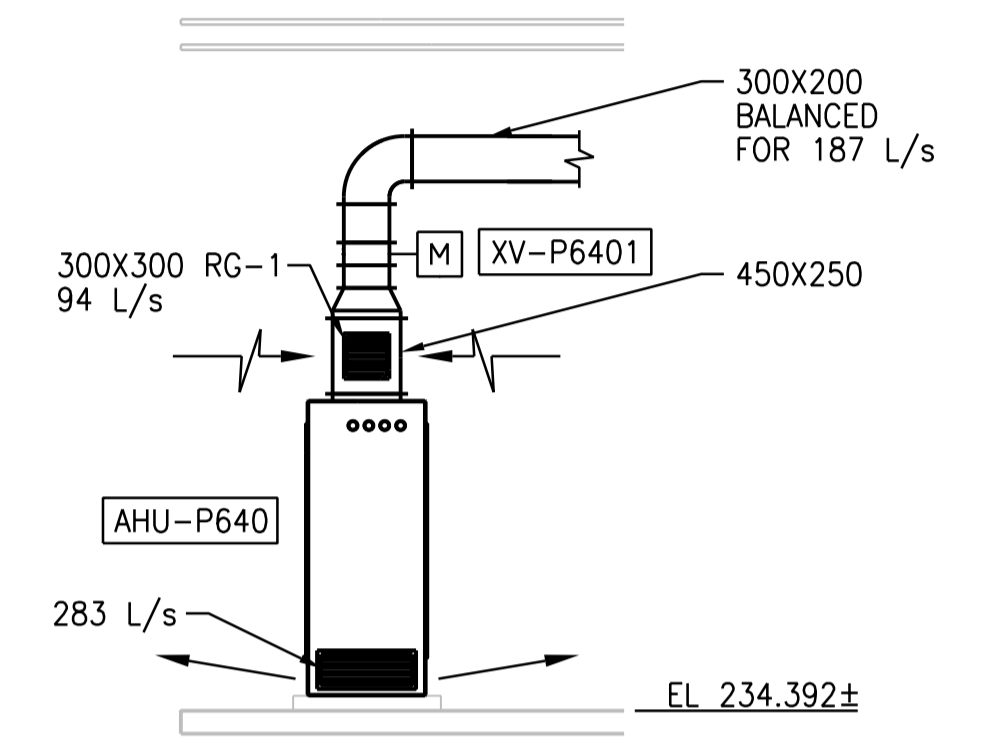

A SECTION
 1:50

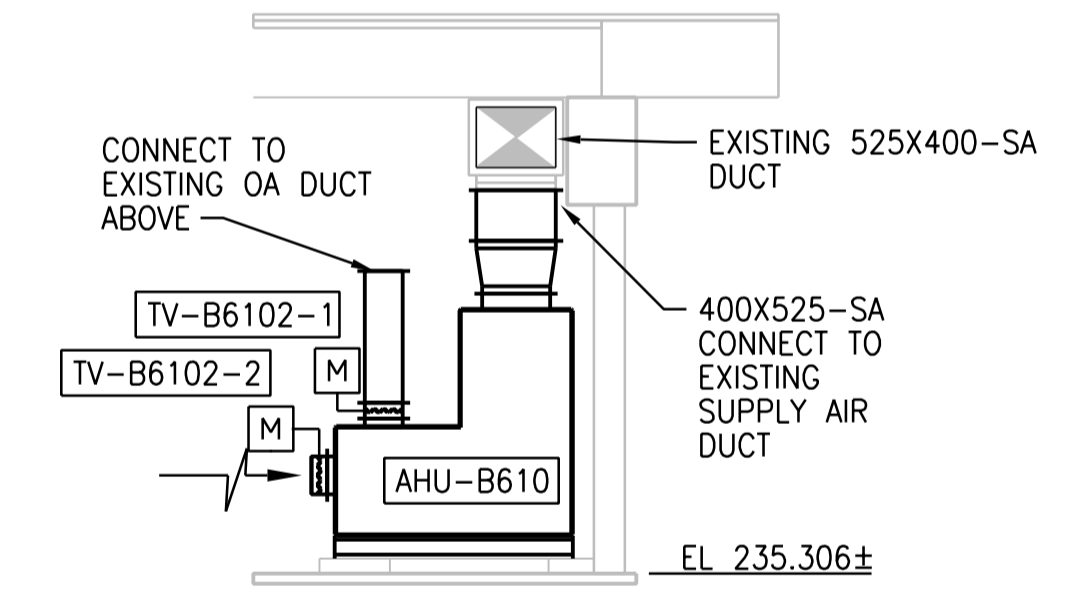

B SECTION
 1:50

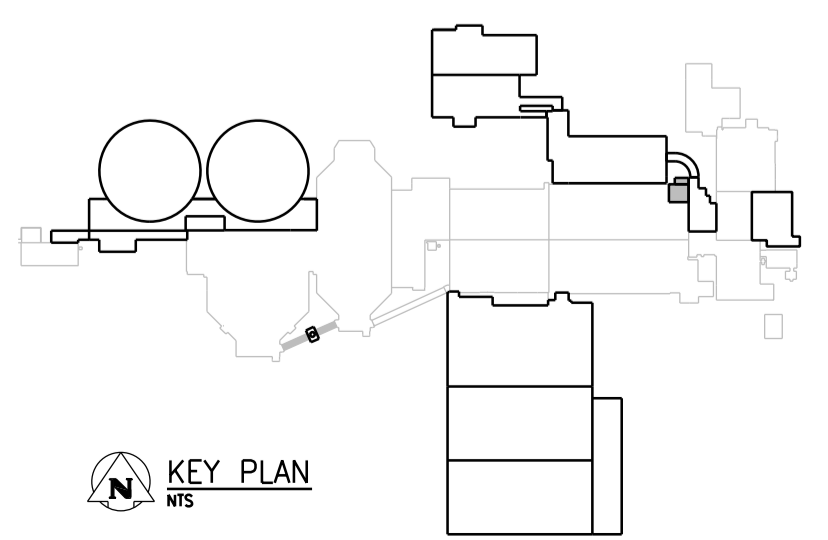

APEGM
 Certificate of Authorization
 CH2M HILL Canada Ltd.
 No. 1441

NO.	REVISIONS	DATE	DESIGN	CHECK
01	ISSUED FOR ADDENDUM 3 - 976-2016	2017/06/21	K.F.	J.C.
00	ISSUED FOR CONSTRUCTION - 976/2016	2017/04/05	K.F.	J.C.

CH2MHILL
 SNC-LAVALIN
 DESIGNED BY: T. TRAN
 DRAWN BY: A. BERSHTEIN
 SCALE: 1:50
 DATE: 2017/04/05
 CONSULTANT NO.: 474248

KCS GROUP
 CHECKED BY: T. TRAN
 APPROVED BY: H.T. FREIHAMMER
 ISSUED FOR CONSTRUCTION BY: J. SHUMKA
 DATE: 2017/04/05

ENGINEER'S SEAL
 21 June 2017
 PROVINCE OF MANITOBA
 T.T. TRAN
 Member
 40578
 REGISTERED PROFESSIONAL ENGINEER

THE CITY OF WINNIPEG
 WATER AND WASTE DEPARTMENT
 SOUTH END WATER POLLUTION CONTROL CENTRE
 SEWPCC UPGRADING/EXPANSION PROJECT
 MECHANICAL
 PRIMARY CLARIFIERS
 PARTIAL PLAN

CITY DRAWING NUMBER: 1-0102-MGAD-P602
 SHEET: 001
 REV.: 01
 SIZE: A1