




NOTES:

1. SEE DRAWINGS 'S01' & 'S03' FOR PILE DETAILS.
2. ELEVATION E1 (TOP OF PILE) TO BE 150mm ABOVE GRADE.
3. ELEVATION E2 (TOP OF PILE) TO BE 1000mm ABOVE GRADE.

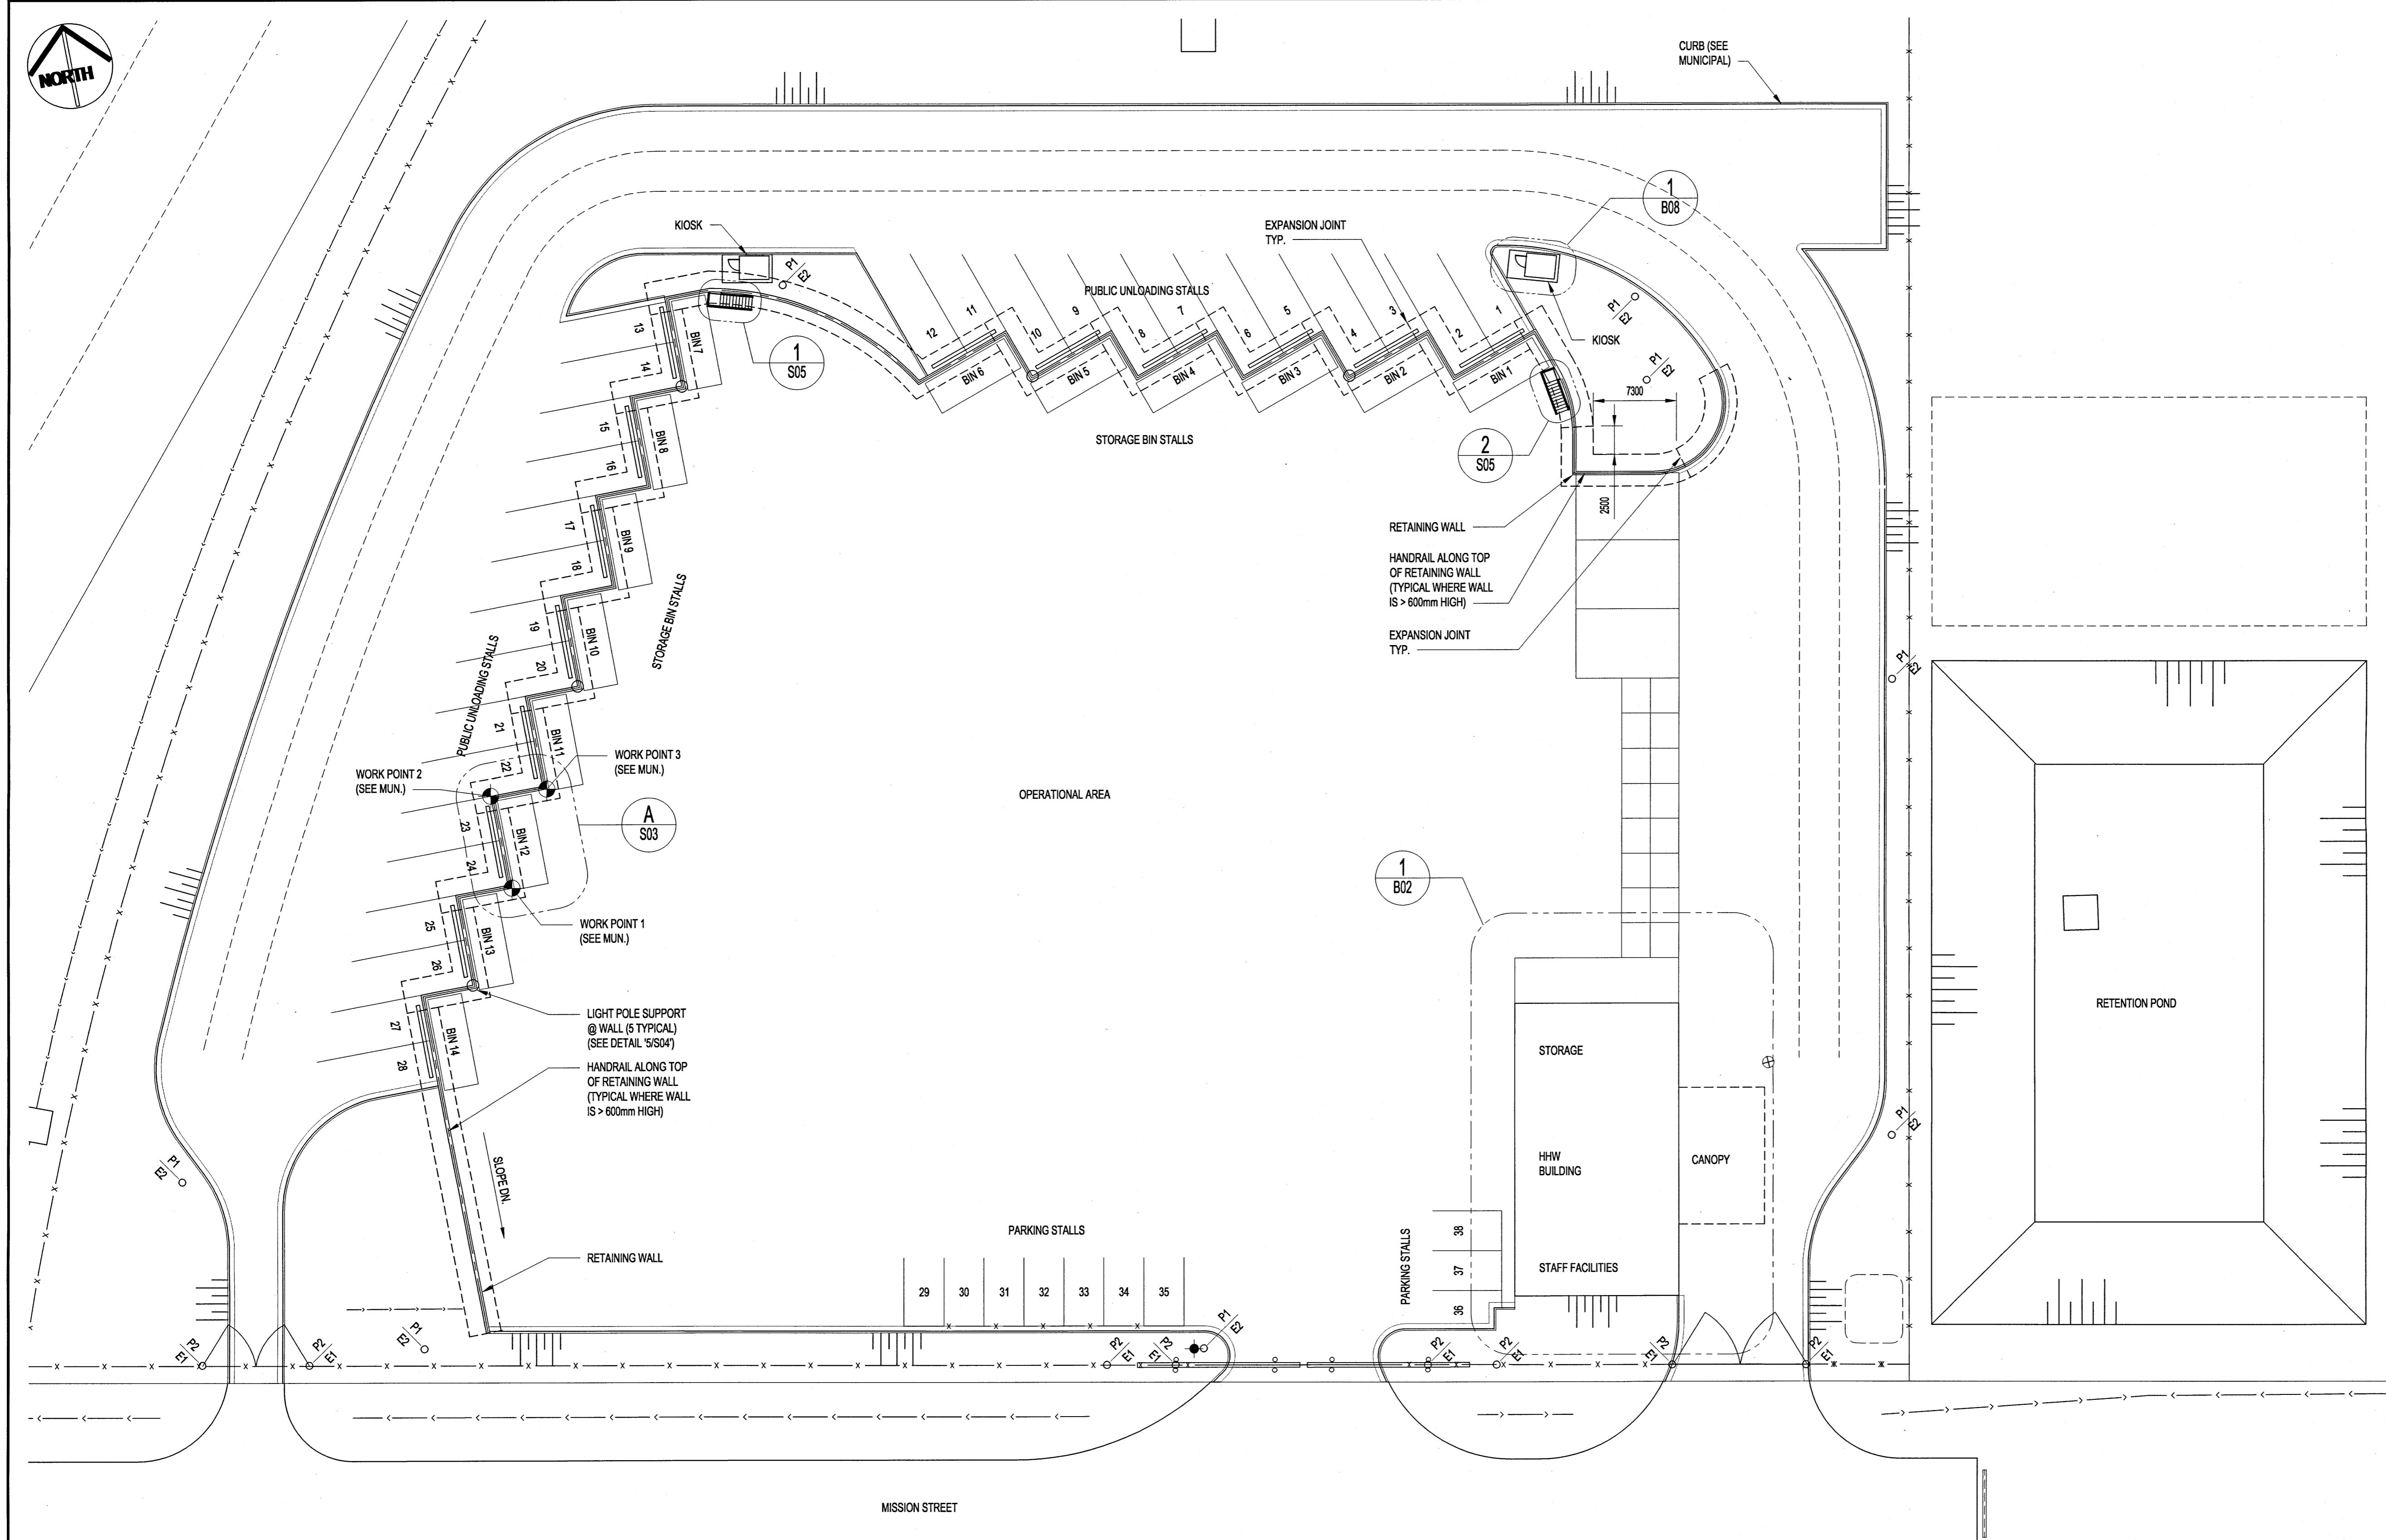

1 SITE PLAN
SCALE: 1:300

16-0107-010\16-0107-010_B01.dwg

LOCATION APPROVED UNDERGROUND STRUCTURES

SUPV. U/G STRUCTURES COMMITTEE DATE

NOTE:
LOCATION OF UNDERGROUND STRUCTURES AS SHOWN ARE BASED ON THE BEST INFORMATION AVAILABLE BUT NO GUARANTEE IS GIVEN THAT ALL EXISTING UTILITIES ARE SHOWN OR THAT THE GIVEN LOCATIONS ARE EXACT. CONFIRMATION OF EXISTENCE AND EXACT LOCATION OF ALL SERVICES MUST BE OBTAINED FROM THE INDIVIDUAL UTILITIES BEFORE PROCEEDING WITH CONSTRUCTION.

| B.M. ELEV. | NO. | REVISIONS | DATE | BY |
|------------|-----|-------------------|----------|-------------|
| | 0 | ISSUED FOR TENDER | 17/03/29 | [Signature] |

KGS GROUP CONSULTING ENGINEERS

DESIGNED BY: DJP
DRAWN BY: JAR

CHECKED BY: [Signature]
APPROVED BY: [Signature]

HOR. SCALE: AS NOTED
VERTICAL: AS NOTED

DATE: 16/08/11

RELEASED FOR CONSTRUCTION: [Signature]
DATE:

ENGINEER'S SEAL
[Professional Seal: PETRAK Member 24082]
CONSULTANT PROJECT NO. 16-0107-010

THE CITY OF WINNIPEG WATER AND WASTE DEPARTMENT

PROJECT TITLE: 4R WINNIPEG DEPOT EAST WINNIPEG COMMUNITY RESOURCE RECOVERY CENTRE

GENERAL ARRANGEMENT OF STRUCTURES

SHEET 09 OF 41
COMPUTER FILE NAME: 16-0107-010
CONSULTANT DRAWING NUMBER: B01