

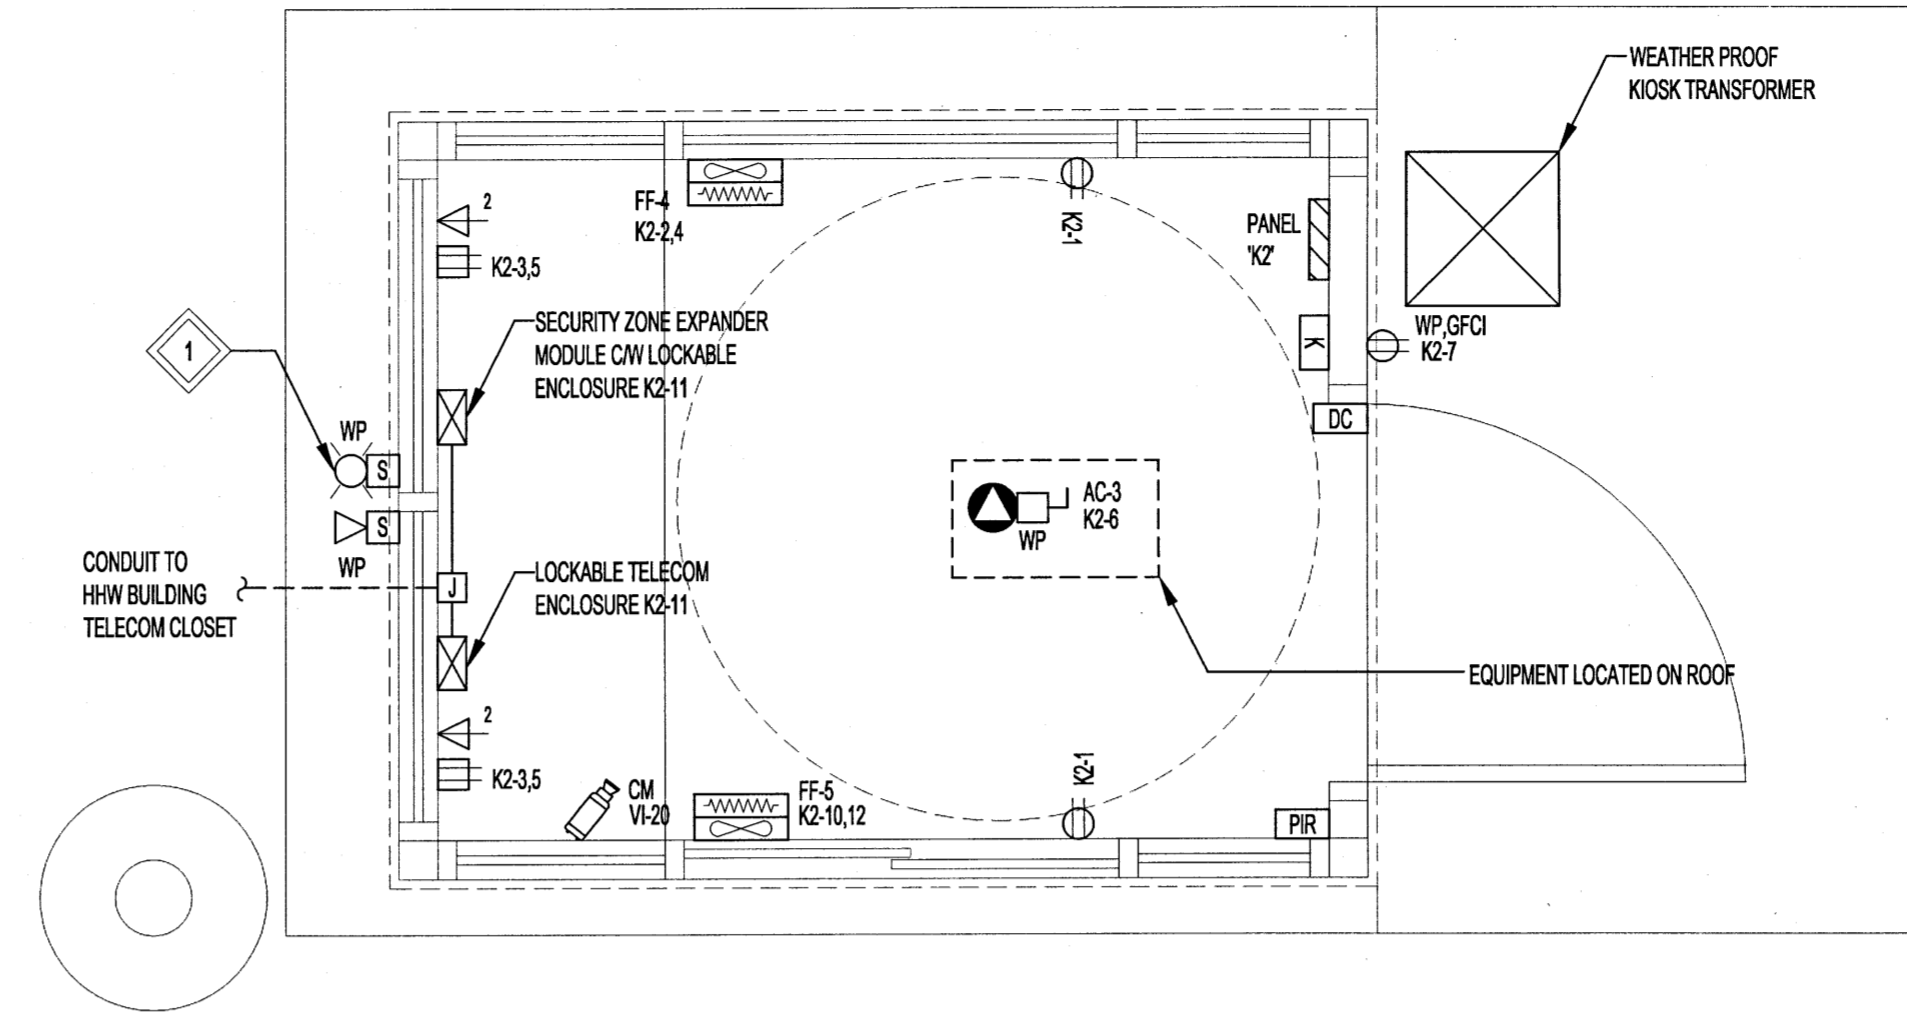
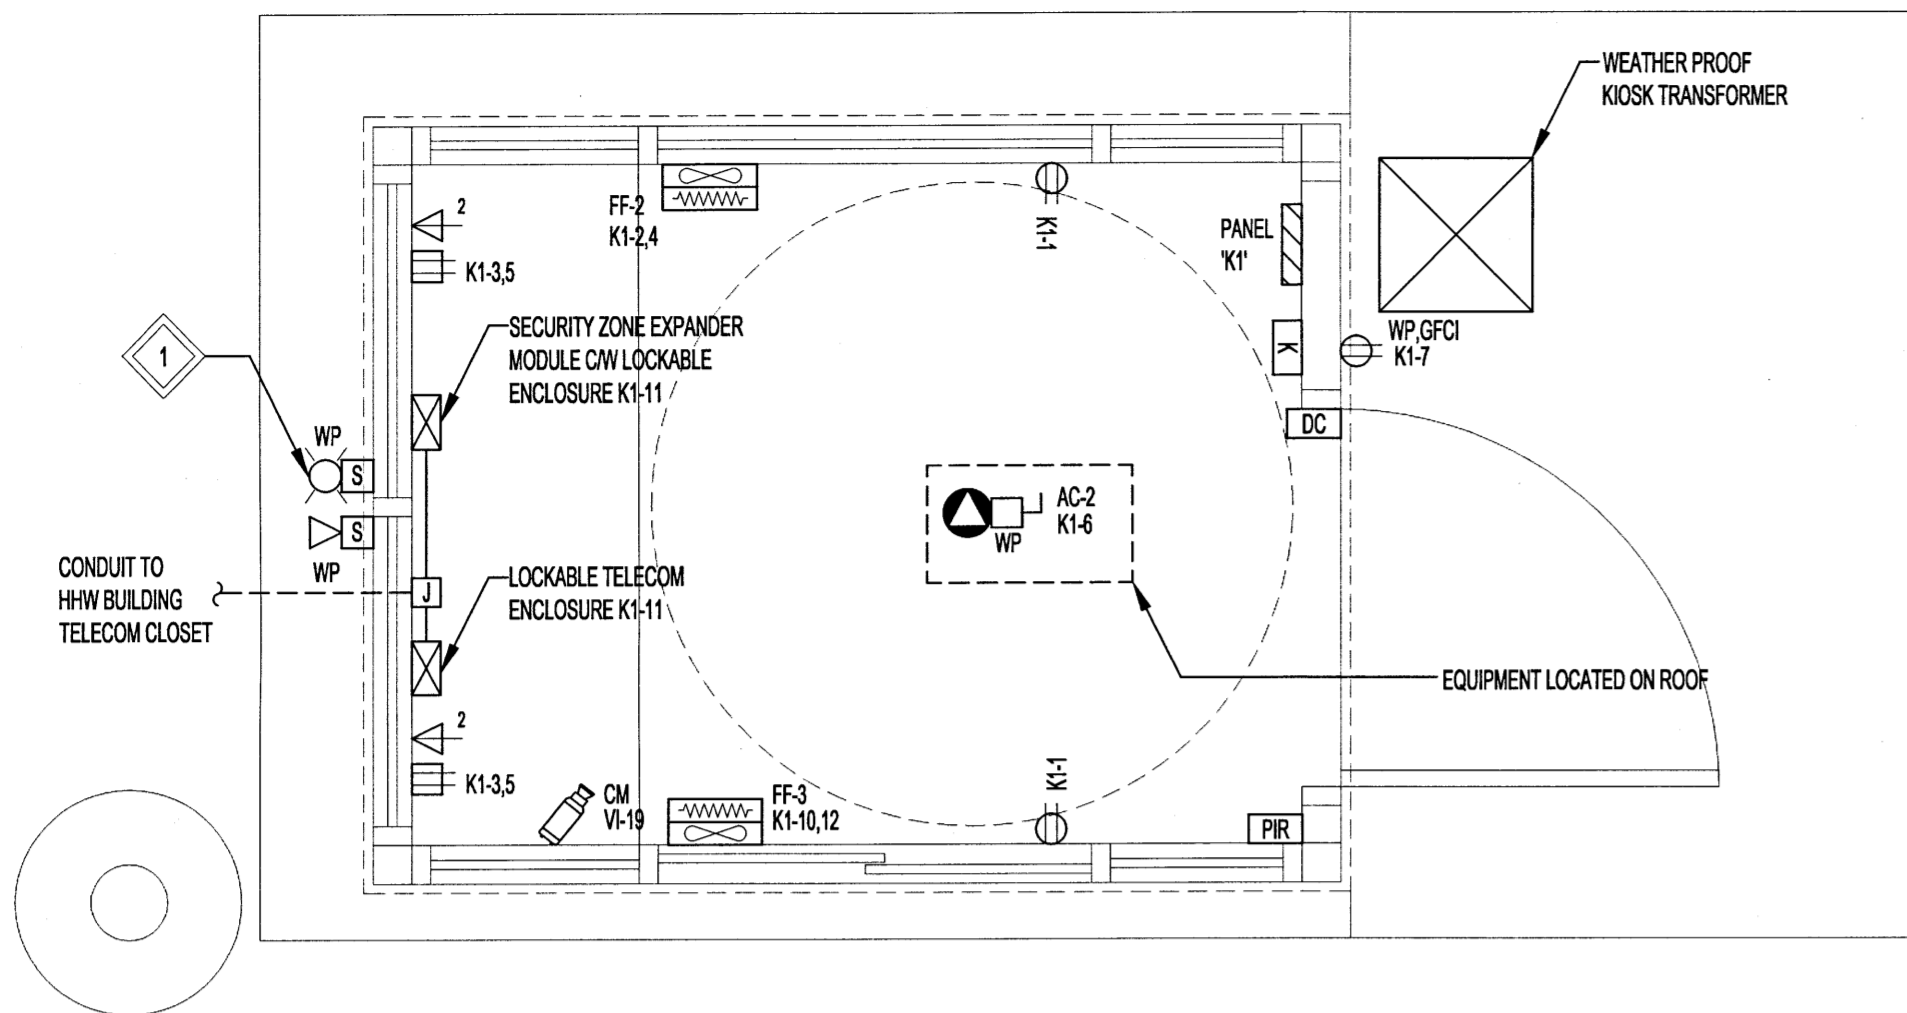


KEYNOTES:
 1 MOUNT THE EXTERIOR SECURITY STROBE 600mm ABOVE THE ROOF LINE ON A GALVANIZED RIGID STEEL CONDUIT.

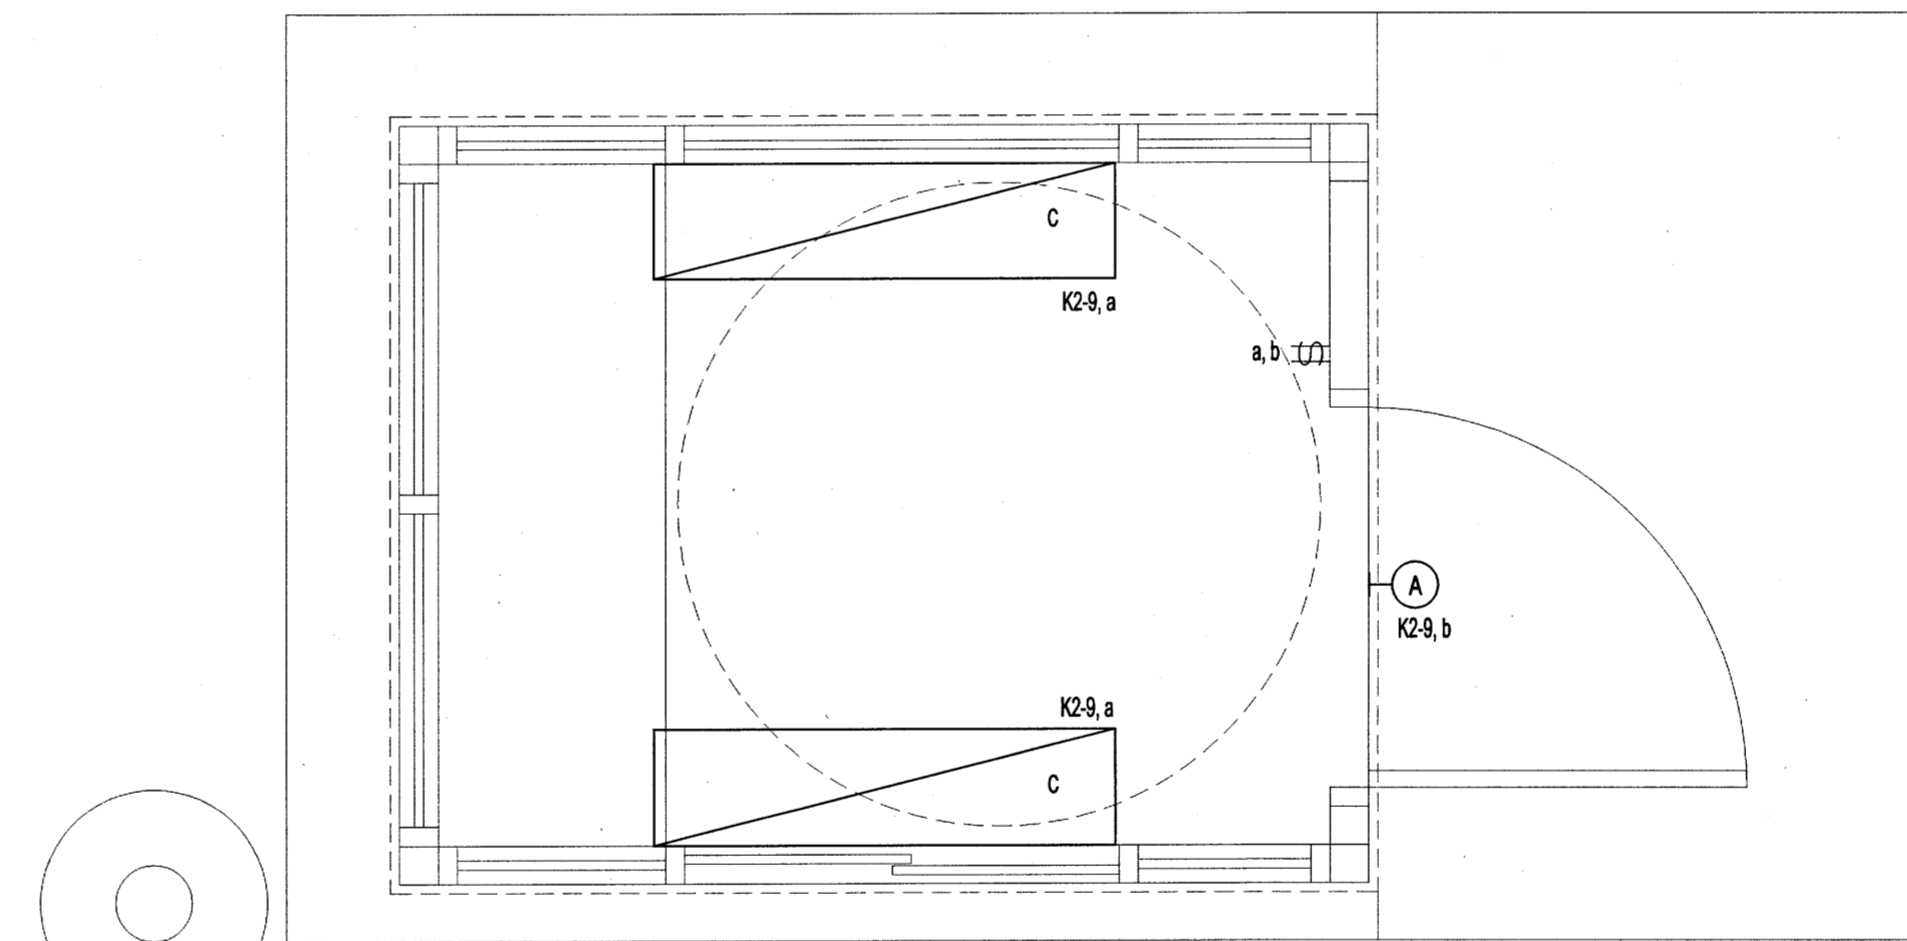


1 KIOSK #1 FLOOR PLAN - POWER & SYSTEMS
 SCALE: 1:20mm (24"x36")

3 KIOSK #2 FLOOR PLAN - POWER & SYSTEMS
 SCALE: 1:20mm (24"x36")

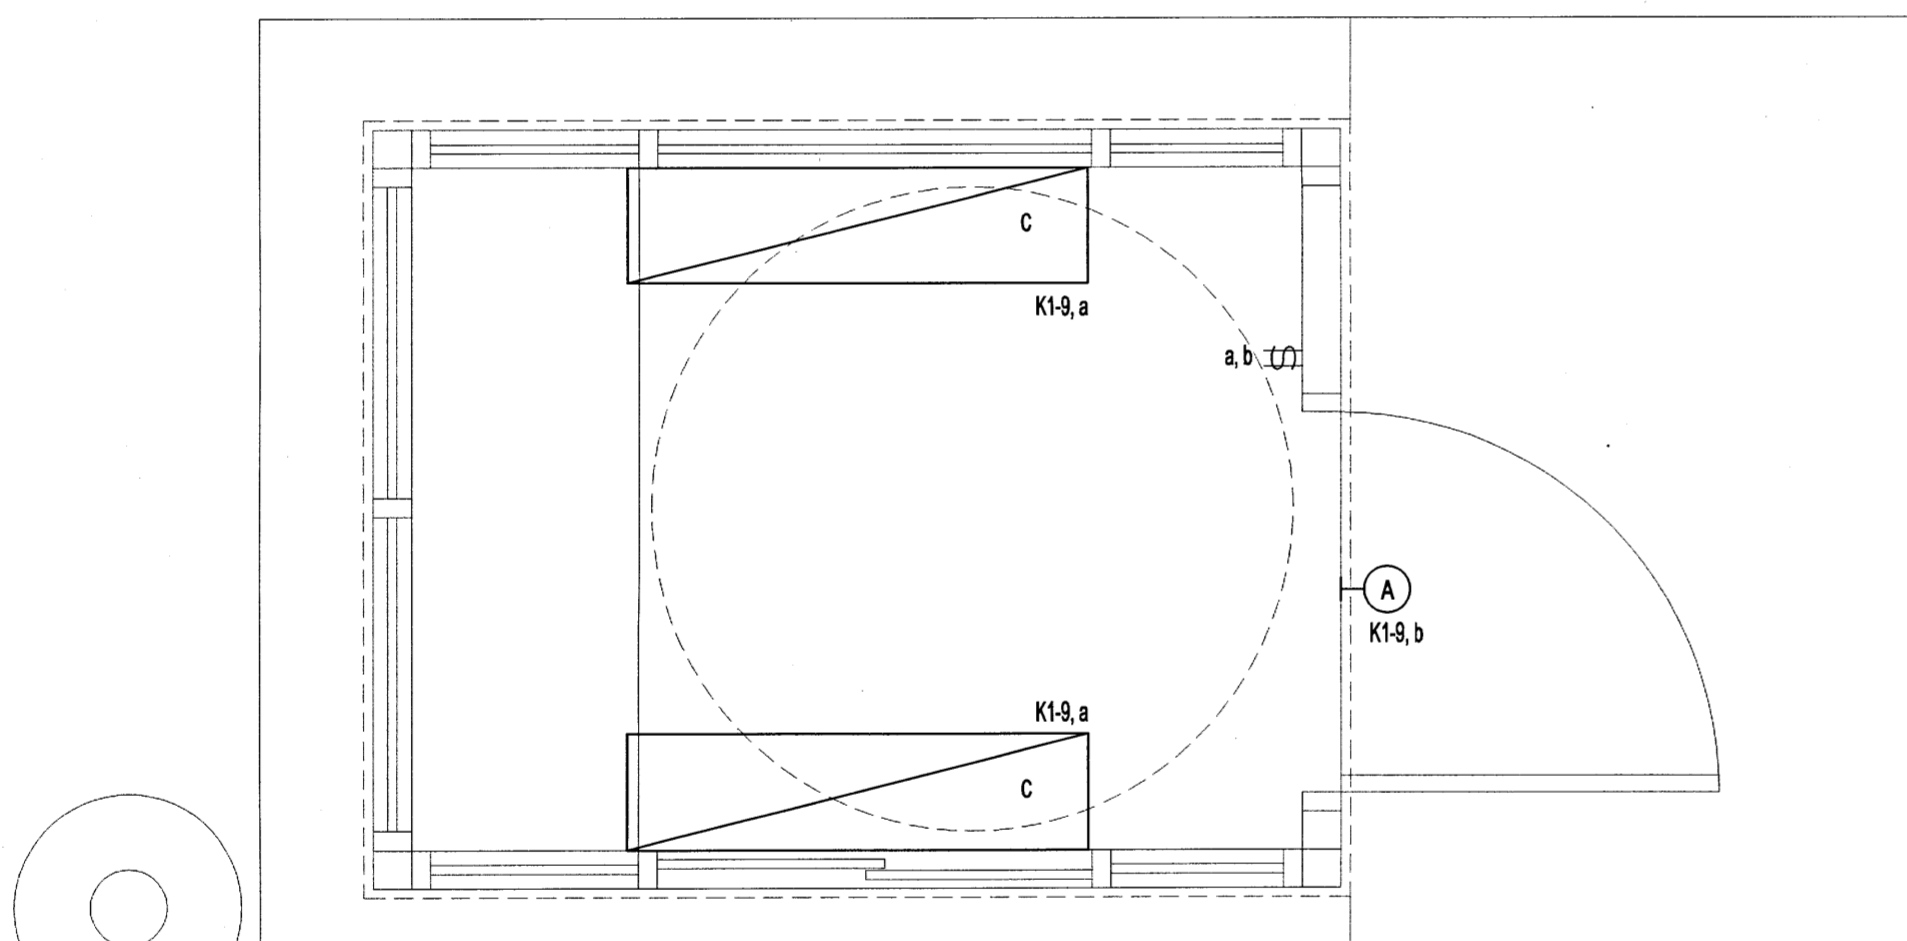

2 KIOSK #1 FLOOR PLAN - LIGHTING
 SCALE: 1:20mm (24"x36")

4 KIOSK #2 FLOOR PLAN - LIGHTING
 SCALE: 1:20mm (24"x36")

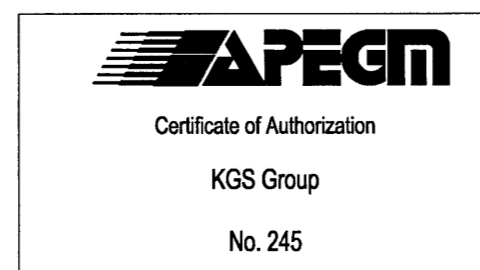

LOCATION APPROVED UNDERGROUND STRUCTURES
 SUPV. U/G STRUCTURES COMMITTEE DATE
 NOTE: LOCATION OF UNDERGROUND STRUCTURES AS SHOWN ARE BASED ON THE BEST INFORMATION AVAILABLE BUT NO GUARANTEE IS GIVEN THAT ALL EXISTING UTILITIES ARE SHOWN OR THAT THE GIVEN LOCATIONS ARE EXACT. CONFIRMATION OF EXISTENCE AND EXACT LOCATION OF ALL SERVICES MUST BE OBTAINED FROM THE INDIVIDUAL UTILITIES BEFORE PROCEEDING WITH CONSTRUCTION.

NO.	REVISIONS	DATE	BY
0	ISSUED FOR TENDER	17/03/14	CLS

KGS GROUP CONSULTING ENGINEERS	
DESIGNED BY: CLS	CHECKED BY: CBS
DRAWN BY: SOC	APPROVED BY: CLS
HOR. SCALE: AS NOTED	RELEASED FOR CONSTRUCTION: DATE
VERTICAL: AS NOTED	DATE: 16/09/17

ENGINEER'S SEAL
 CONSULTANT PROJECT NO. 16-0107-010

THE CITY OF WINNIPEG WATER AND WASTE DEPARTMENT
 PROJECT TITLE: 4R WINNIPEG DEPOT EAST WINNIPEG COMMUNITY RESOURCE RECOVERY CENTRE KIOSK BUILDING

SHEET 32 OF 40
 COMPUTER FILE NAME: 16-0107-010
 CONSULTANT DRAWING NUMBER: E07