


**LEGEND**

- UNDERPASS SURFACE MOUNTED LIGHT FIXTURE WATER RESISTANT

**NOTES**

- TUNNEL LIGHT FIXTURE CONTROL WIRING AND POWER WIRING TO BE THE SAME INSULATION RATING. MAINTAIN MINIMUM 50mm SPACE BETWEEN LIGHT DIMMING CONTROL WIRING CONDUIT AND LIGHT POWER WIRING CONDUIT.
- PROVIDE STAINLESS STEEL GASKETTED COVER PLATE FOR THE TWO 200x200x100 PULLBOXES EMBEDDED IN THE CONCRETE CHAMFER AT THE NORTH END OF THE TUNNEL. COVER FASTENING HARDWARE TO BE VANDAL PROOF TYPE.
- CONTRACTOR TO ORDER 18 LIGHT FIXTURES (2 SPARE, TO BE TURNED OVER TO CITY OF WINNIPEG).

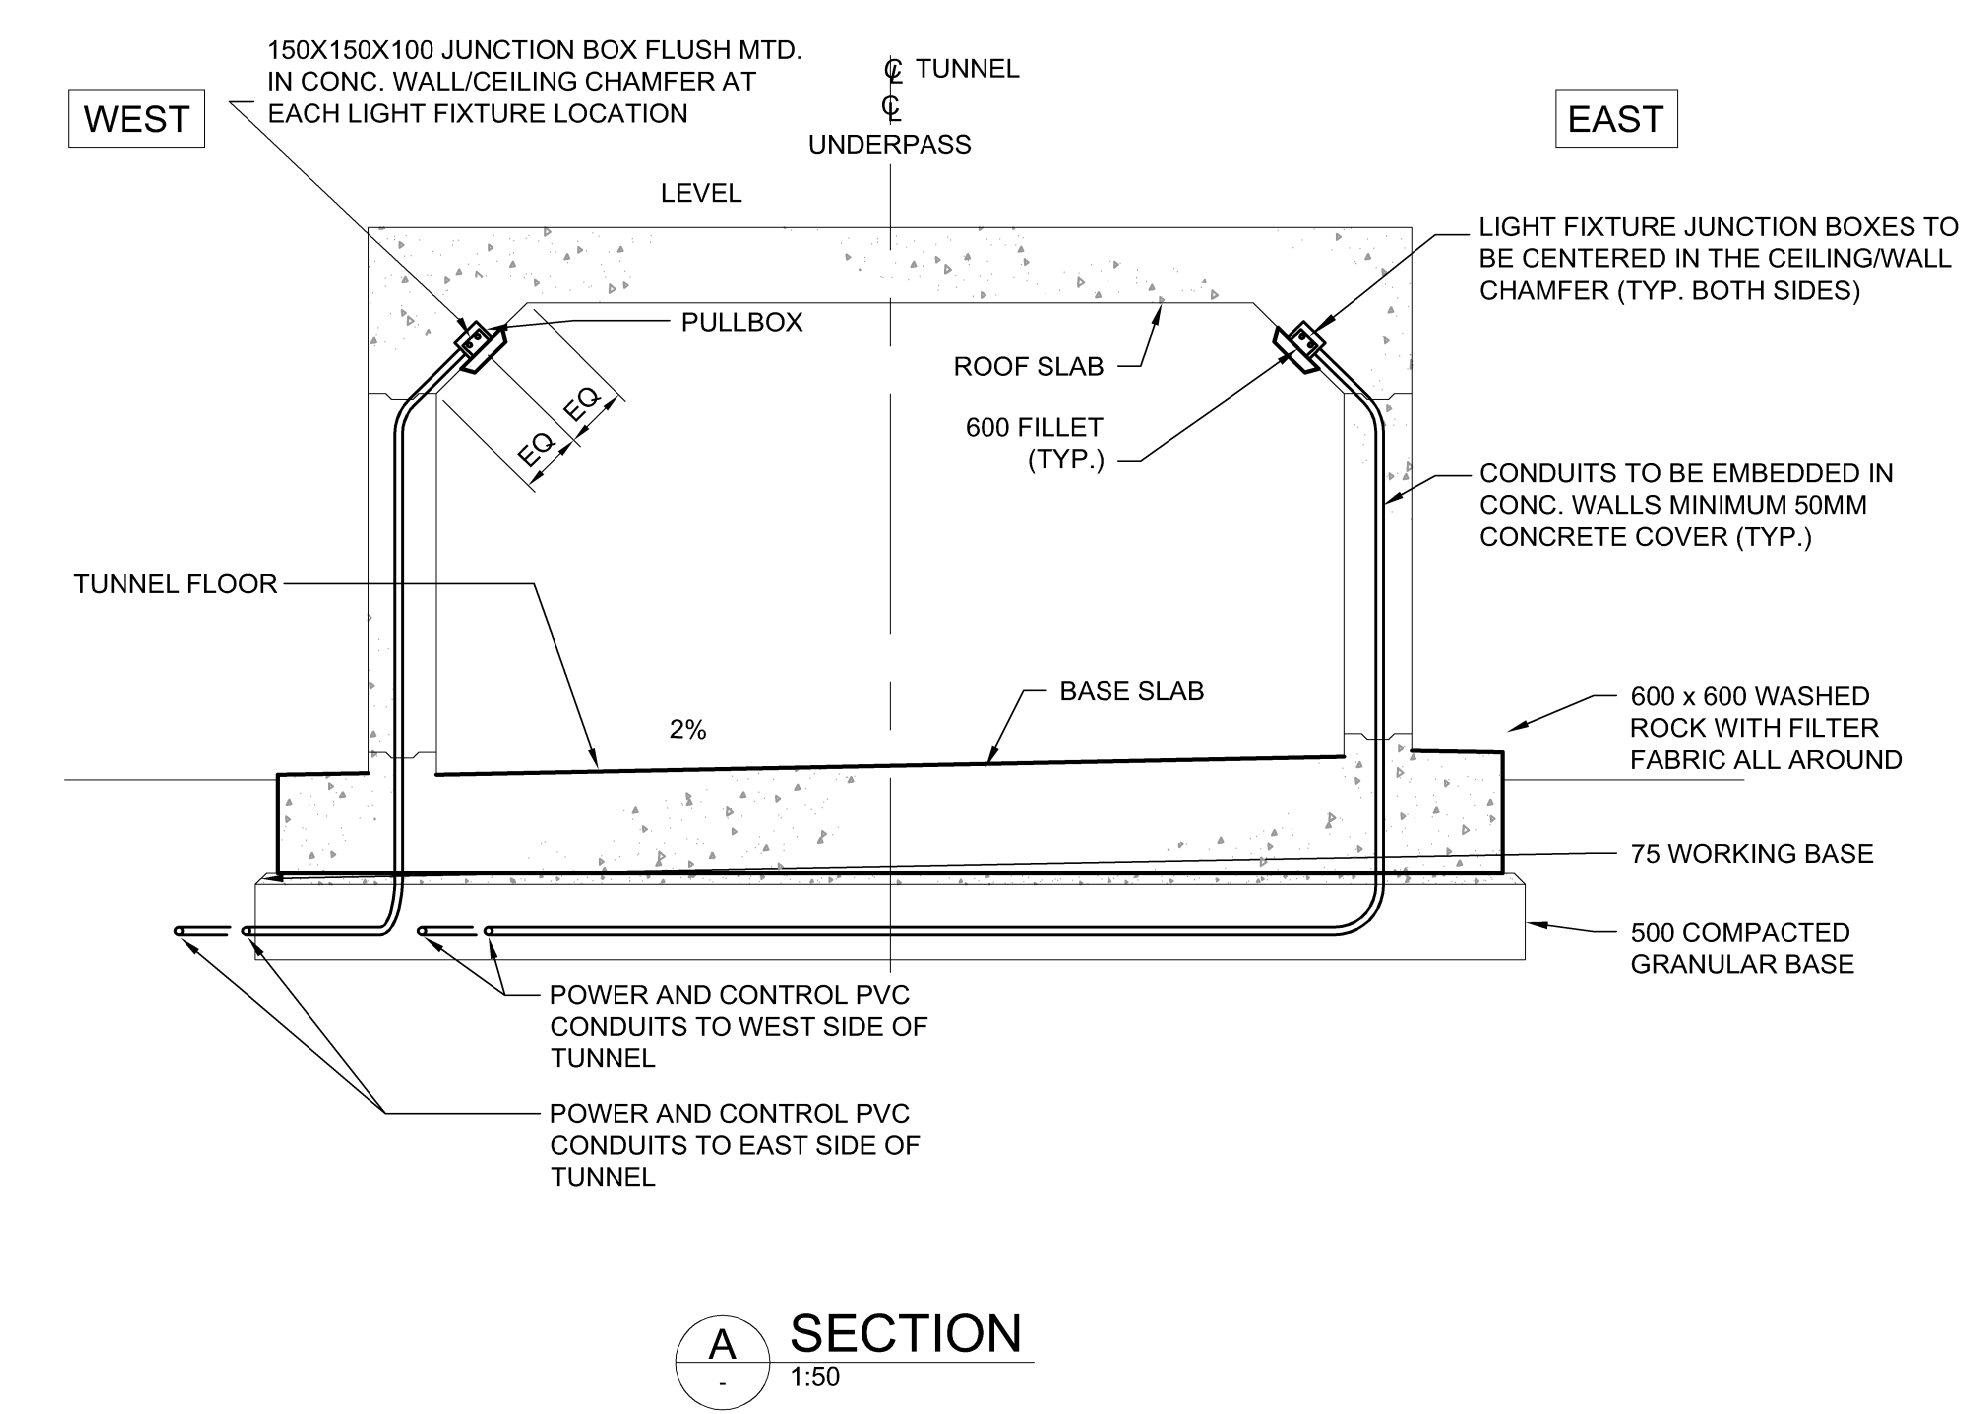

**PLAN**  
1:100

**A SECTION**  
1:50

G:\CAD\175932\Drawings\Structural\Contract\UNDERPASS\175932-UNDERPASS-CON-CE-LIGHTING-PLANS.dwg



DESIGNED BY	BLM	CHECKED BY	BLM
DRAWN BY	SK	APPROVED BY	MBL
HOR. SCALE	AS SHOWN	RELEASED FOR CONSTRUCTION	
VERTICAL	AS SHOWN		
ISSUED FOR TENDER	18/02/09	DRA	
NO. REVISIONS	DATE	BY	DATE
			2018/02/09

ENGINEER'S SEAL  
  
 B.L. MOORE  
 REGISTERED PROFESSIONAL ENGINEER  
 CONSULTANT PROJECT NUMBER  
 17-5932

**THE CITY OF WINNIPEG**  
 PUBLIC WORKS DEPARTMENT  
  
**FERMOR AVENUE BRIDGE OVER SEINE RIVER**  
 BRIDGE RE-HABILITATION, PEDESTRIAN-CYCLIST UNDERPASS STRUCTURE AND ROADWORKS FROM ST. ANNE'S ROAD TO ARCHIBALD STREET  
 PEDESTRIAN-CYCLIST UNDERPASS LIGHTING PLAN  
 CITY DRAWING NUMBER: U-243-2017-CS-081  
 SHEET 081 OF 100  
 CONSULTANT DRAWING NUMBER: CS-081